


ROUTE NO.	SECTION	COUNTY	TOTAL SHEETS	SHEET NO.
F.A.I. 94	*	COOK	110	81
F.H.W.A. REGION - 1 ILLINOIS PROJECT				
* 10:0.1 B-R 1012.1 (85)				

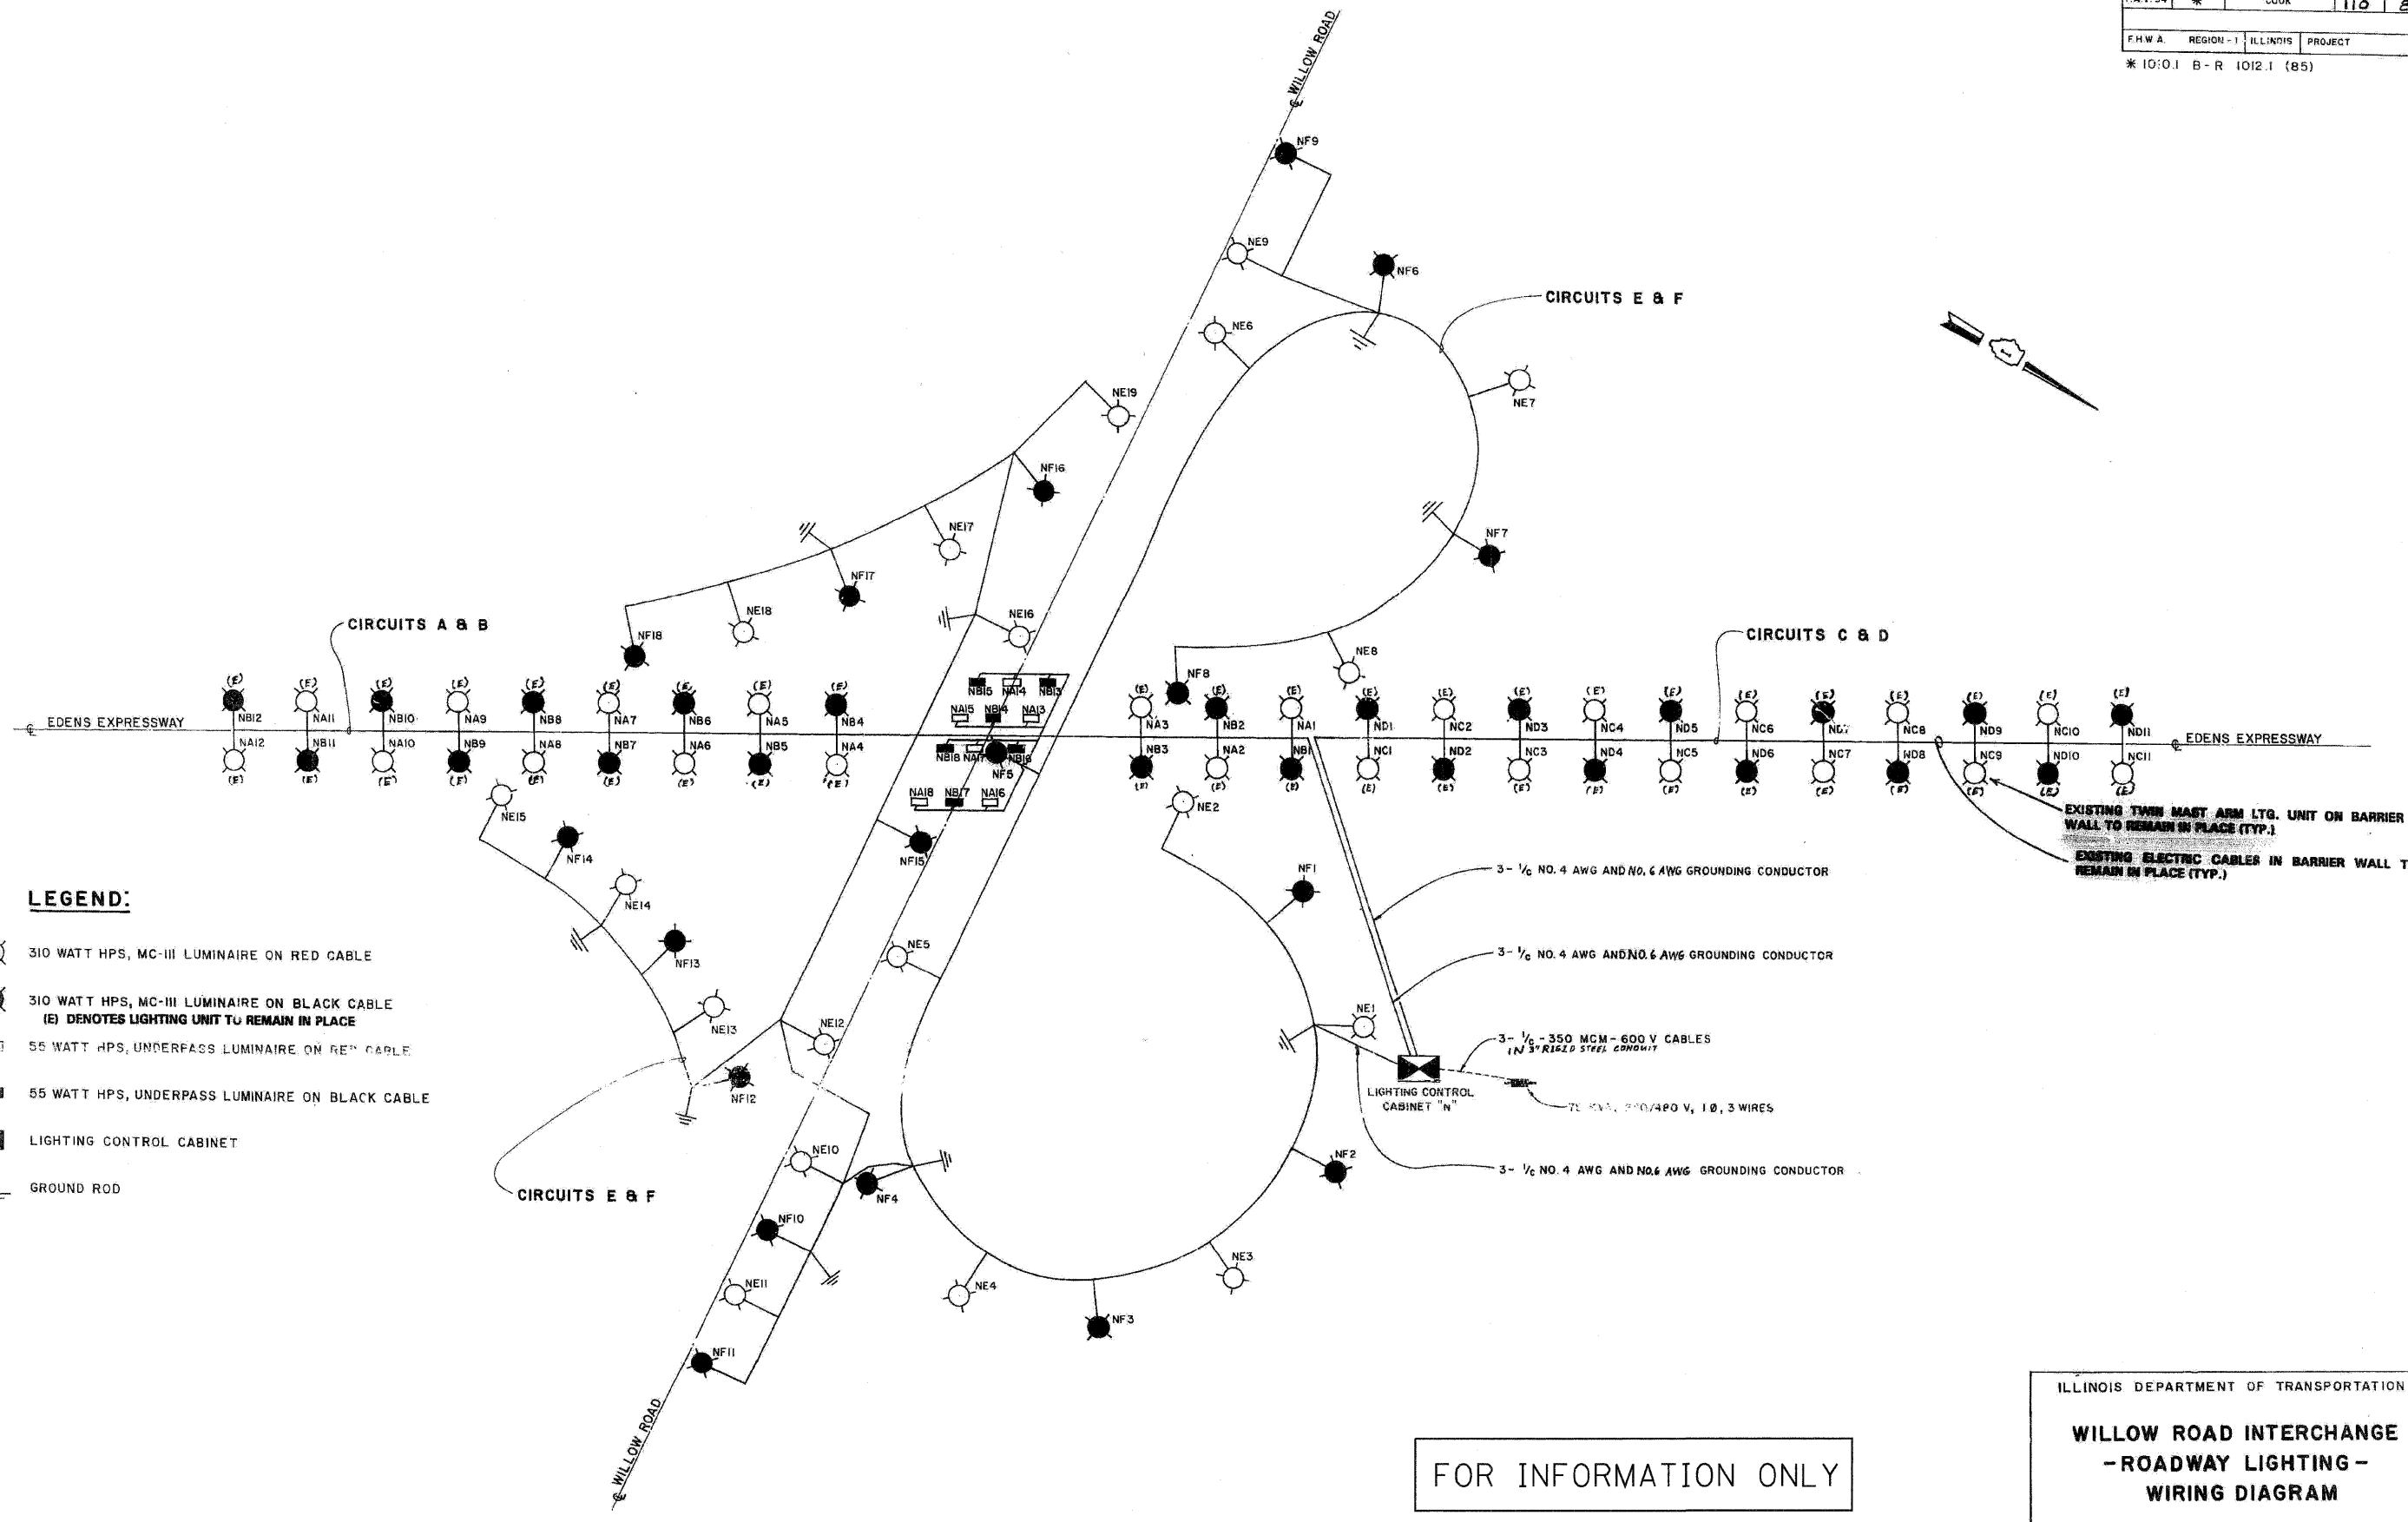

LEGEND:

- 310 WATT HPS, MC-III LUMINAIRE ON RED CABLE
- 310 WATT HPS, MC-III LUMINAIRE ON BLACK CABLE
(E) DENOTES LIGHTING UNIT TO REMAIN IN PLACE
- 55 WATT HPS, UNDERPASS LUMINAIRE ON RED CABLE
- 55 WATT HPS, UNDERPASS LUMINAIRE ON BLACK CABLE
- LIGHTING CONTROL CABINET
- GROUND ROD

FOR INFORMATION ONLY

ILLINOIS DEPARTMENT OF TRANSPORTATION
WILLOW ROAD INTERCHANGE
-ROADWAY LIGHTING-
WIRING DIAGRAM
 SCALE: NONE DRAWN BY: M.M.
 DATE: CHECKED BY: E.K.

FILE NAME =	DESIGNED - RMG	REVISED -	benesch	STATE OF ILLINOIS DEPARTMENT OF TRANSPORTATION	EXISTING LIGHTING PLANS			F.A.I. RTE.	SECTION	COUNTY	TOTAL SHEETS	SHEET NO.
USER NAME =	DRAWN - RMG	REVISED -			94	1010.1-1-2	COOK	37	11			
PLOT DATE = 03/22/2010	CHECKED - KJN	REVISED -			CONTRACT NO. 60J30							
DATE - 3/19/10	REVISED -	REVISED -	SCALE: N.T.S.		SHEET NO. 3 OF 4 SHEETS		STA.	TO STA.		FED. ROAD DIST. NO. ILLINOIS FED. AID PROJECT		