

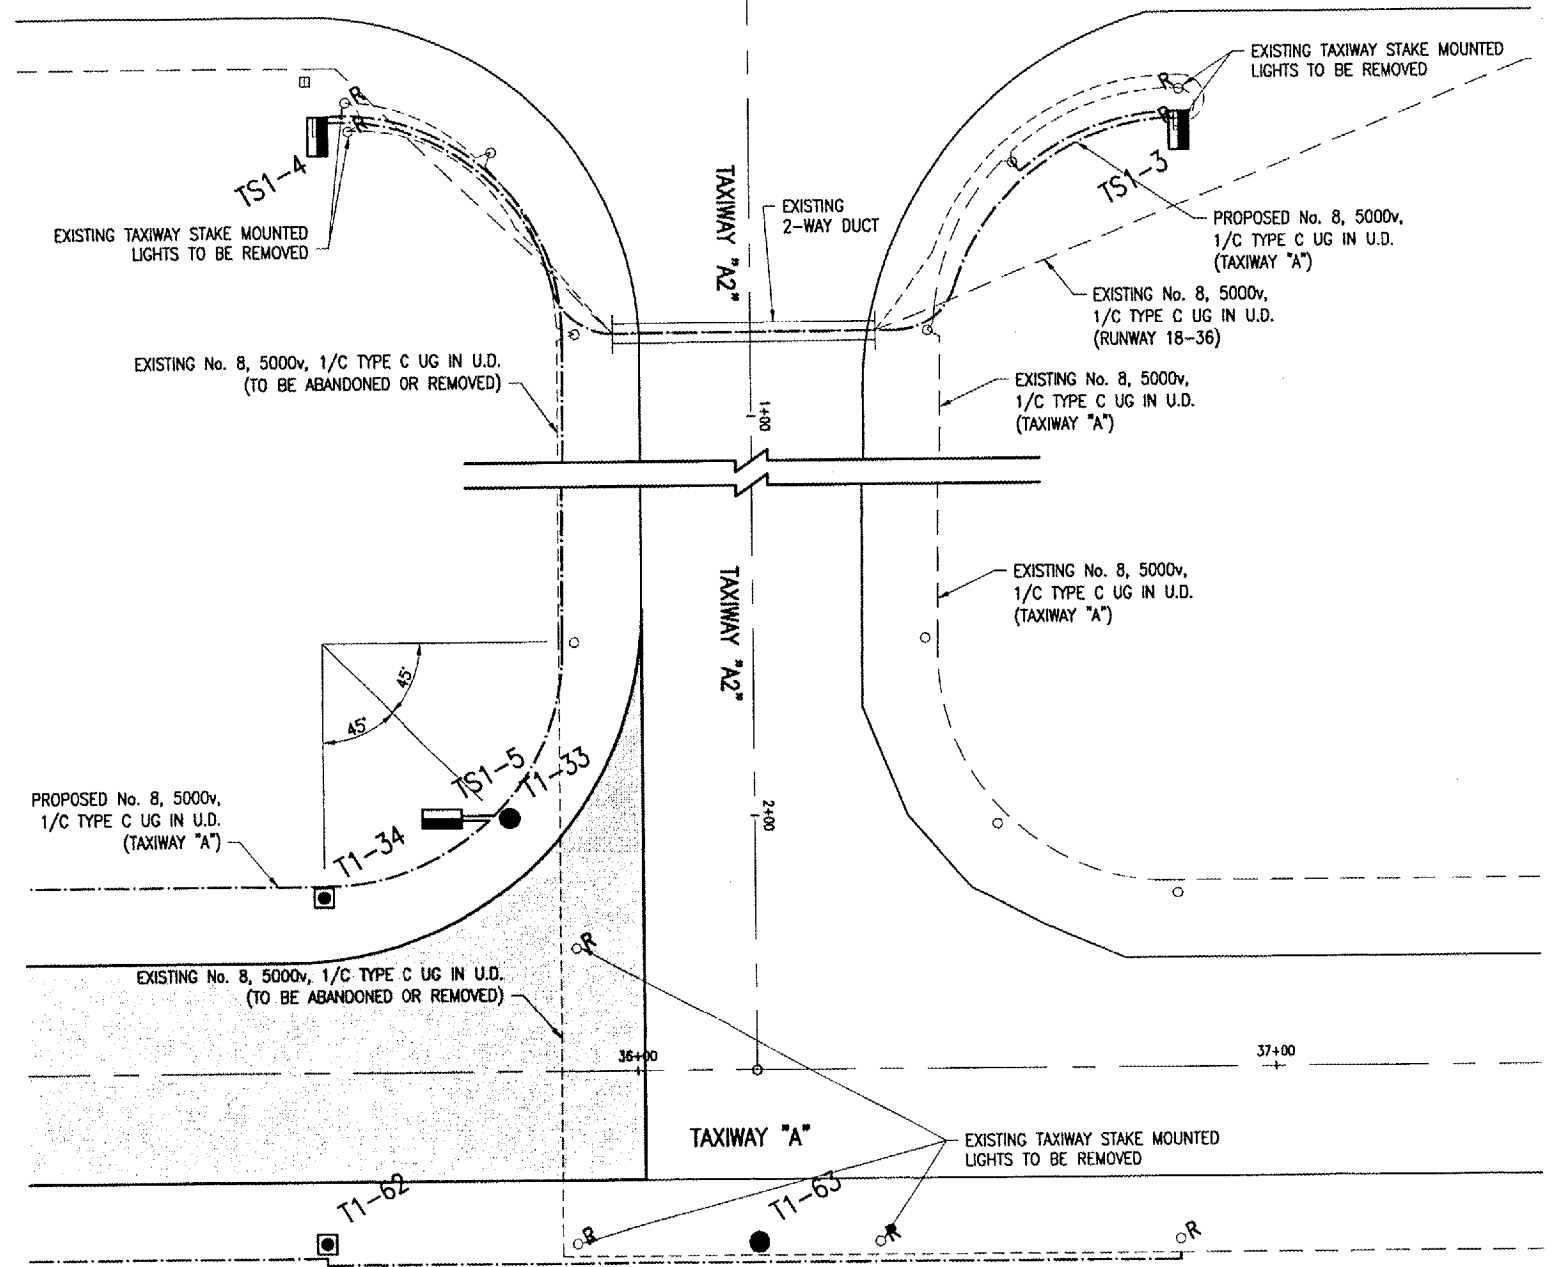


APR 27 2007 7:43 AM BAK
 C:\AIRPORTS\CARM\601-071XX\AIRPORT\SHEETS\R-141ELE.DWG - STA. 54+50 TO STA. 57+50

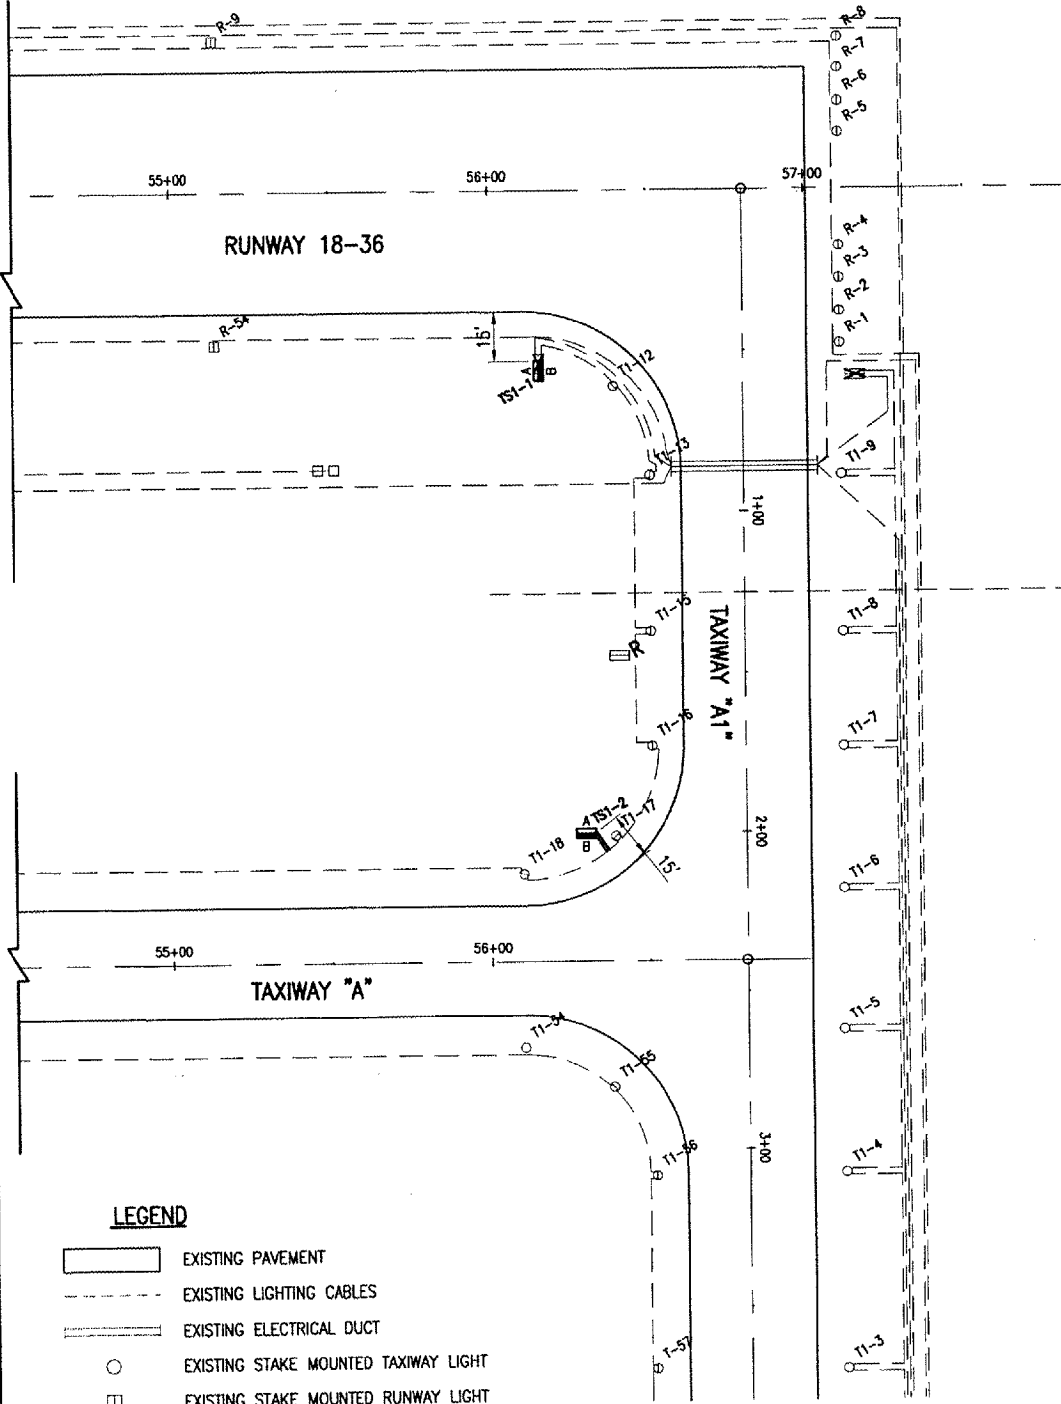

ENLARGED DETAIL OF TAXIWAY "A2" INTERSECTIONS
 NOT TO SCALE

- LEGEND**
- EXISTING PAVEMENT
 - EXISTING LIGHTING CABLES
 - EXISTING ELECTRICAL DUCT
 - EXISTING STAKE MOUNTED TAXIWAY LIGHT
 - EXISTING STAKE MOUNTED RUNWAY LIGHT
 - EXISTING VASI
 - EXISTING THRESHOLD LIGHTS
 - PROPOSED PAVEMENT
 - PROPOSED 1/C #8 5KV FAA L-824 CABLE IN UD
 - PROPOSED STAKE MOUNTED TAXIWAY LIGHT
 - PROPOSED TAXIWAY GUIDANCE SIGN
 - EXISTING LIGHTING CABLES (TO BE ABANDONED OR REMOVED)
 - EXISTING TAXIWAY GUIDANCE SIGN (TO BE RELOCATED)
 - EXISTING TAXIWAY GUIDANCE SIGN (TO BE REMOVED)
 - EXISTING LIGHT (TO BE REMOVED)

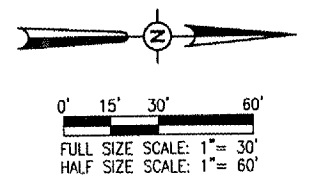

DATE	REVISION	BY

**CARM MUNICIPAL AIRPORT
 CARM, ILLINOIS**

IL PROJ.: CUL-3663 A.I.P. PROJ.: 3-17-0109-87

HEL Project No. 801-07TXD 0800
 Filename: R-141ELE.DWG
 Scale: 1" = 30'
 Date: 11/15/06

LAYOUT	SEP 11/15/06
DRAWN	CCC
REVIEWED	CAH

HANSON
 Hanson Professional Services Inc.
 1528 South Sixth Street
 Springfield, Illinois 62703-2886
 Offices Nationwide

EXTEND PARTIAL
 PARALLEL TAXIWAY

PROPOSED
 ELECTRICAL PLAN
 STA. 54+50 TO STA. 57+50