





 

 
 





APR 01, 2008 11:50 AM V00R00805
 I:\AIRPORTS\KEWANEE\810-06V\TD\ELECTRICAL\SHEETS\R-142ELE.DWG -- STA. 12+00 TO STA. 20+00

KE008

LEGEND

-  EXISTING PAVEMENT
-  EXISTING ELECTRICAL CABLES
-  EXISTING ELECTRICAL DUCT
-  PROPOSED IMPROVEMENTS
-  PROPOSED ELECTRICAL DUCT
-  PROPOSED 1/C NO. 8, 5KV, U.G. CABLE IN U.D.
-  DM EXISTING DUCT MARKERS
-  CM EXISTING CABLE MARKERS
-  EXISTING STAKE MOUNTED RUNWAY LIGHT
-  EXISTING BASE MOUNTED RUNWAY LIGHT
-  EXISTING STAKE MOUNTED TAXIWAY LIGHT
-  EXISTING BASE MOUNTED TAXIWAY LIGHT

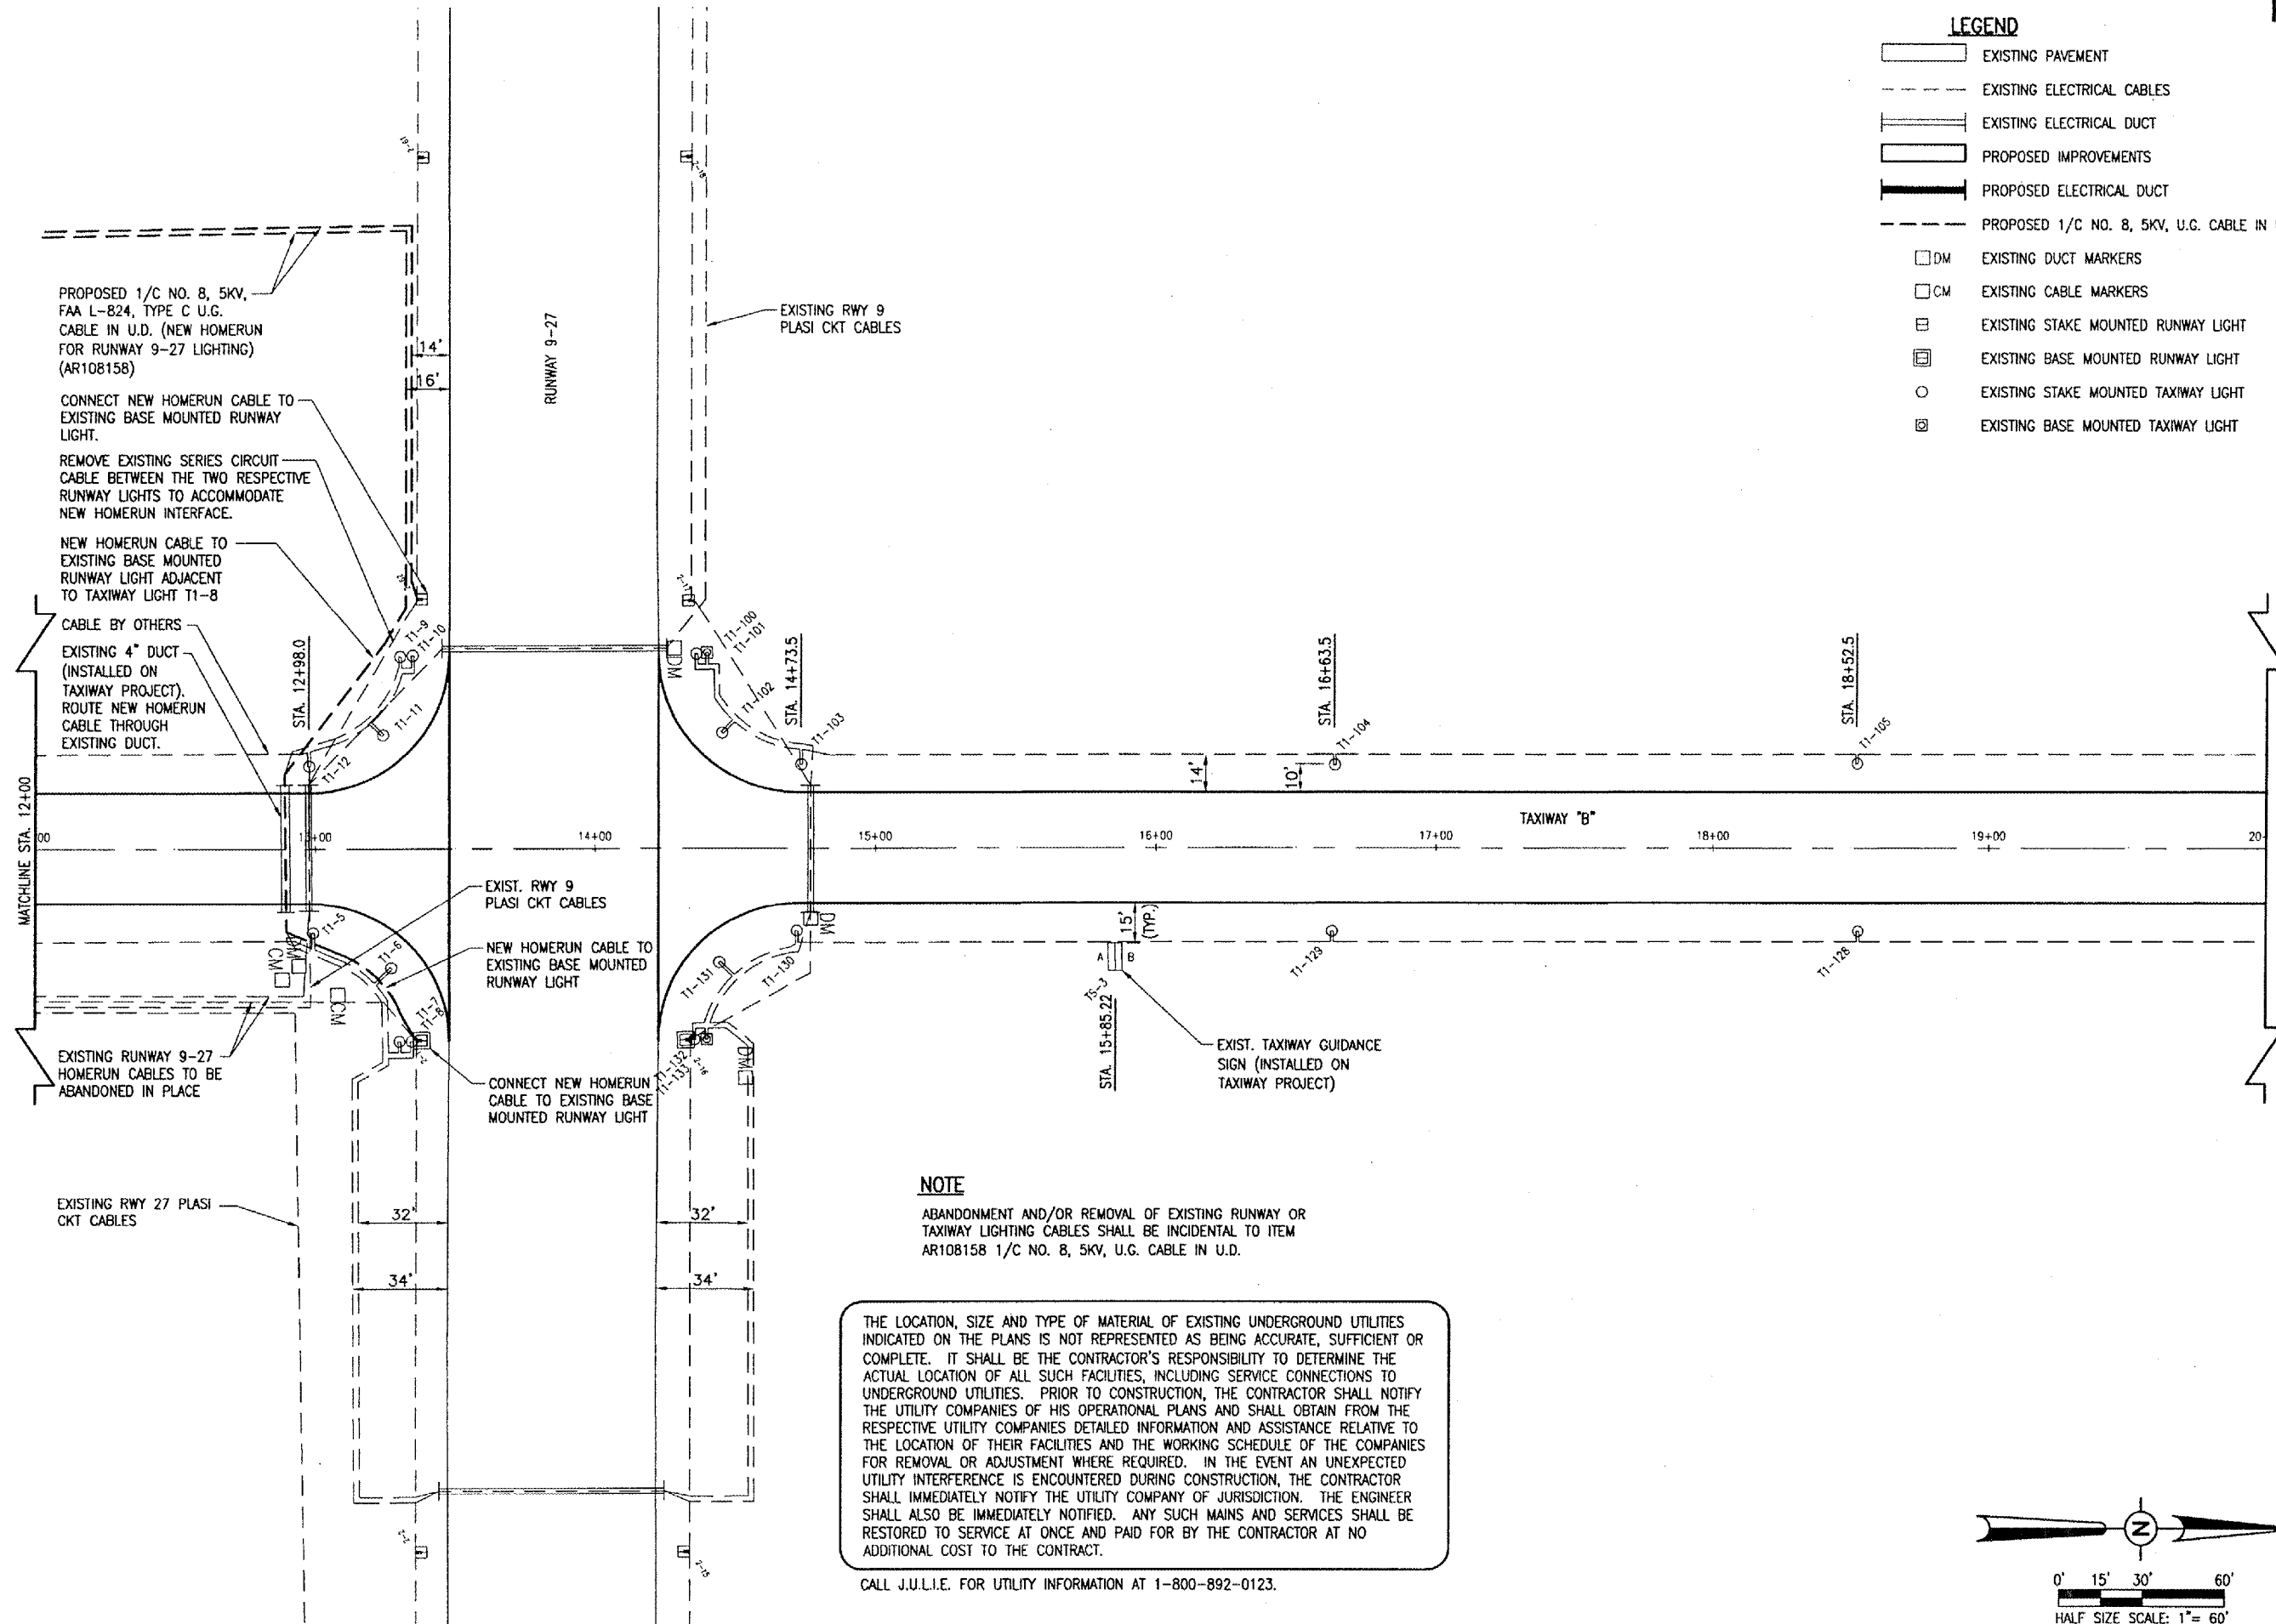


NOTE

ABANDONMENT AND/OR REMOVAL OF EXISTING RUNWAY OR TAXIWAY LIGHTING CABLES SHALL BE INCIDENTAL TO ITEM AR108158 1/C NO. 8, 5KV, U.G. CABLE IN U.D.

THE LOCATION, SIZE AND TYPE OF MATERIAL OF EXISTING UNDERGROUND UTILITIES INDICATED ON THE PLANS IS NOT REPRESENTED AS BEING ACCURATE, SUFFICIENT OR COMPLETE. IT SHALL BE THE CONTRACTOR'S RESPONSIBILITY TO DETERMINE THE ACTUAL LOCATION OF ALL SUCH FACILITIES, INCLUDING SERVICE CONNECTIONS TO UNDERGROUND UTILITIES. PRIOR TO CONSTRUCTION, THE CONTRACTOR SHALL NOTIFY THE UTILITY COMPANIES OF HIS OPERATIONAL PLANS AND SHALL OBTAIN FROM THE RESPECTIVE UTILITY COMPANIES DETAILED INFORMATION AND ASSISTANCE RELATIVE TO THE LOCATION OF THEIR FACILITIES AND THE WORKING SCHEDULE OF THE COMPANIES FOR REMOVAL OR ADJUSTMENT WHERE REQUIRED. IN THE EVENT AN UNEXPECTED UTILITY INTERFERENCE IS ENCOUNTERED DURING CONSTRUCTION, THE CONTRACTOR SHALL IMMEDIATELY NOTIFY THE UTILITY COMPANY OF JURISDICTION. THE ENGINEER SHALL ALSO BE IMMEDIATELY NOTIFIED. ANY SUCH MAINS AND SERVICES SHALL BE RESTORED TO SERVICE AT ONCE AND PAID FOR BY THE CONTRACTOR AT NO ADDITIONAL COST TO THE CONTRACT.

CALL J.U.L.I.E. FOR UTILITY INFORMATION AT 1-800-892-0123.

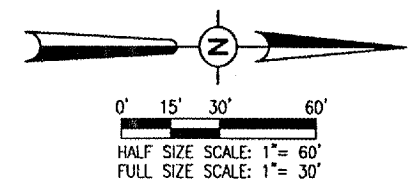

DATE	REVISION	BY

KEWANEE MUNICIPAL AIRPORT
 KEWANEE, HENRY COUNTY, ILLINOIS
 I.L. PROJ.: E21-3586 A.I.P. PROJ.: 3-17-0058-B12

FILE PROJECT NO.	810-06V\TD
FILENAME	R-142ELE.DWG
SCALE	1"=30'
DATE	04/01/08
LAYOUT	08/02/05
DRAWN	B.A.K.
REVIEWED	C.A.H.
DATE	04/27/06



CONSTRUCT VAULT
 PROPOSED ELECTRICAL PLAN
 STA. 12+00 TO STA. 20+00