



END IMPROVEMENT CONTRACT 60R30 STA. 3982+08	BEGIN WORK CONTRACT 60R31 STA. 3982+08
---	--

END IMPROVEMENT CONTRACT 60R30 STA. 3982+08	BEGIN WORK CONTRACT 60R31 STA. 3982+08
---	--

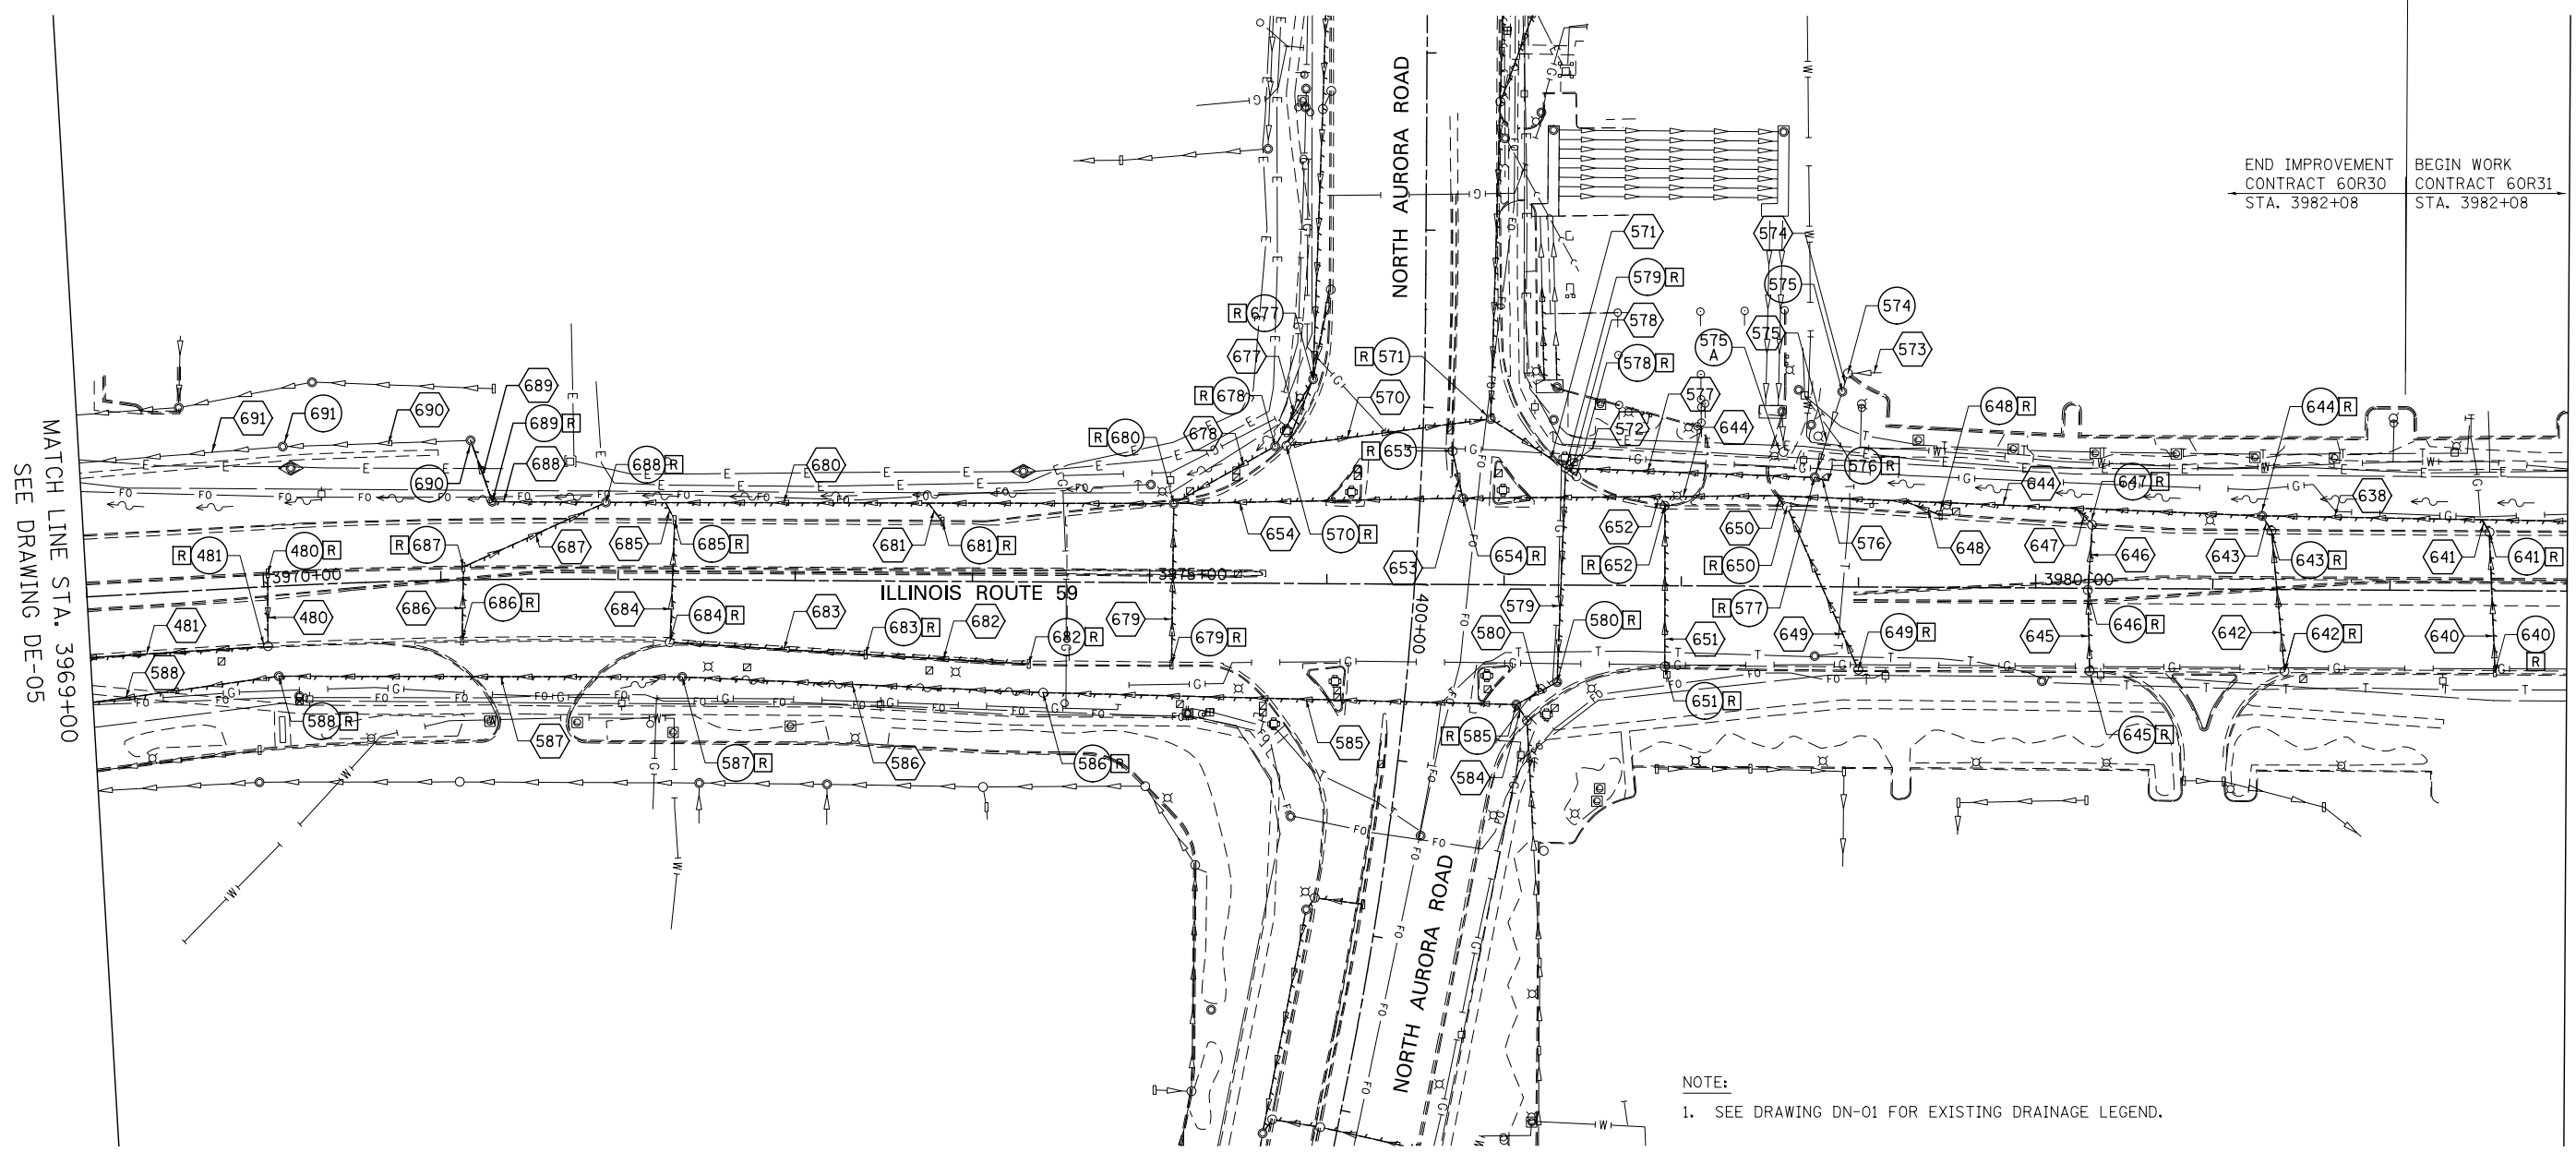

MATCH LINE STA. 3969+00
SEE DRAWING DE-05

NOTE:
1. SEE DRAWING DN-01 FOR EXISTING DRAINAGE LEGEND.

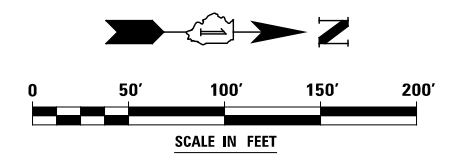

DESIGNED <i>PJO</i> DRAWN <i>KES</i> CHECKED <i>JCM</i> DATE <i>12/14/2012</i>	REVISED -	STATE OF ILLINOIS DEPARTMENT OF TRANSPORTATION	EXISTING DRAINAGE PLAN - ILLINOIS ROUTE 59		F.A.P. RTE.	SECTION	COUNTY	TOTAL SHEETS	SHEET NO.	
	REVISED -		SCALE: AS SHOWN	SHEET NO. 6 OF 15 SHEETS	STA. 3969+00 TO STA. END	338	(112 & 113) WRS-7	DUPAGE	1156	457
	REVISED -					DE-06		CONTRACT NO. 60R30		
	REVISED -					ILLINOIS FED. AID PROJECT				