 

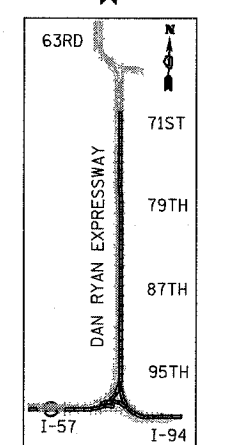
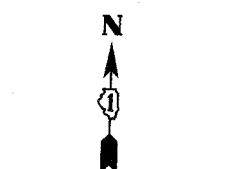
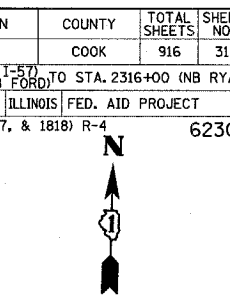
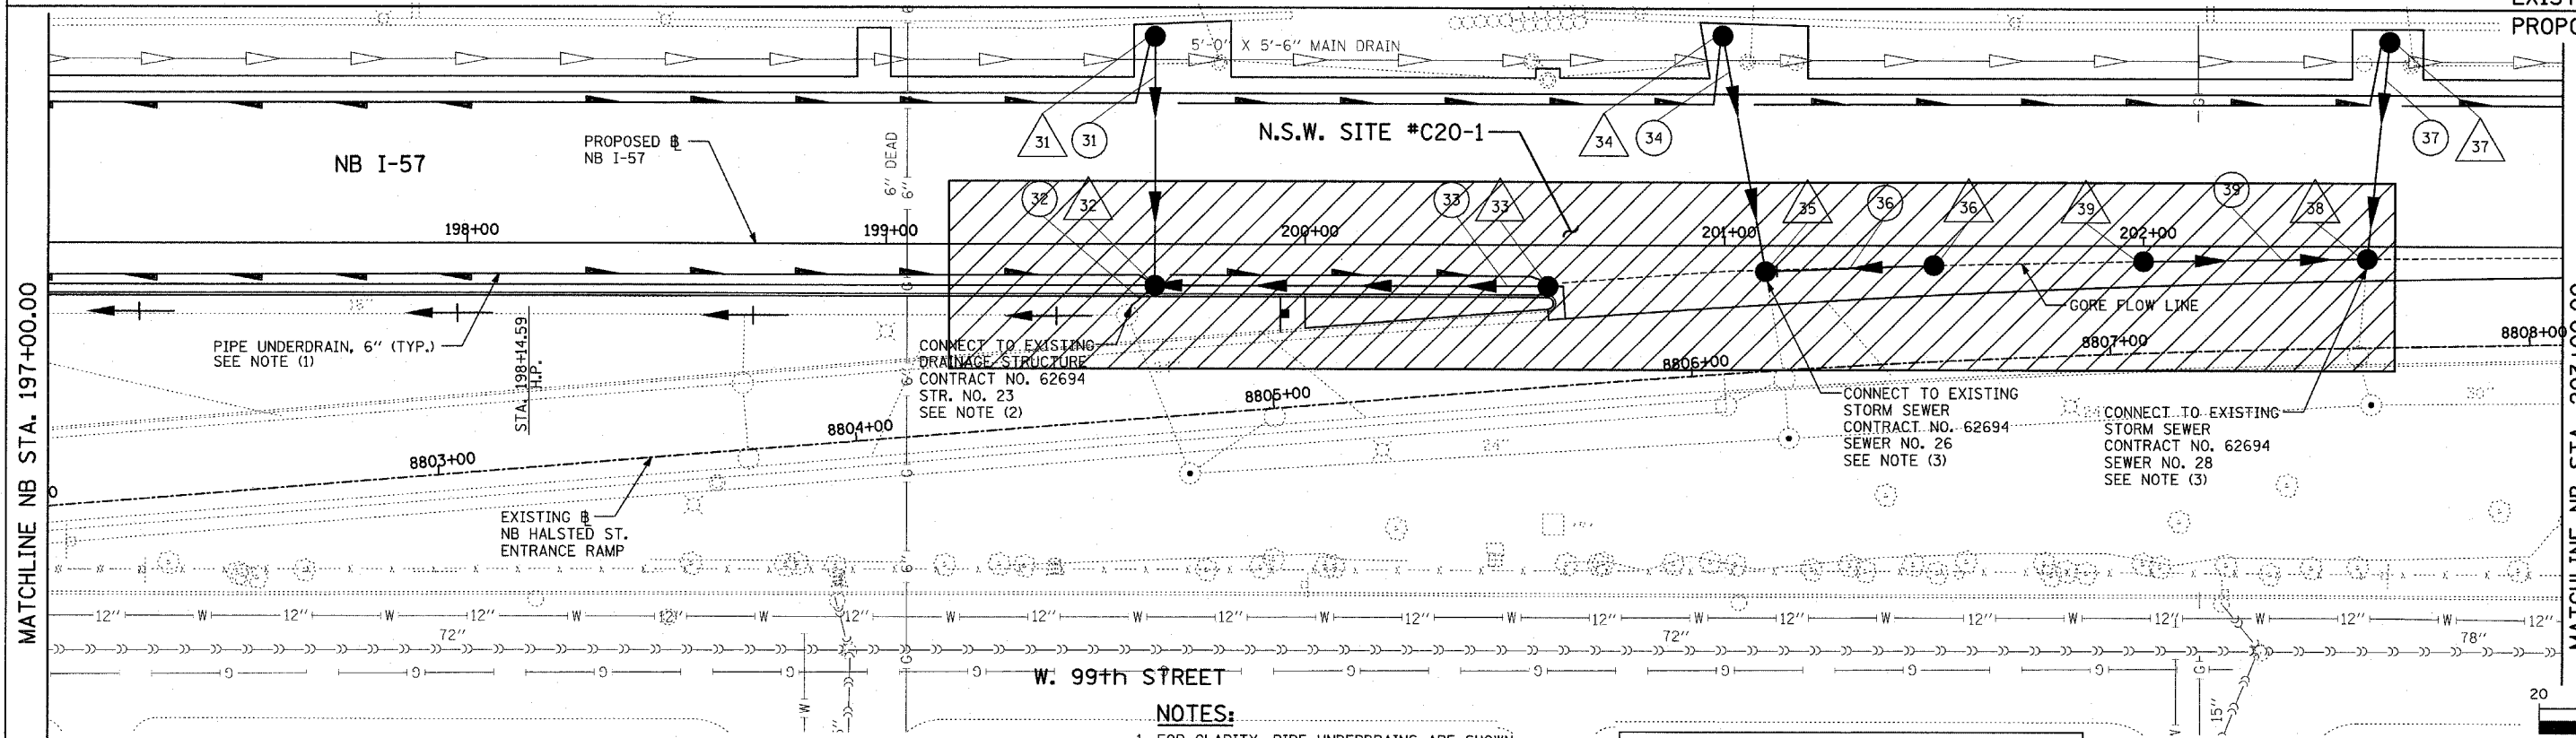


F.A.I. RTE. 94	SECTION	COUNTY COOK	TOTAL SHEETS 916	SHEET NO. 314
STA. 197+00 (NB I-57)				TO STA. 2316+00 (NB RYAN)
FED. ROAD DIST. NO. ILLINOIS			FED. AID PROJECT	62304
• (1516.1, 1717, & 1818) R-4				

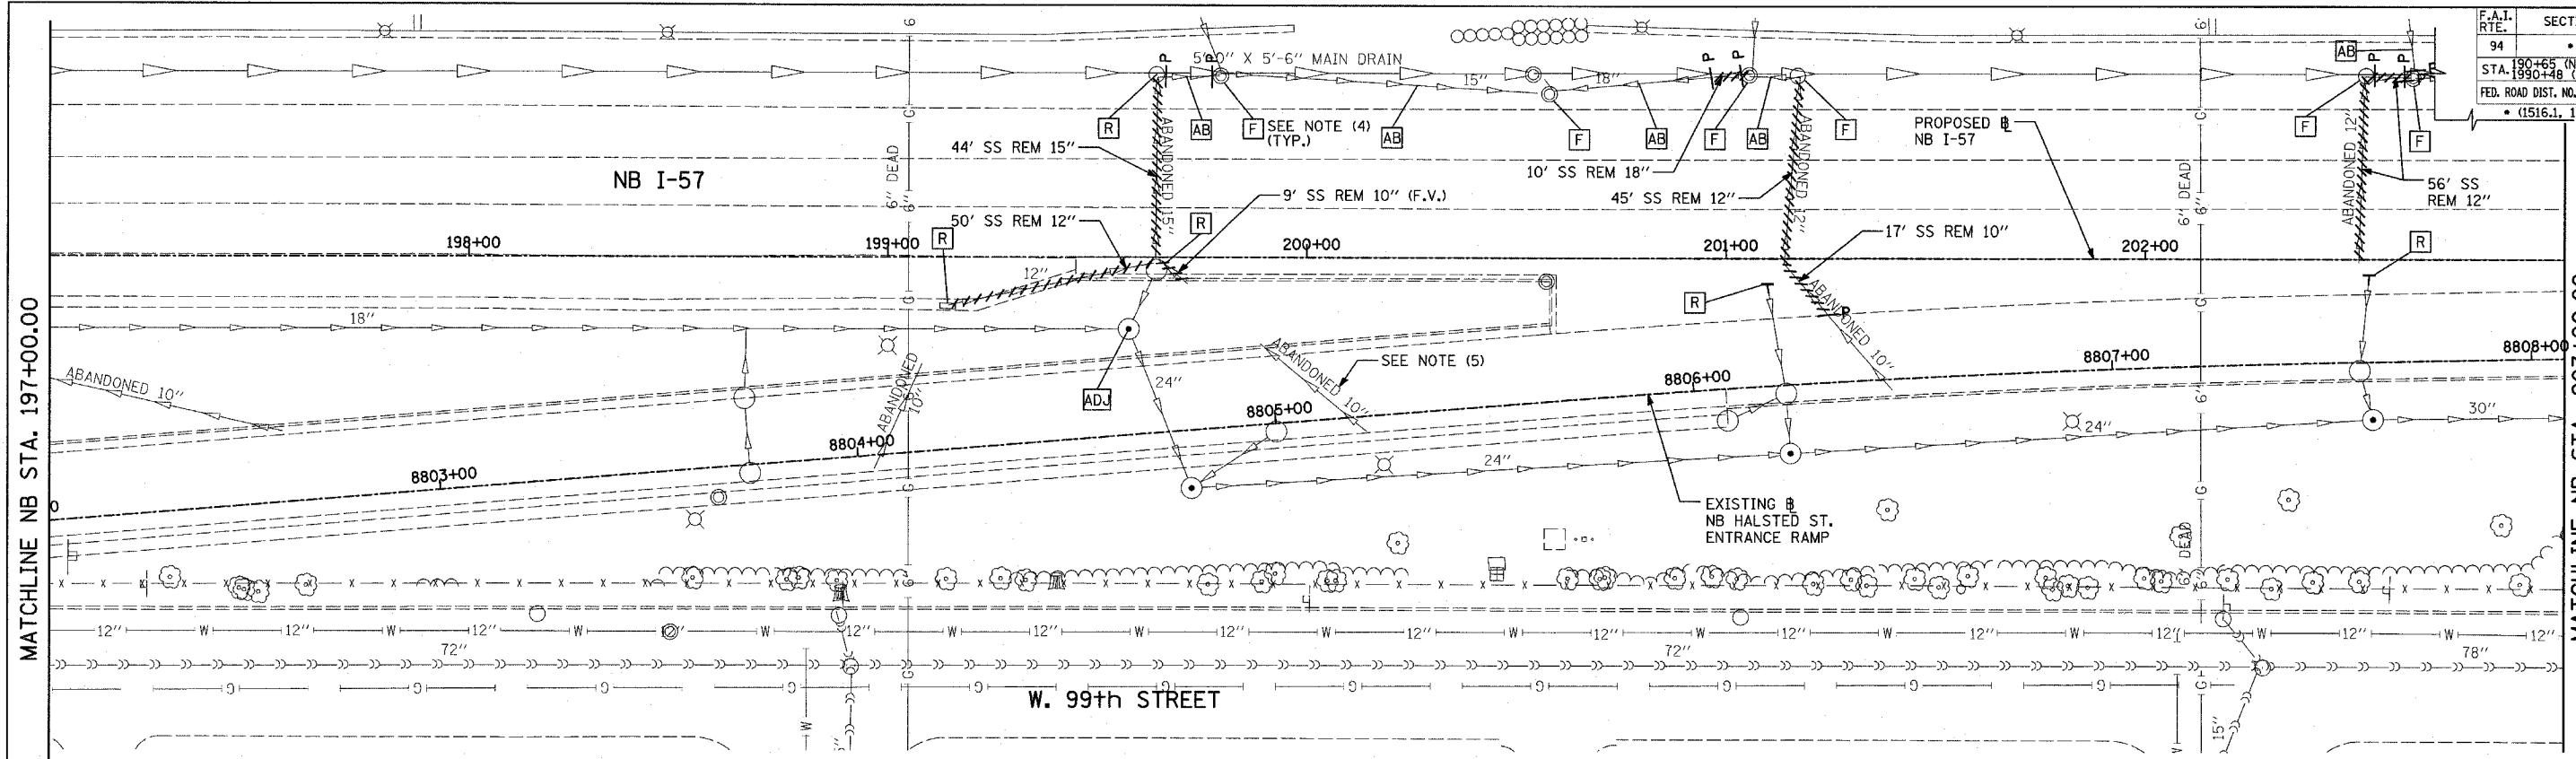

MATCHLINE NB STA. 197+00.00

MATCHLINE NB STA. 203+00.00

MATCHLINE NB STA. 197+00.00

MATCHLINE NB STA. 203+00.00

TYLIN INTERNATIONAL

LEGEND:

	EXISTING COMBINED SEWER		SEWER PLUG
	PROPOSED STORM SEWER NUMBER (X=SHEET NO., Y=PIPE NO.)		FIELD VERIFY
	PROPOSED STRUCTURE NUMBER (X=SHEET NO., Y=STRUCTURE NO.)		UTILITY REMOVAL
	PIPE STUBOUT TO BE PLUGGED		PROPOSED CATCH BASIN CONSTRUCTED IN CONCURRENT CONTRACT 62593
			PROPOSED STORM SEWER CONSTRUCTED IN CONCURRENT CONTRACT 62593

- NOTES:**
- FOR CLARITY, PIPE UNDERDRAINS ARE SHOWN OFFSET FROM THEIR PROPOSED LOCATIONS. FOR DETAILED PLACEMENT, SEE SHEET "PIPE UNDERDRAINS DETAIL."
 - CORE DRILL AND CONNECT TO EXISTING DRAINAGE STRUCTURE. CONNECTION COST SHALL BE INCLUDED IN THE COST TO CONSTRUCT THE STORM SEWER.
 - COST SHALL NOT BE PAID FOR SEPARATELY BUT INCLUDED IN COST OF SEWER INSTALLATION.
 - COST TO REMOVE FRAME AND GRATE SHALL BE INCLUDED IN COST TO FILL DRAINAGE STRUCTURE.

5. SEWERS DENOTED AS SUCH WERE ABANDONED UNDER A PREVIOUS CONTRACT AND WILL BE REMOVED UNDER CURRENT CONTRACT.

NSW - NON SPECIAL WASTE SITES ADDED TO SHEET

REVISIONS	
NAME	DATE

ILLINOIS DEPARTMENT OF TRANSPORTATION
F.A.I. 94 (DAN RYAN EXPRESSWAY)
DRAINAGE AND UTILITY PLAN
NB I-57
NB I-57 STA. 197+00.00 TO 203+00.00