
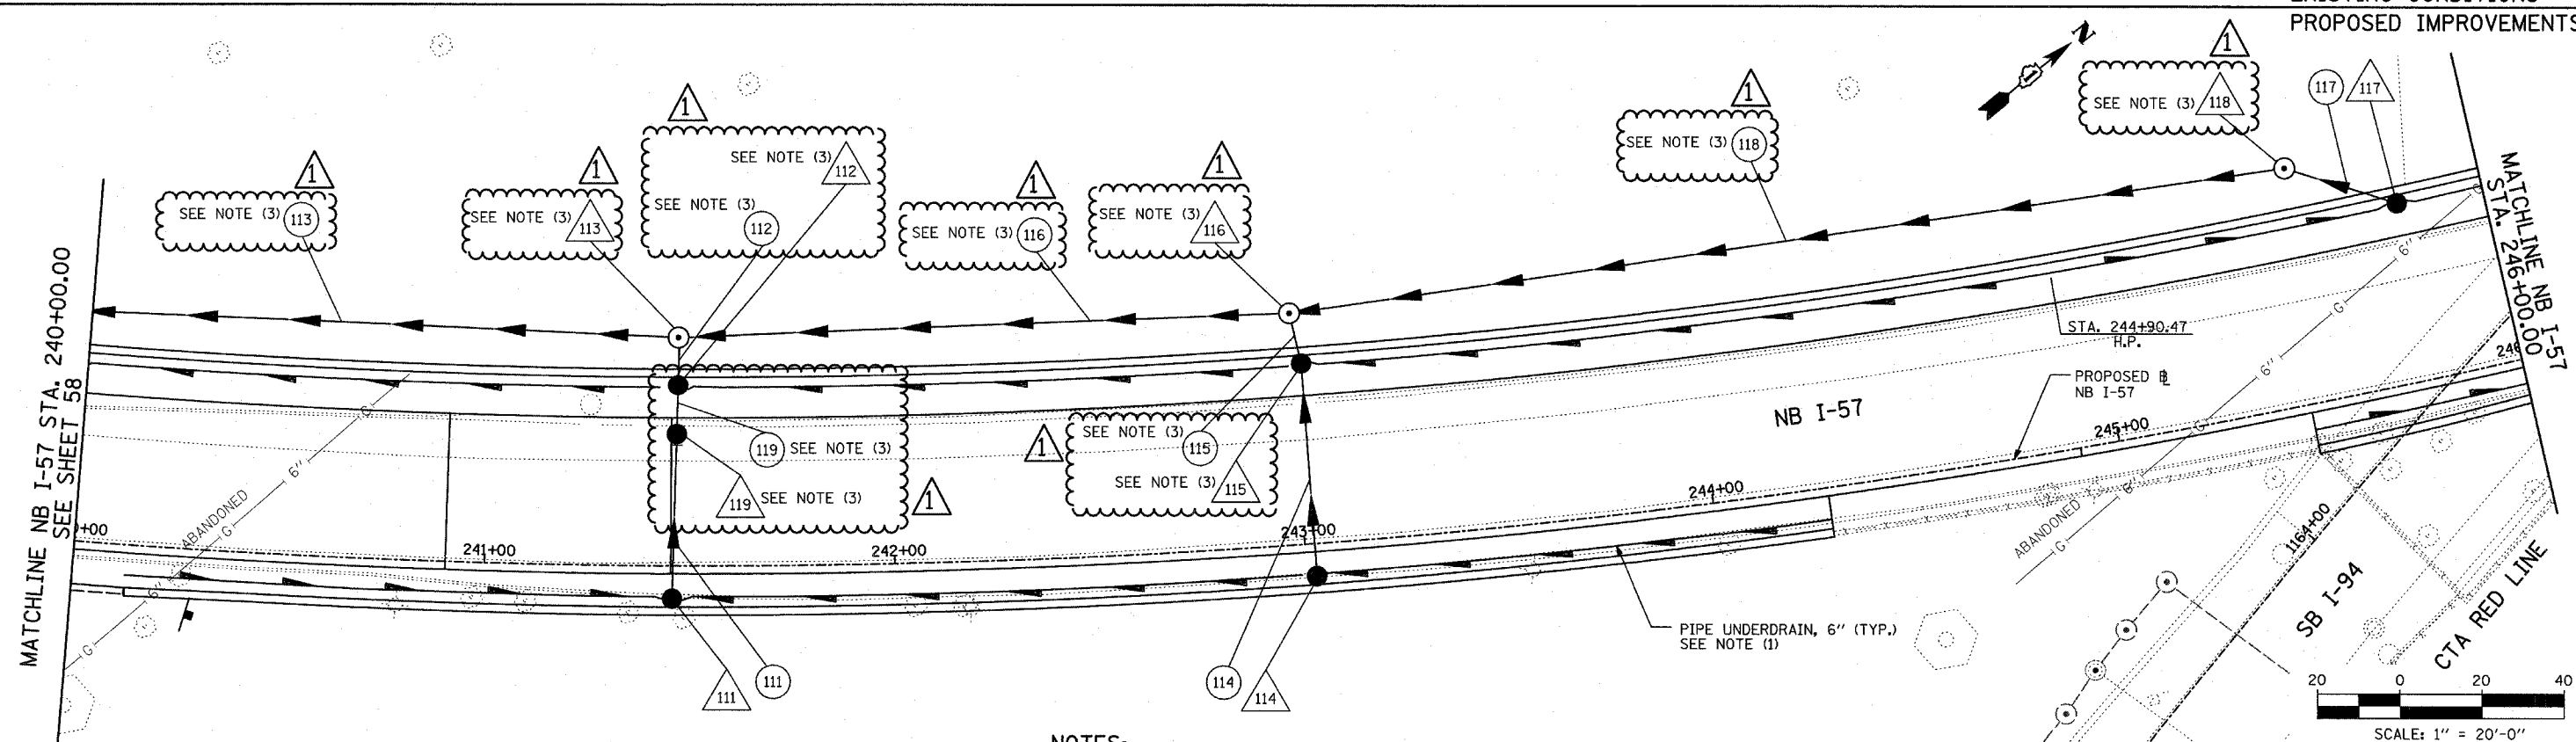


F.A.I. RTE.	SECTION	COUNTY	TOTAL SHEETS	SHEET NO.
94		COOK	916	322
STA. 190+65 (NB I-57) TO STA. 2316+00 (NB RYAN)				
FED. ROAD DIST. NO. ILLINOIS FED. AID PROJECT				
• (1516.1, 1717, & 1818) R-4 62304				

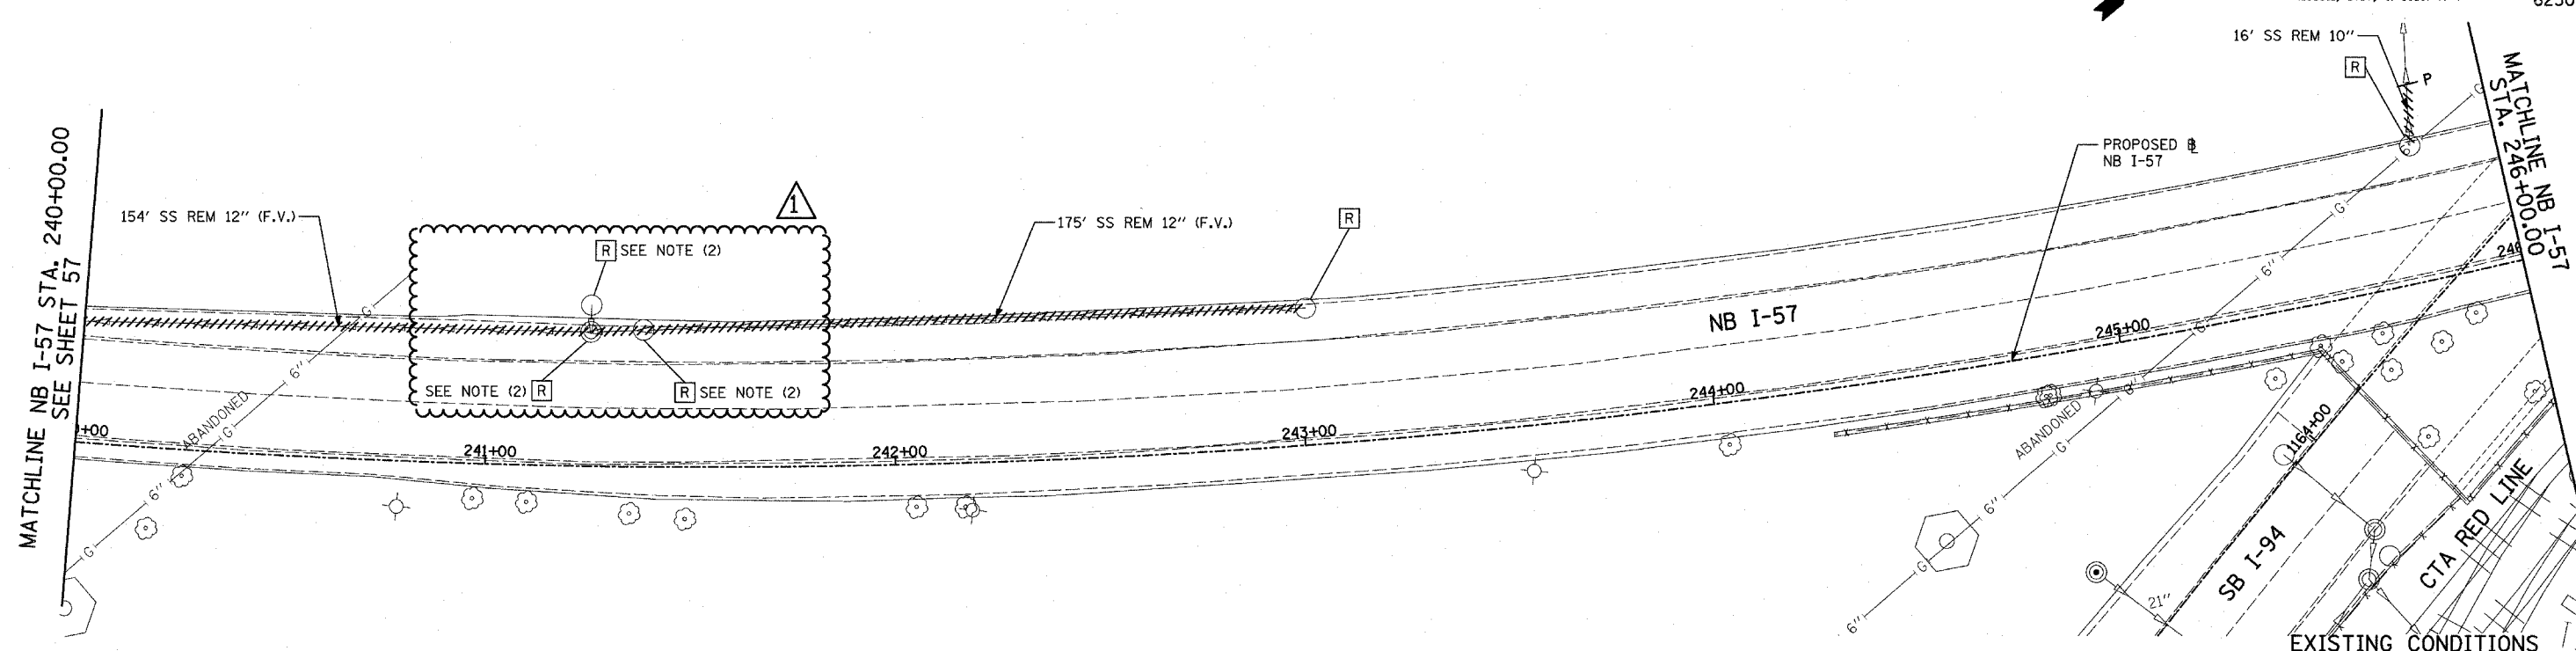


LEGEND:

	EXISTING COMBINED SEWER		SEWER PLUG
	PROPOSED STORM SEWER NUMBER (X=SHEET NO., Y=PIPE NO.)		F.V. FIELD VERIFY
	PROPOSED STRUCTURE NUMBER (X=SHEET NO., Y=STRUCTURE NO.)		UTILITY REMOVAL
	PIPE STUBOUT TO BE PLUGGED		PROPOSED CATCH BASIN CONSTRUCTED IN CONCURRENT CONTRACT 62593
			PROPOSED STORM SEWER CONSTRUCTED IN CONCURRENT CONTRACT 62593

NOTES:

- FOR CLARITY, PIPE UNDERDRAINS ARE SHOWN OFFSET FROM THEIR PROPOSED LOCATIONS. FOR DETAILED PLACEMENT, SEE SHEET "PIPE UNDERDRAINS DETAIL."
- STRUCTURES TO BE ADJUSTED PRIOR TO STAGE 2 OF CONSTRUCTION TO MAINTAIN SURFACE DRAINAGE. THIS COST SHALL BE PAID FOR SEPARATELY AND INCLUDED IN THE SUMMARY OF QUANTITIES.
- REFER TO "CONSTRUCTION STAGING NOTES- MAINTENANCE OF TRAFFIC DETAILS-SHEET 1 OF 13 (SHEET #187)."

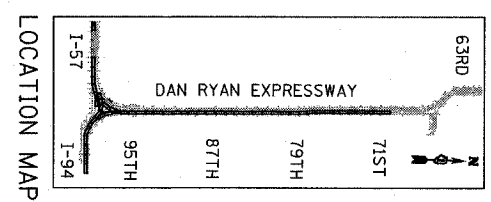

SHEET 11 OF 59

REVISIONS	
NAME	DATE

ADDENDUM 1 05/08/06

ILLINOIS DEPARTMENT OF TRANSPORTATION
 F.A.I. 94 (DAN RYAN EXPRESSWAY)
DRAINAGE AND UTILITY PLAN
 NB I-57
 NB STA. 240+00.00 TO 246+00.00

SCALE: 1"=20'
 DATE: MARCH 7, 2006
 DRAWN BY: MB
 CHECKED BY: DA

TYLIN INTERNATIONAL