


PLAN @ EL. +9.5

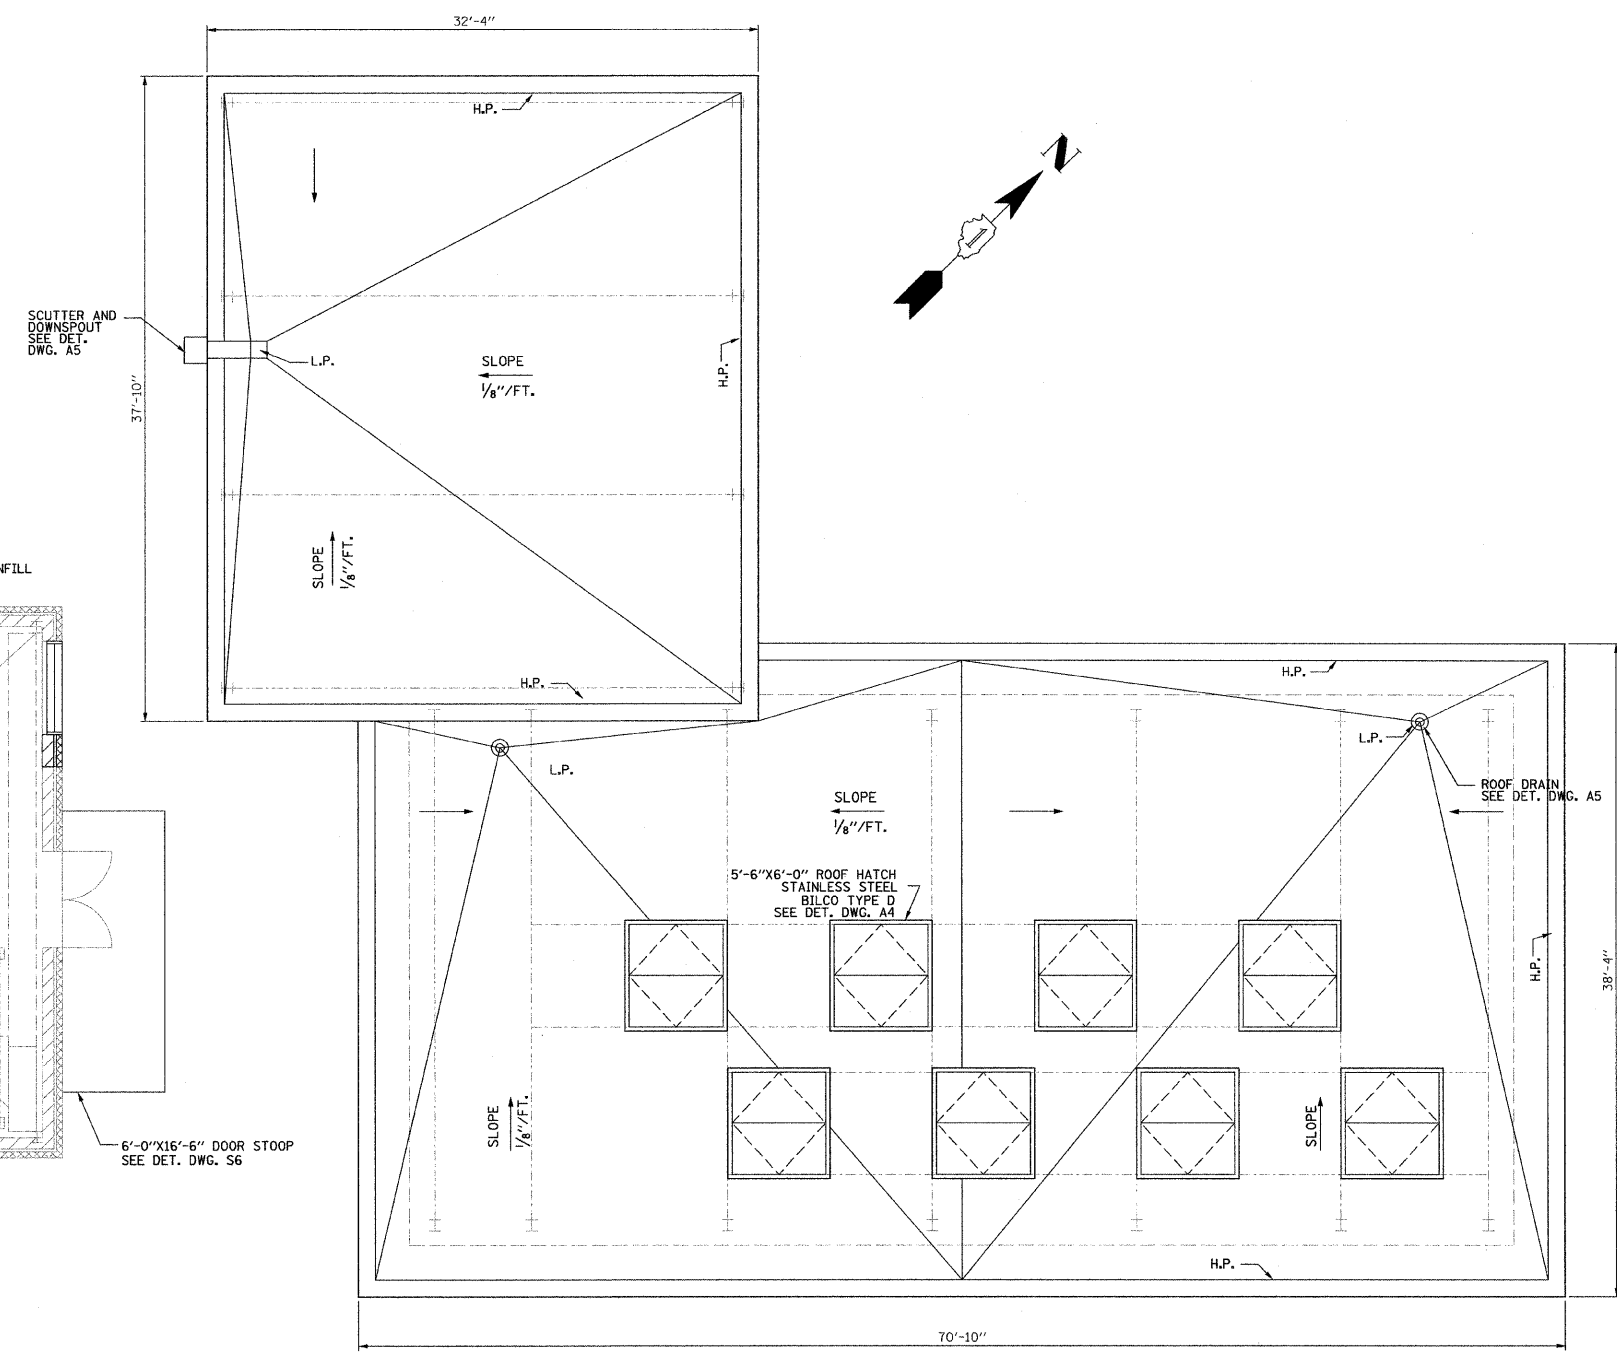

ROOF PLAN



A2

REVISIONS	
NAME	DATE

ILLINOIS DEPARTMENT OF TRANSPORTATION
**PUMP STATION NO. 27
 REHABILITATION**
 ARCHITECTURAL PLANS

SCALE: AS SHOWN
 DATE: 04-23-10

DRAWN BY: CM
 CHECKED BY: PJE