
 


PLAN ABOVE EL. -8.5'

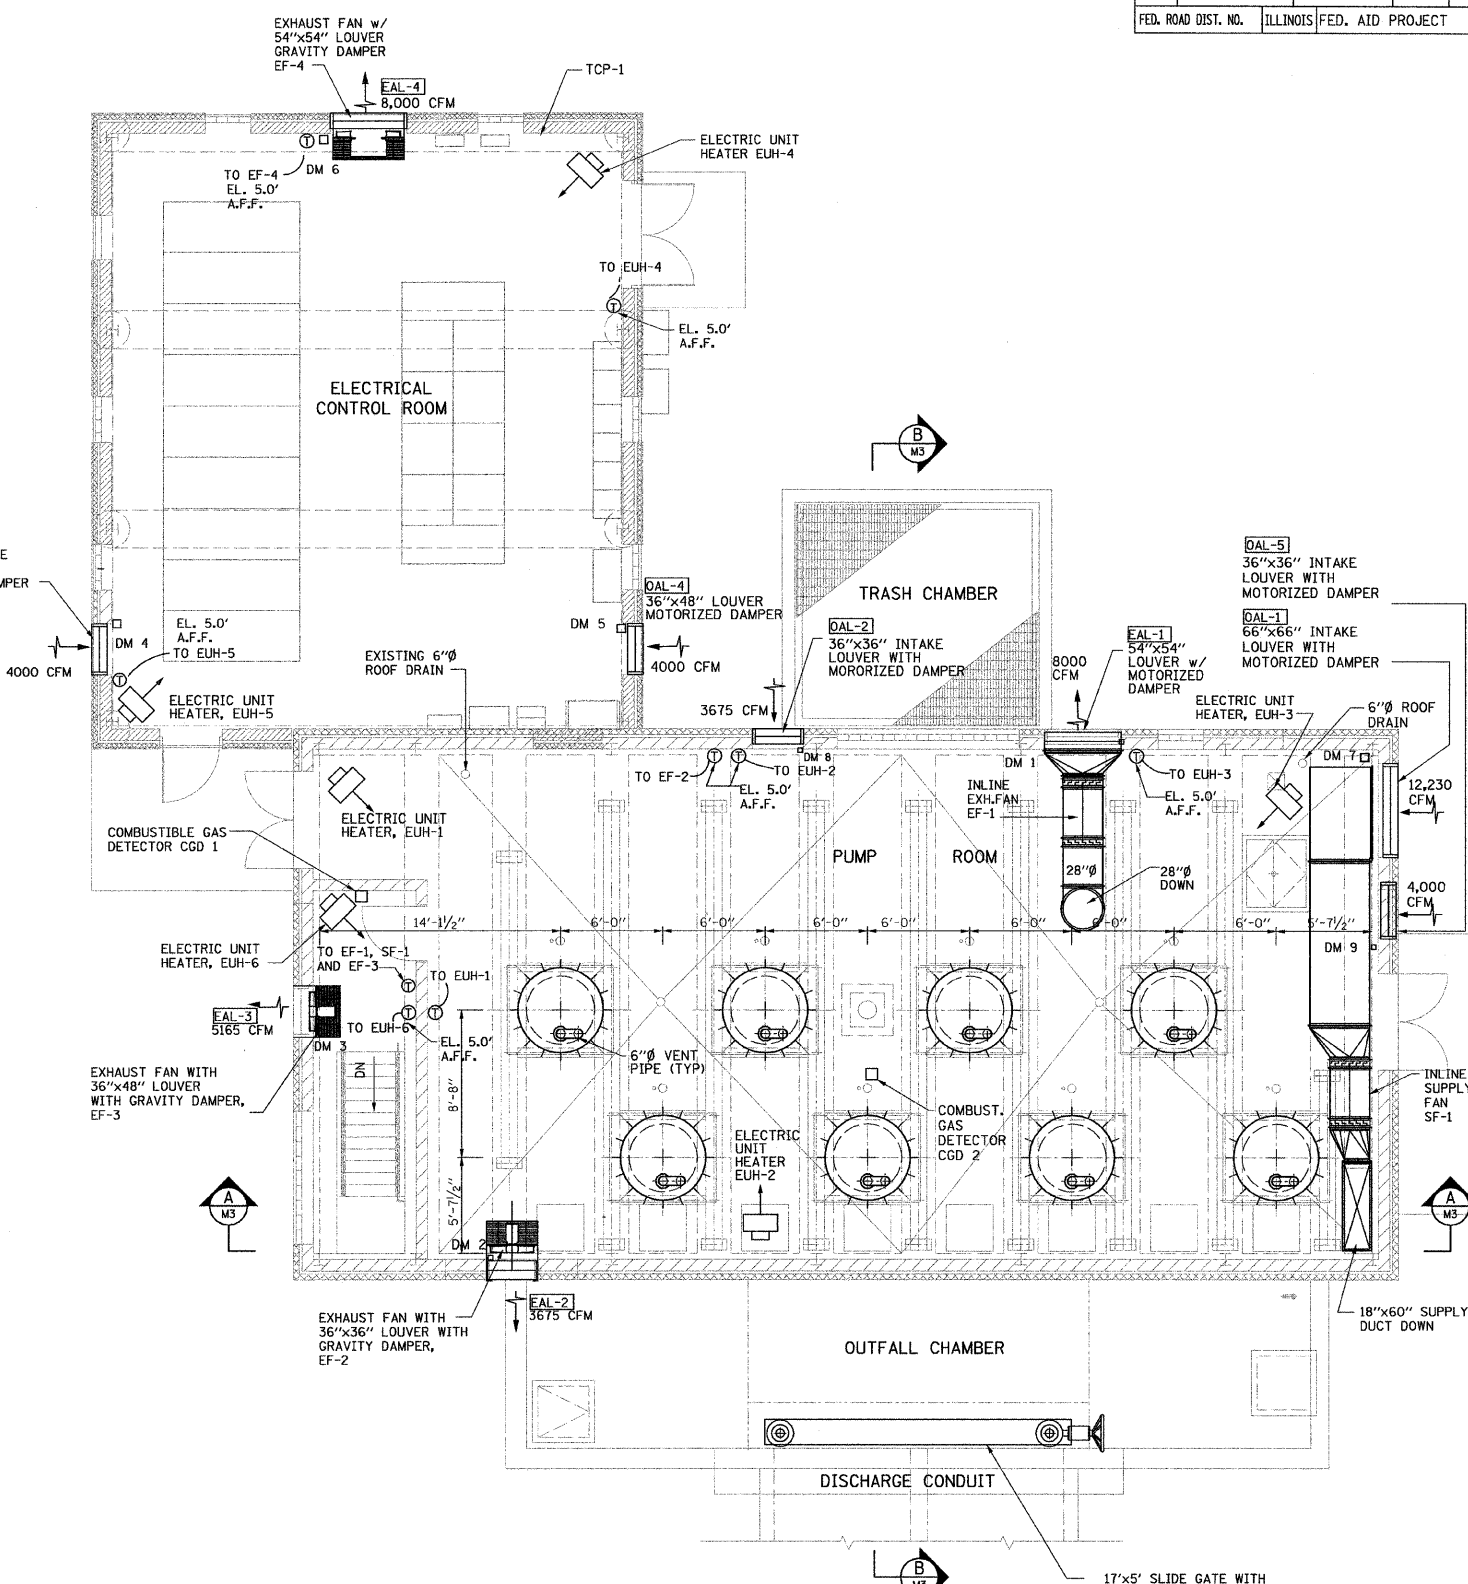

FLOOR PLAN ABOVE EL. +9.5'

- NOTES:
1. ALL ROOM EXCEPT ELECTRICAL CONTROL ROOM SHALL BE CLASS 1, DIVISION 1, GROUP D EXPLOSION PROOF.
 2. PROTECT EXISTING FLOOR DRAIN DURING CONSTRUCTION.
 3. PUMP DOLLY WITH SPARE LOW FLOW PUMP SHALL BE STORED AT THE NORTHEAST CORNER OF PUMP ROOM.
 4. LOUVERS OPENING AND ELEVATIONS SEE DRAWING A1



M1

REVISIONS	
NAME	DATE

ILLINOIS DEPARTMENT OF TRANSPORTATION

**PUMP STATION NO. 27
REHABILITATION**

MECHANICAL PLANS

SCALE: AS SHOWN DRAWN BY: HFF
DATE: 04-23-10 CHECKED BY: KHC

