


NOTES:

1. AT ALL UTILITY PIPELINE CROSSINGS OR AT LOCATIONS DIRECTED BY THE ENGINEER, ALL EARTH EXCAVATION AND ROCK EXCAVATION SHALL BE PERFORMED WITH HAND TOOLS OR OTHER NONDESTRUCTIVE METHODS APPROVED BY THE ENGINEER OR THE PIPELINE OWNER AS OUTLINED IN THE SPECIAL PROVISION, EXISTING PIPELINE COMPANIES REQUIREMENTS.
2. CONSTRUCTION EQUIPMENT, INCLUDING PICK-UP TRUCKS, WILL NOT BE ALLOWED TO CROSS ANY PIPELINE UNTIL APPROVAL IS RECEIVED FROM THE PIPELINE OWNER.
3. IN THE VICINITY OF ANY UTILITY CROSSINGS, DETERMINING THE LOCATION OF THE UTILITY SHALL BE PAID FOR AS "EXPLORATION TRENCH, SPECIAL" TO AN ELEVATION OF 635.00 OR AS DIRECTED BY THE ENGINEER.

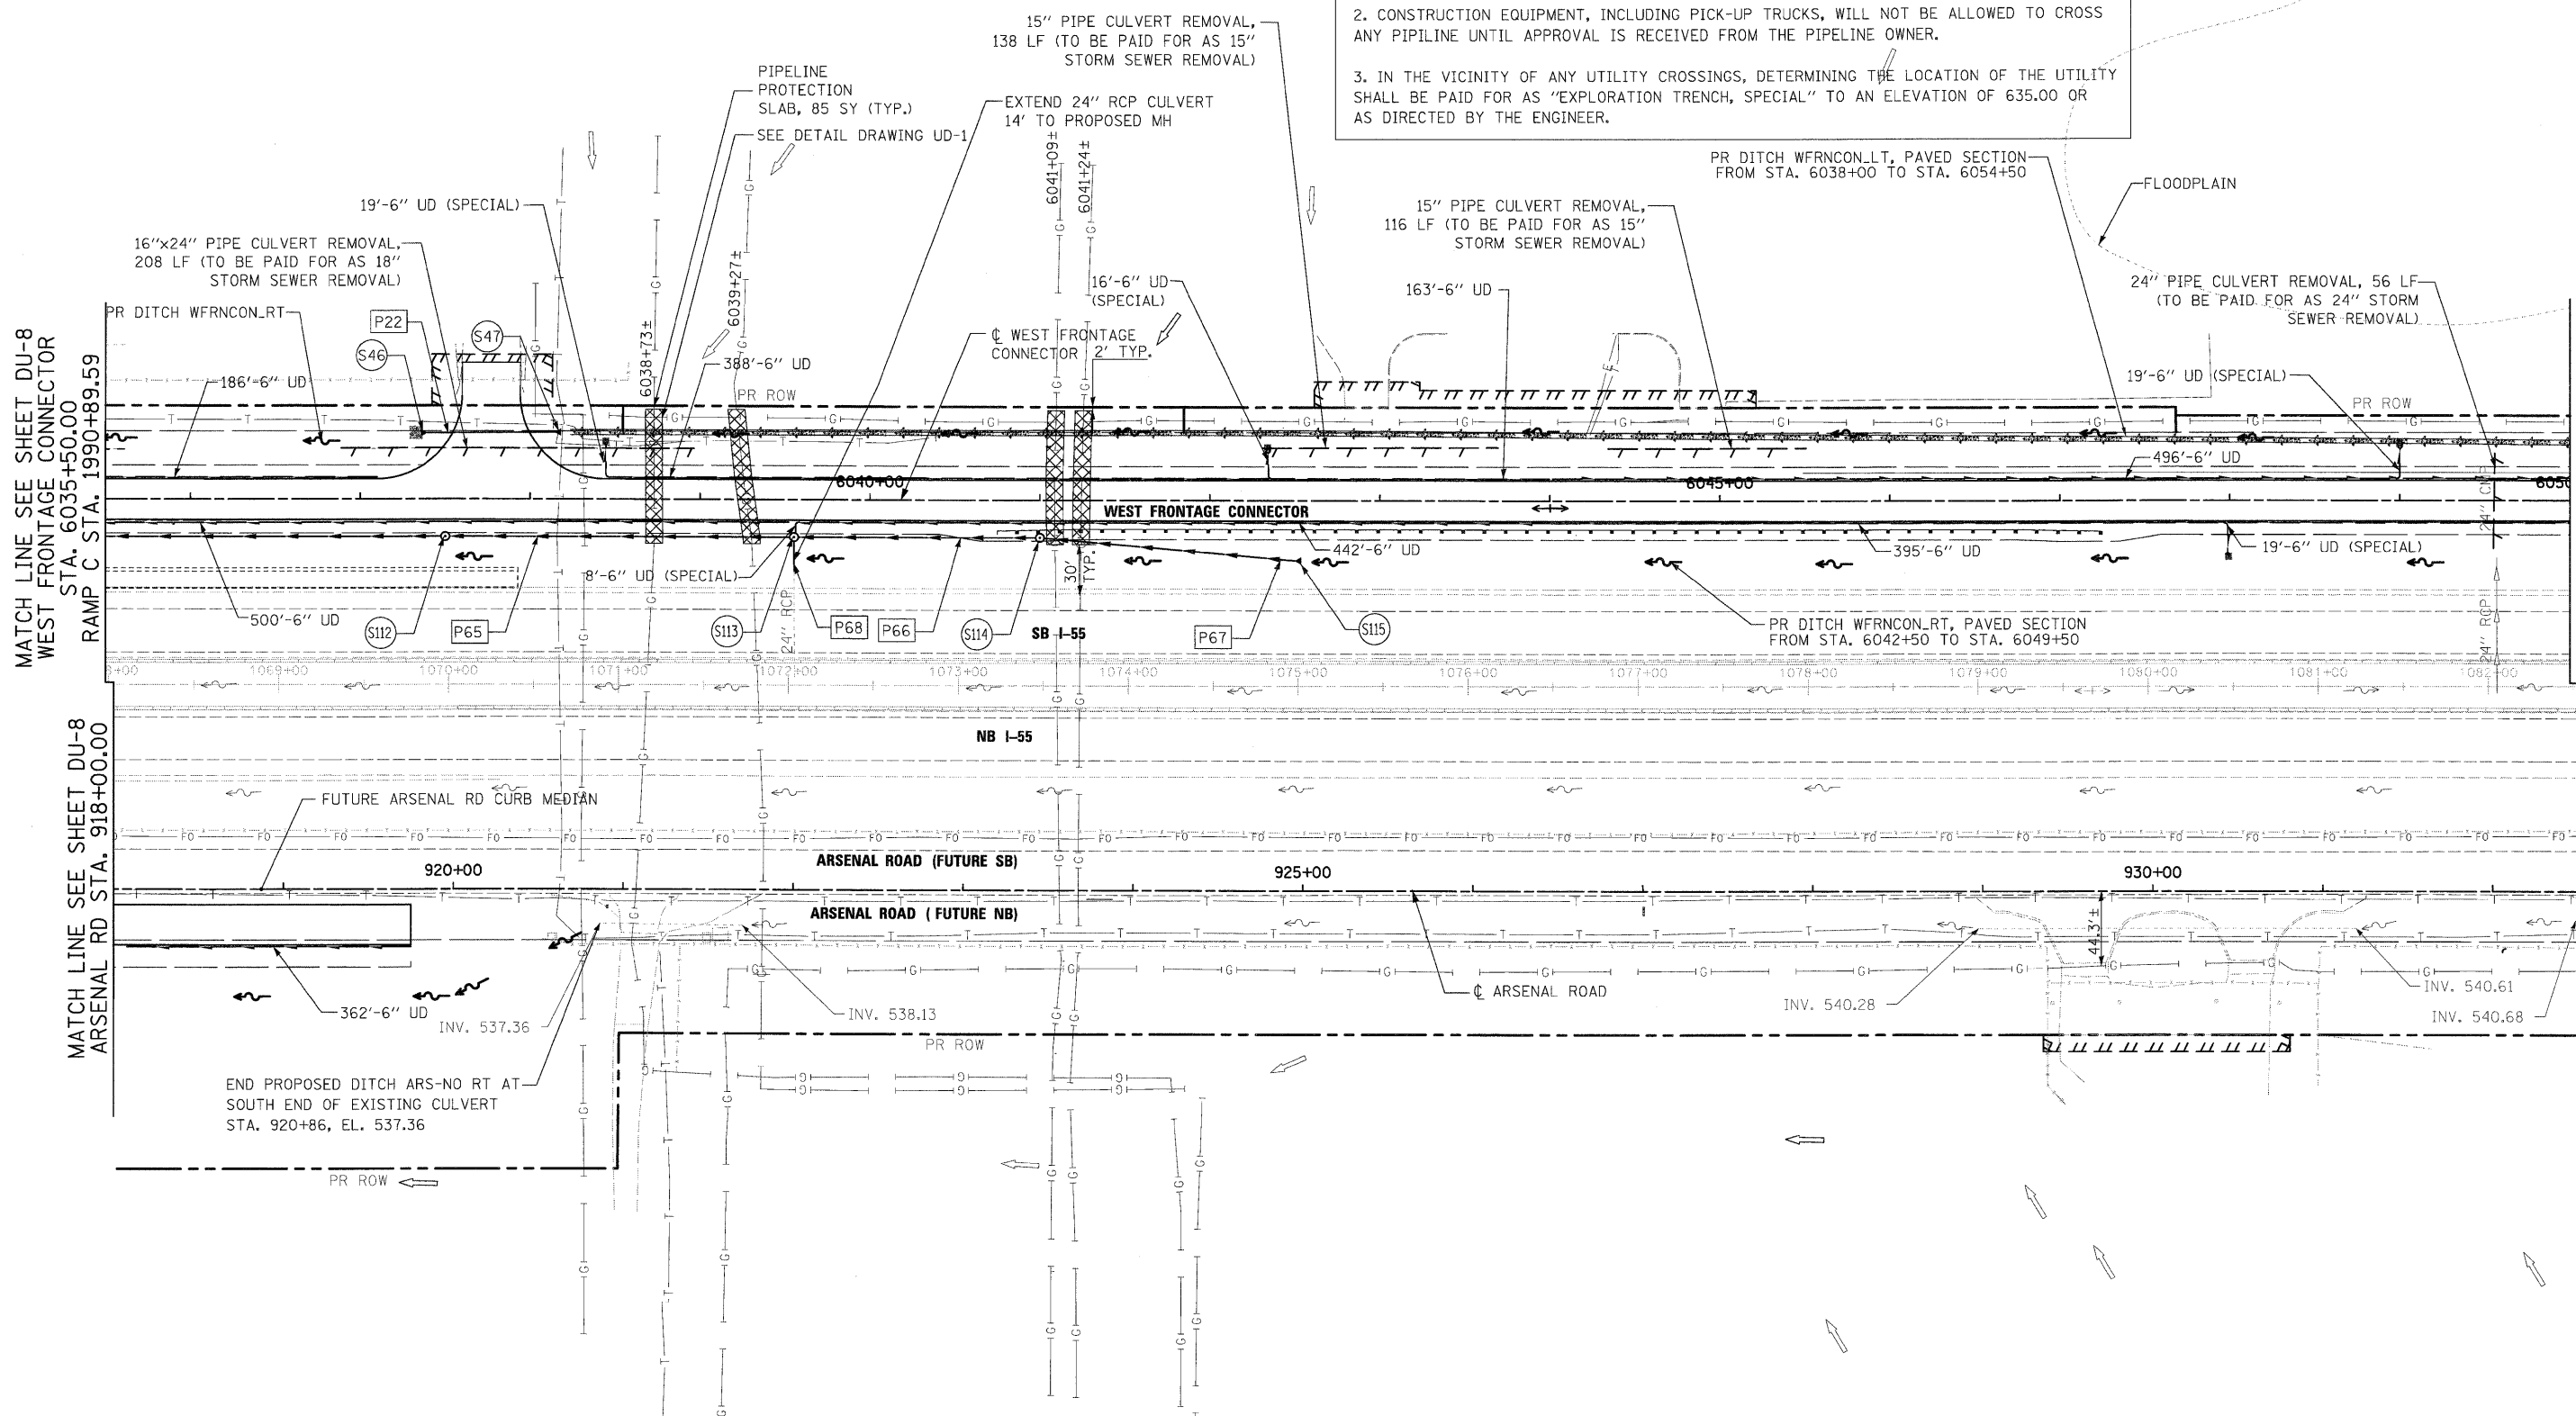

 
MATCH LINE SEE SHEET DU-8
WEST FRONTAGE CONNECTOR
STA. 6035+50.00
RAMP C STA. 1990+89.59

MATCH LINE SEE SHEET DU-10
WEST FRONTAGE CONNECTOR
STA. 6050+00.00

MATCH LINE SEE SHEET DU-8
ARSENAL RD STA. 918+00.00

MATCH LINE SEE SHEET DU-10
ARSENAL RD STA. 932+50.00

END PROPOSED DITCH ARS-NO RT AT
SOUTH END OF EXISTING CULVERT
STA. 920+86, EL. 537.36



SINGH & ASSOCIATES, INC.
CONSULTING ENGINEERS
300 W. ADAMS ST.
CHICAGO, IL 60606
TEL: (312) 625-0240
FAX: (312) 625-8449

FILE NAME = D162C31-SHT-DRAIN09.dgn	USER NAME = TKluigel	DESIGNED - VP/PTK	REVISED -
		DRAWN - VP/PTK	REVISED -
		CHECKED - CL	REVISED -
		DATE - 12/18/09	REVISED -

STATE OF ILLINOIS
DEPARTMENT OF TRANSPORTATION

DRAINAGE AND UTILITY PLAN

SCALE: 1"=50' SHEET NO. 9 OF 22 SHEETS STA. TO STA.

F.A.I RTE. 55	SECTION (99-1&2)AC-3	COUNTY WILL	TOTAL SHEETS 524	SHEET NO. 152
FED. ROAD DIST. NO. 1 ILLINOIS FED. AID PROJECT			CONTRACT NO. 60C31	

FINAL