


FILE NAME = D160C31-SHT-DRAIN11.dgn	USER NAME = TKluegel	DESIGNED - VP/PTK	REVISED -
PLOT SCALE = 1:50	CHECKED - CL	DRAWN - VP/PTK	REVISED -
PLOT DATE = 12/11/2009	DATE - 12/18/09	REVISIONS	REVISED -

**STATE OF ILLINOIS
 DEPARTMENT OF TRANSPORTATION**

DRAINAGE AND UTILITY PLAN

SCALE: 1"=50' SHEET NO. 11 OF 22 SHEETS STA. TO STA.

F.A.I. RTE.	SECTION	COUNTY	TOTAL SHEETS	SHEET NO.
55	(99-1&2)AC-3	WILL	524	154
FED. ROAD DIST. NO. 1 ILLINOIS FED. AID PROJECT			CONTRACT NO. 60C31	

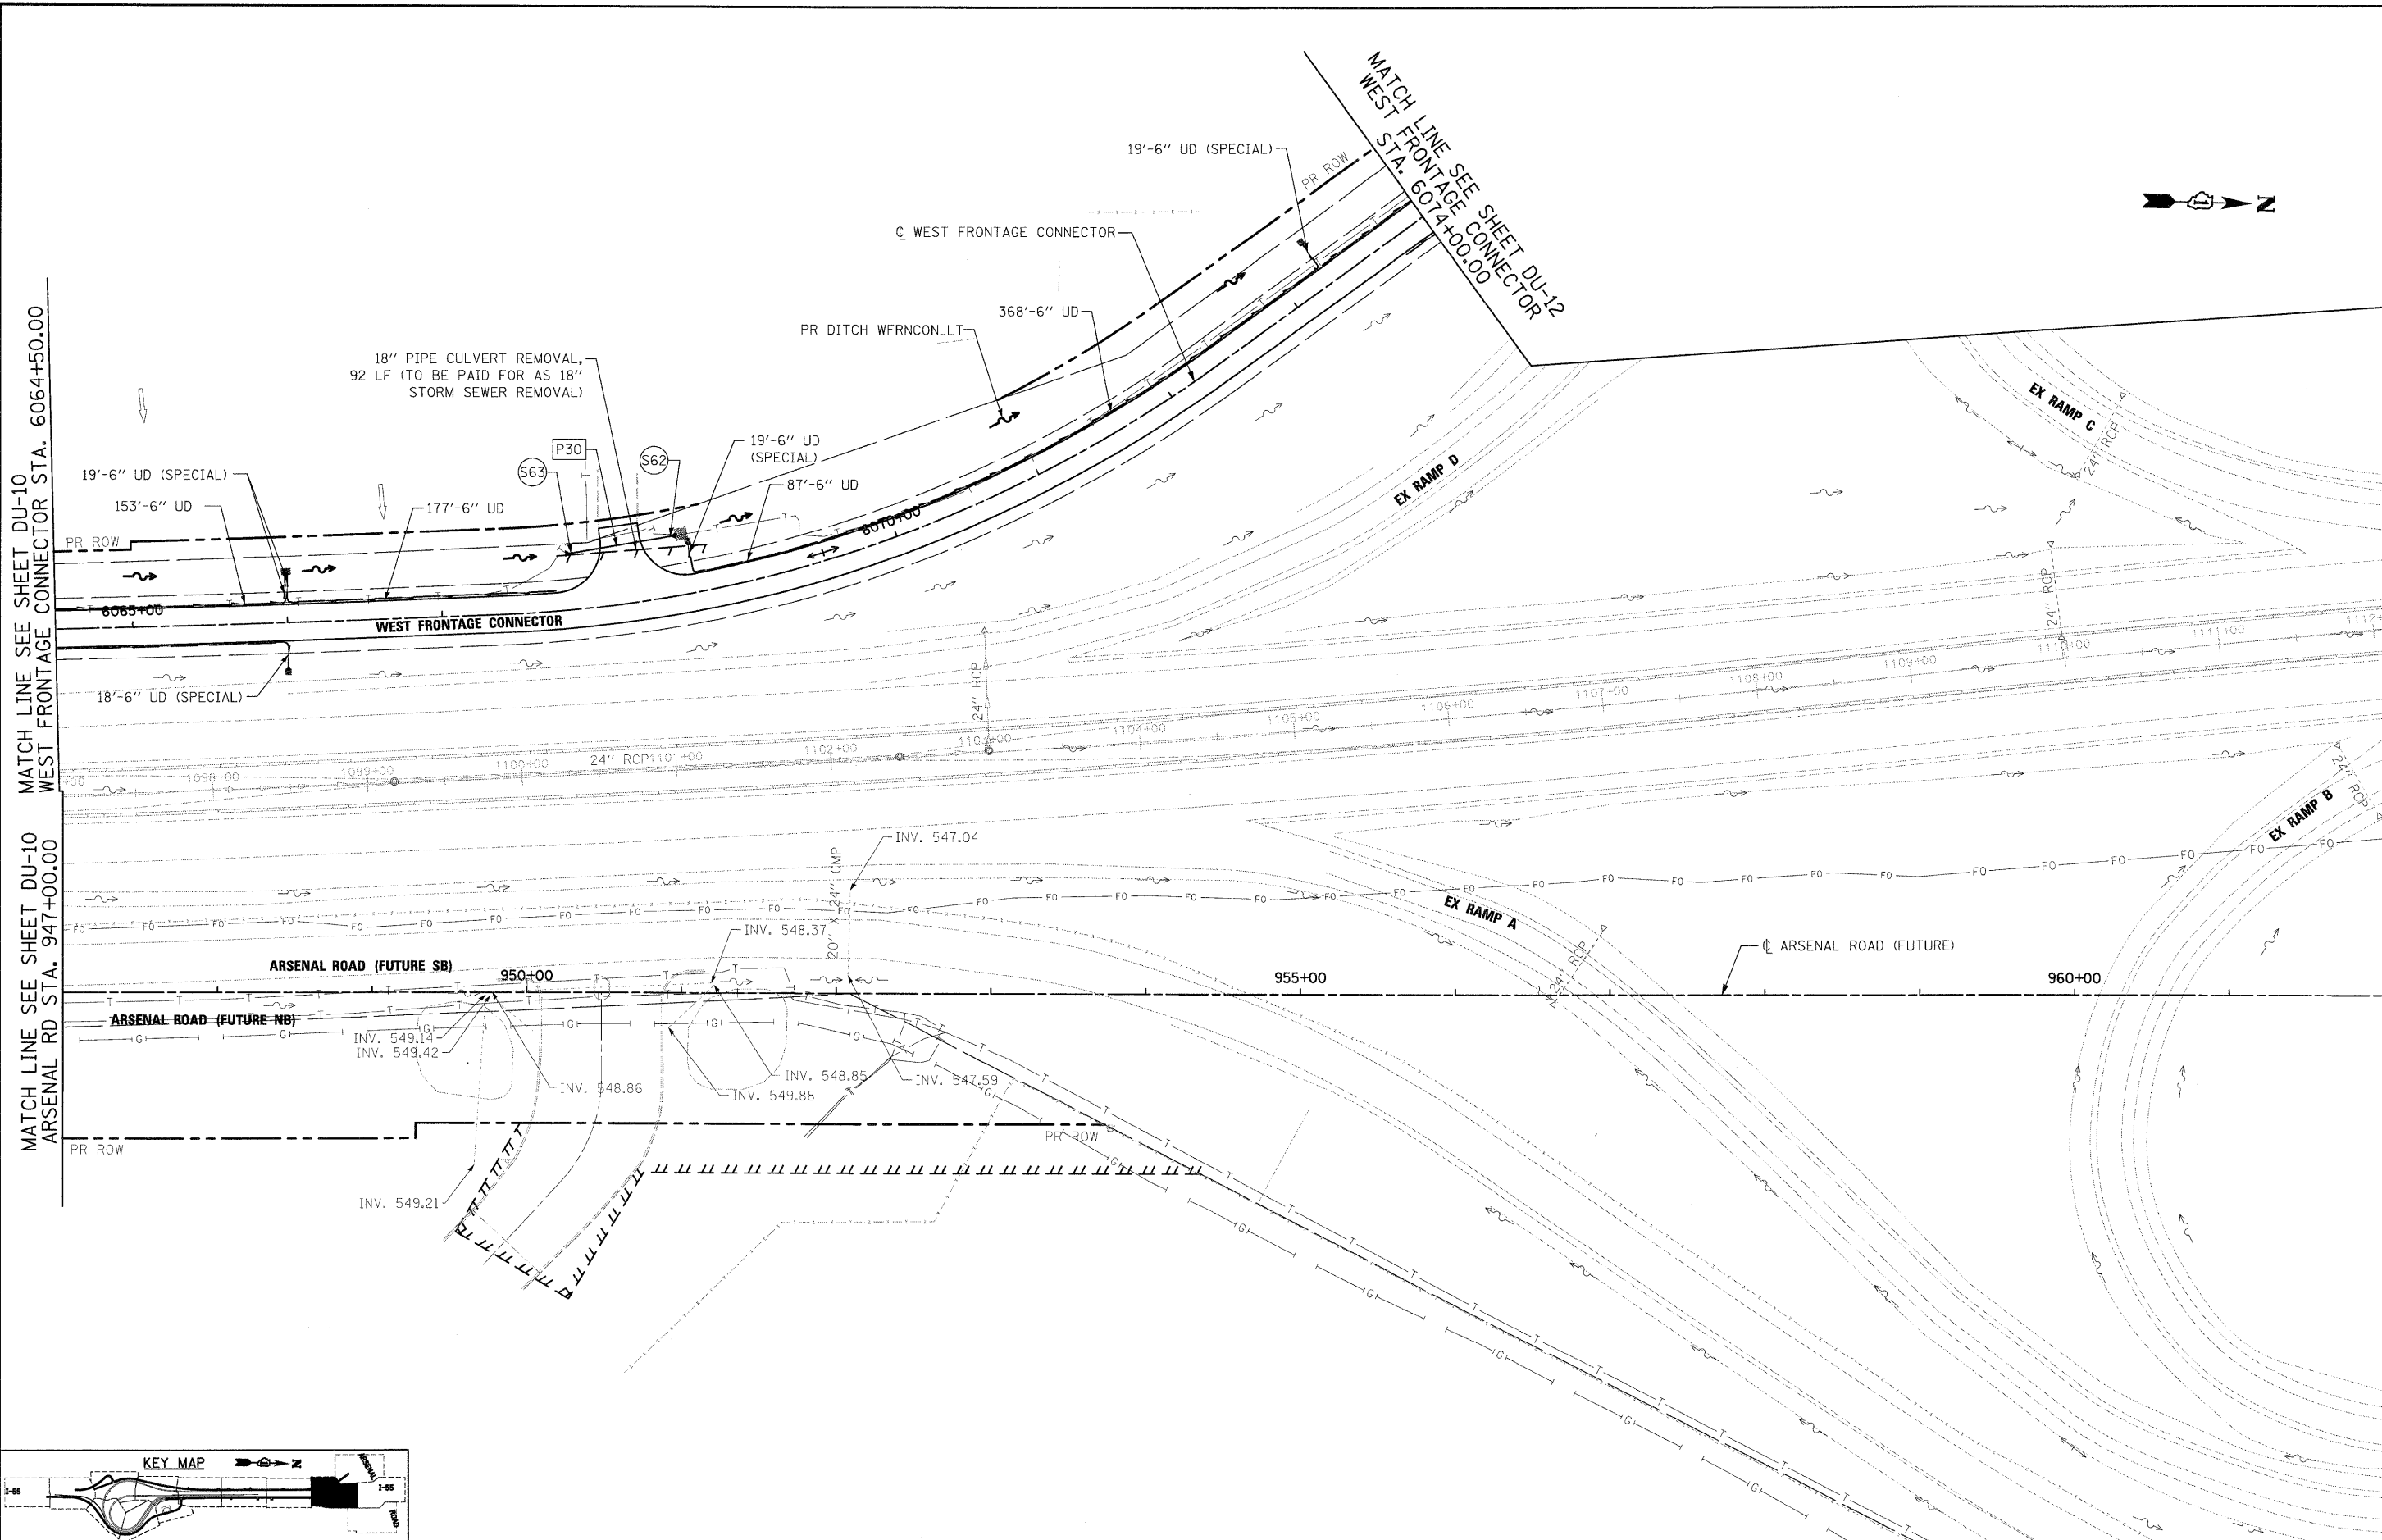

MATCH LINE SEE SHEET DU-13
 ARSENAL RD STA. 9062+00.00

MATCH LINE SEE SHEET DU-10
 WEST FRONTAGE CONNECTOR STA. 6064+50.00

MATCH LINE SEE SHEET DU-10
 ARSENAL RD STA. 947+00.00

MATCH LINE SEE SHEET DU-12
 WEST STA. 6074+00.00