


MATCH LINE SEE SHEET DU-12
WEST FRONTAGE CONNECTOR
STA. 6086+50.00

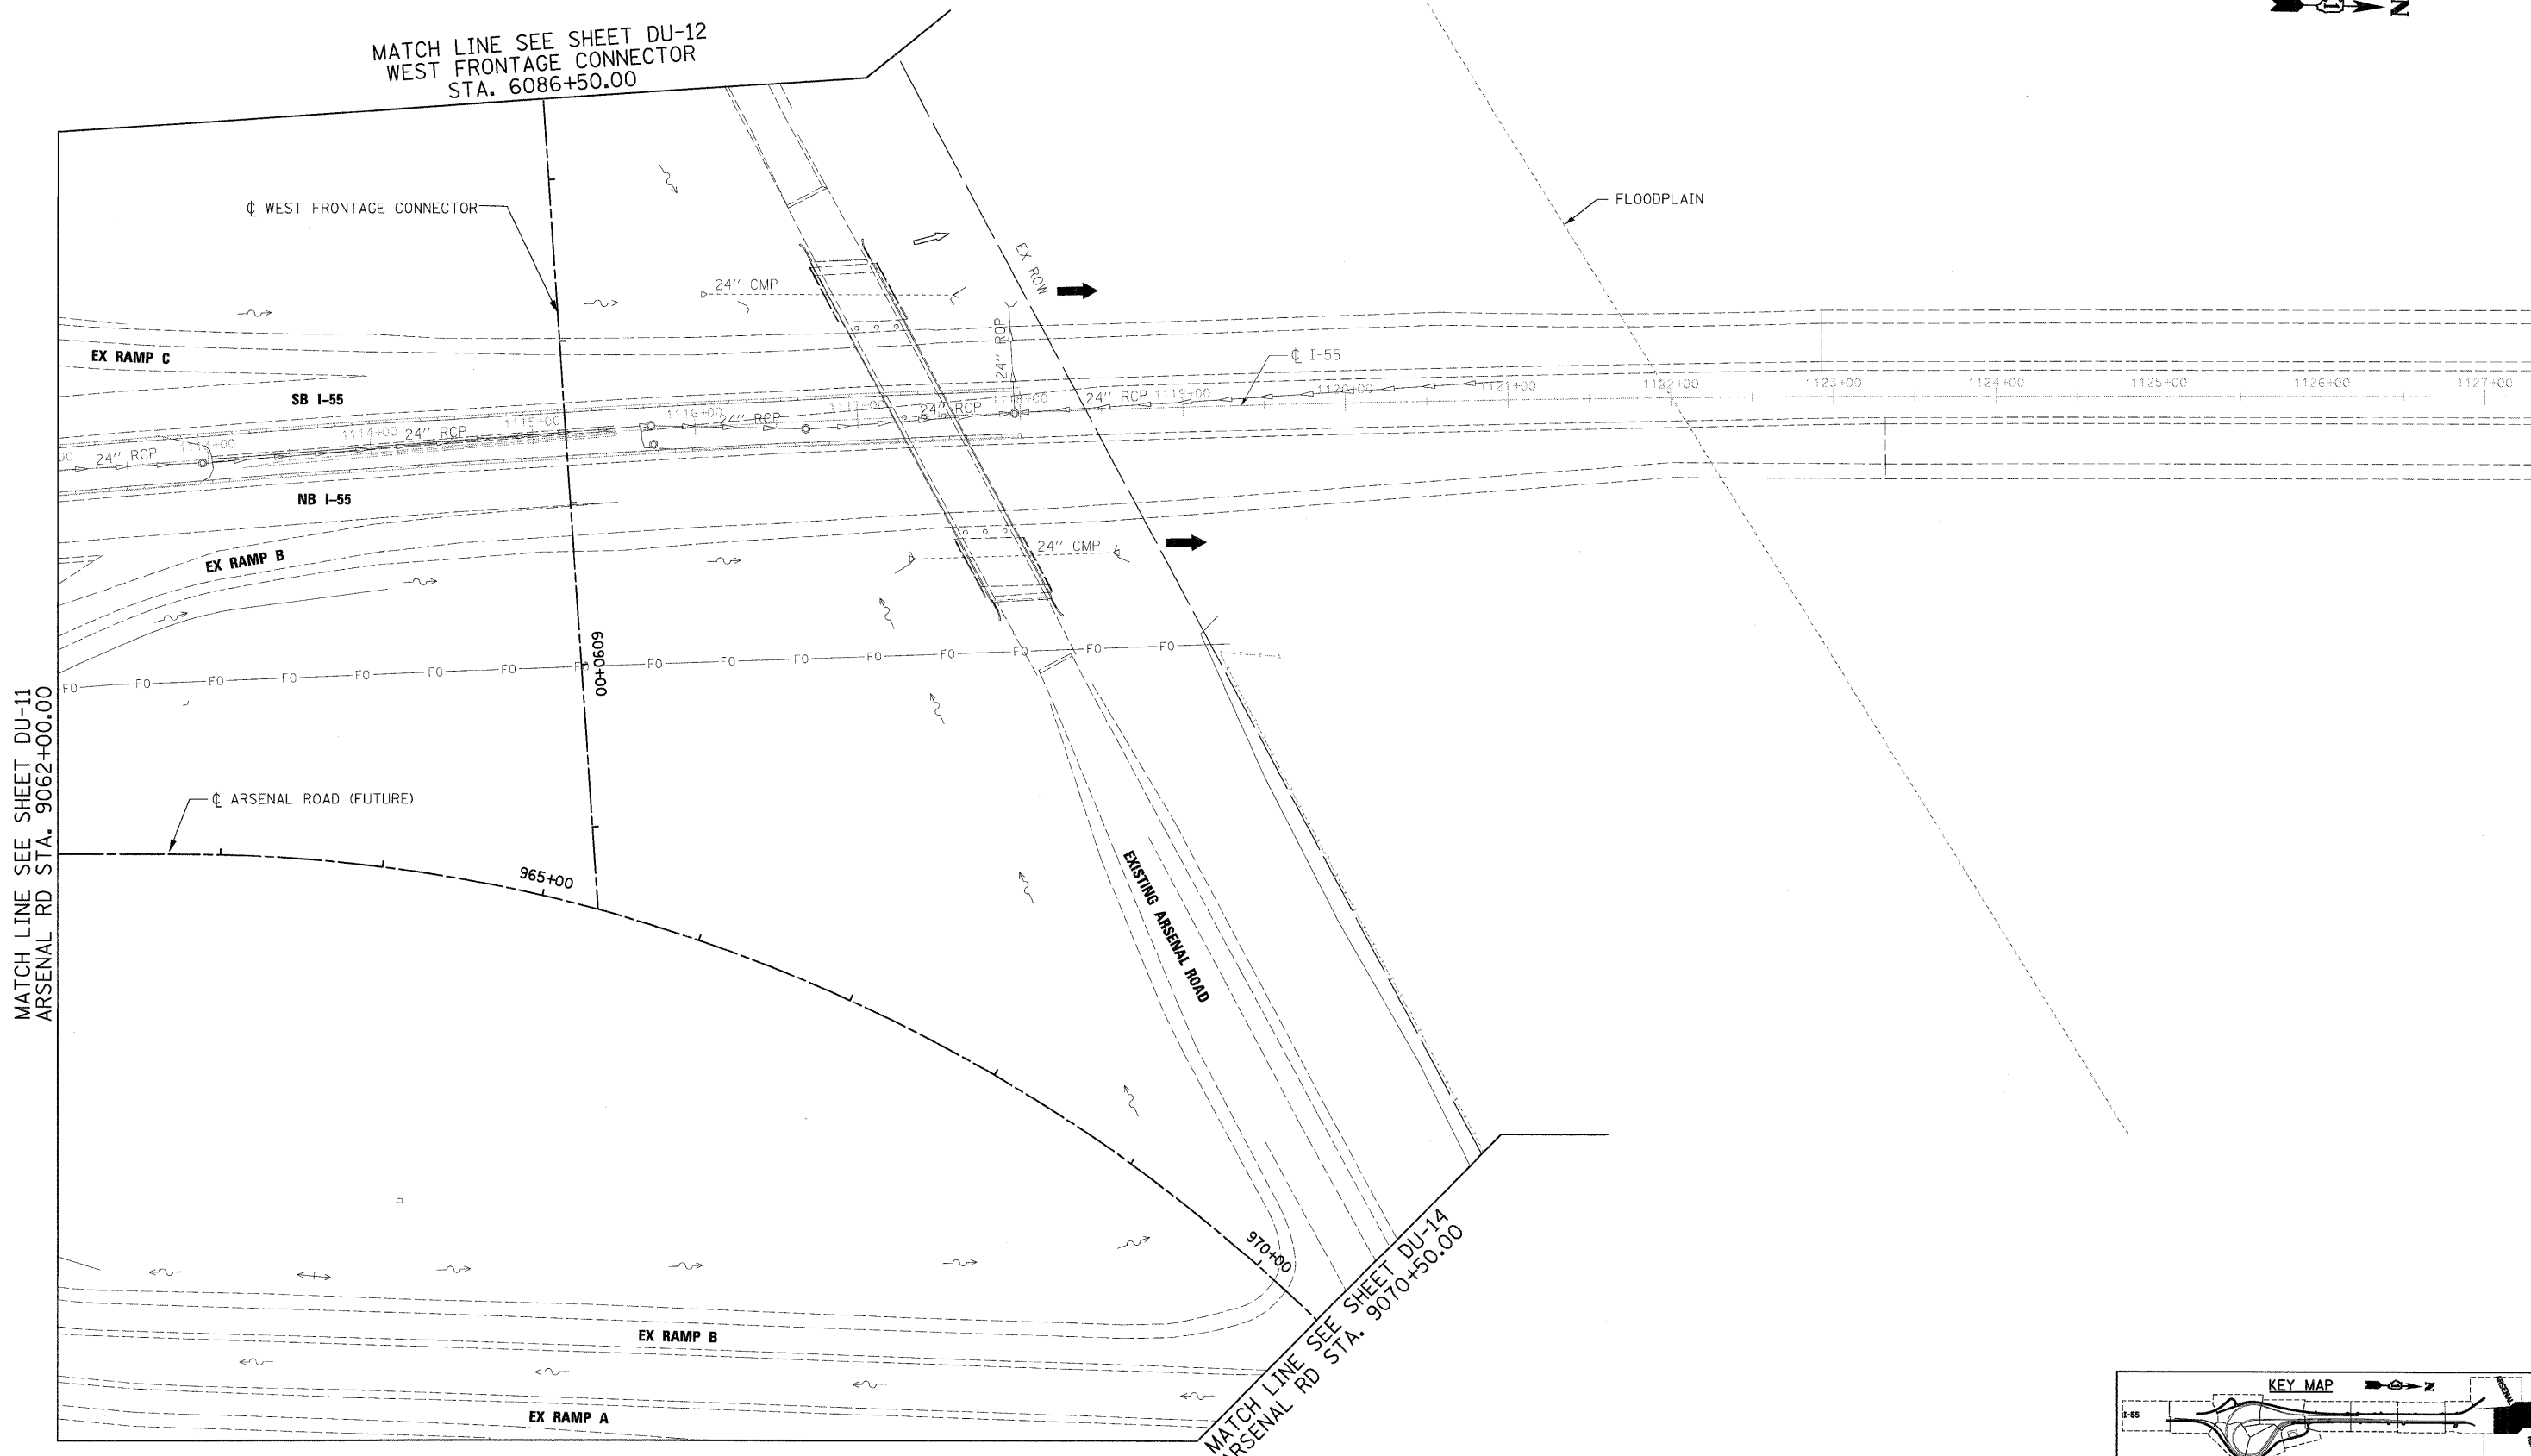

MATCH LINE SEE SHEET DU-11
ARSENAL RD STA. 9062+00.00

MATCH LINE SEE SHEET DU-14
ARSENAL RD STA. 9070+50.00


SINGH & ASSOCIATES, INC.
 CONSULTING ENGINEERS
 300 W. ADAMS ST.
 CHICAGO, IL 60606
 TEL: (312) 629-0240
 FAX: (312) 629-8449

FILE NAME = D162C31-SHT-DRAIN13.dgn	USER NAME = TKluegel	DESIGNED - VP/PTK	REVISED -
		DRAWN - VP/PTK	REVISED -
		CHECKED - CL	REVISED -
		DATE - 12/18/09	REVISED -

STATE OF ILLINOIS
DEPARTMENT OF TRANSPORTATION

DRAINAGE AND UTILITY PLAN

 SCALE: 1"=50' SHEET NO. 13 OF 22 SHEETS STA. TO STA.



F.A.I. RTE.	SECTION	COUNTY	TOTAL SHEETS	SHEET NO.
55	(99-1&2)AC-3	WILL	524	156
FED. ROAD DIST. NO. 1 ILLINOIS FED. AID PROJECT			CONTRACT NO. 60C31	