

CB 12
 CB TY A, 4' DIA.
 TY 8 GRATE
 STA. 34+75, 43.5'L.T.
 RIM = 667.40
 N. INV. = 660.40
 S. INV. = 661.10
 E. INV. = 662.10

CB 15
 CB TY A, 4' DIA.
 TY 8 GRATE
 STA. 37+50, 43.5'L.T.
 RIM = 666.80
 N. INV. = 661.10
 S. INV. = 661.50
 E. INV. = 661.90


CB 17
 CB TY A, 4' DIA.
 TY 8 GRATE
 STA. 39+00, 43.5'L.T.
 RIM = 666.60
 N. INV. = 661.50
 S. INV. = 661.50
 E. INV. = 661.50

CB 19
 CB TY A, 4' DIA.
 TY 8 GRATE
 STA. 40+50, 43.5'L.T.
 RIM = 666.30
 S. INV. = 662.20
 E. INV. = 662.30

CB 20
 CB TY A, 5' DIA.
 TY 8 GRATE
 STA. 41+55, 45.5'L.T.
 RIM = 665.70
 N. INV. = 660.70

CB 23
 CATCH BASINS, TYPE A, 5' DIA.
 TY 1F OL (CITY OF CHICAGO)
 W/HALF TRAP & 3" VORTEX RESTRICTOR
 STA. 45+00, 40'L.T.
 RIM = 664.57
 N. INV. = 660.50
 S. INV. = 660.00
 E. INV. = 659.50

CB 24
 CB TY A, 4' DIA.
 TY 8 GRATE
 STA. 45+40, 45.8'L.T.
 RIM = 664.90
 N. INV. = 660.90
 S. INV. = 660.50

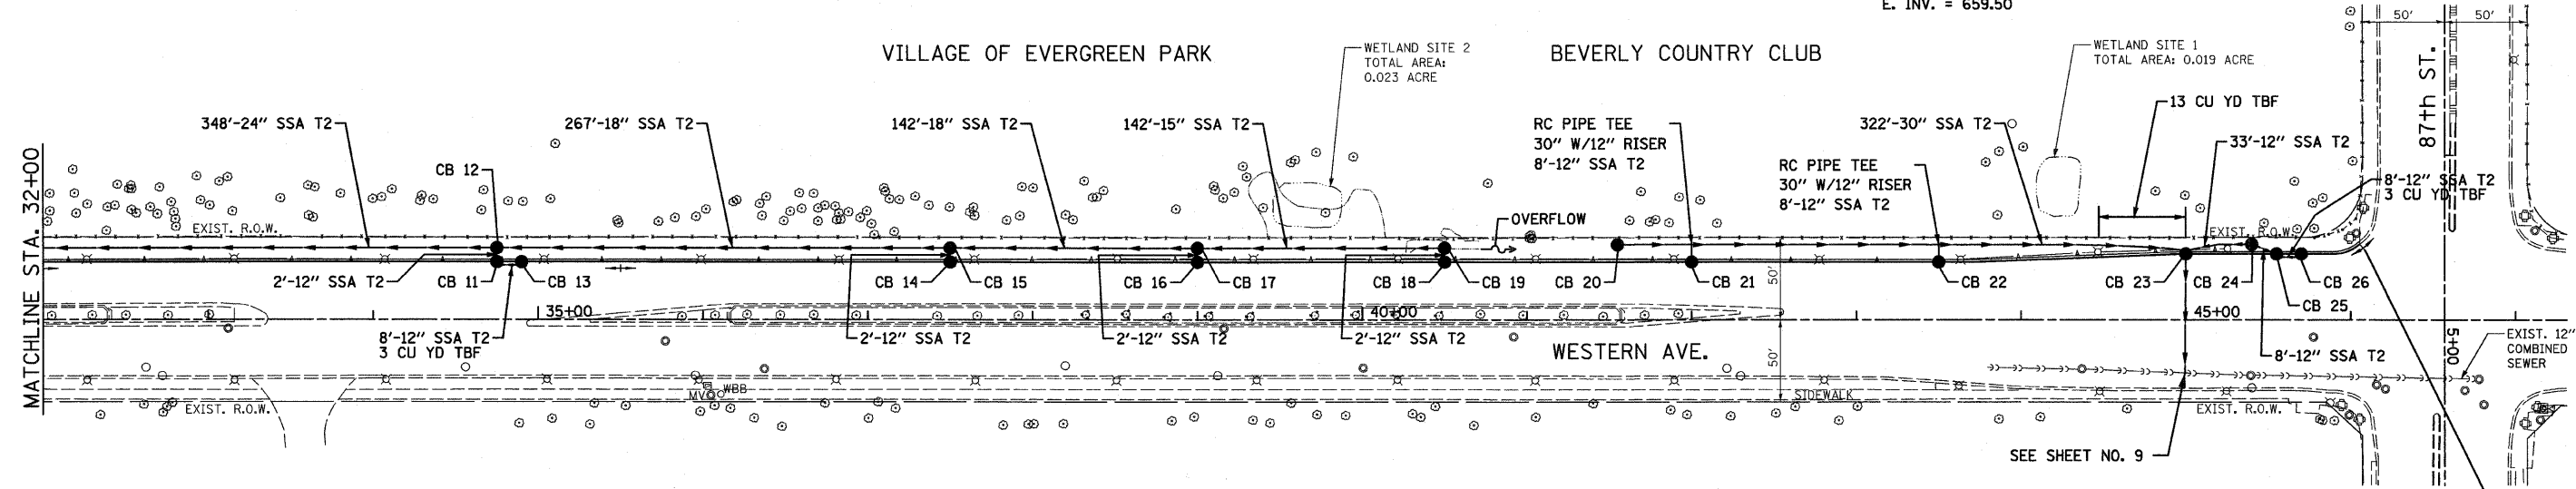

CB 11
 CB TY A, 4' DIA.
 TY 1F OL
 STA. 34+75, 35'L.T.
 RIM = 667.41
 INV. = 662.20

CB 13
 CB TY A, 4' DIA.
 TY 1F OL
 STA. 34+90, 35'L.T.
 RIM = 667.36
 INV. = 662.36

CB 14
 CB TY A, 4' DIA.
 TY 1F OL
 STA. 37+50, 35'L.T.
 RIM = 667.00
 INV. = 662.00

CB 16
 CB TY A, 4' DIA.
 TY 1F OL
 STA. 39+00, 35'L.T.
 RIM = 666.50
 INV. = 661.60

CB 18
 CB TY A, 4' DIA.
 TY 1F OL
 STA. 40+50, 35'L.T.
 RIM = 666.23
 INV. = 662.40


CB 21
 CB TY A, 4' DIA.
 TY 1F OL
 STA. 42+00, 35'L.T.
 RIM = 665.67
 INV. = 662.67

CB 22
 CB TY A, 4' DIA.
 TY 1F OL
 STA. 43+50, 35'L.T.
 RIM = 665.22
 INV. = 662.22

CB 25
 CB TY A, 4' DIA.
 TY 1F OL
 STA. 45+55, 40'L.T.
 RIM = 664.39
 N. INV. = 661.00
 S. INV. = 661.00

CB 26
 CB TY A, 4' DIA.
 TY 1F OL
 STA. 45+70, 40'L.T.
 RIM = 664.34
 INV. = 661.10

NOTE:
 1. ALL STORM SEWERS ARE RCP UNLESS OTHERWISE NOTED.

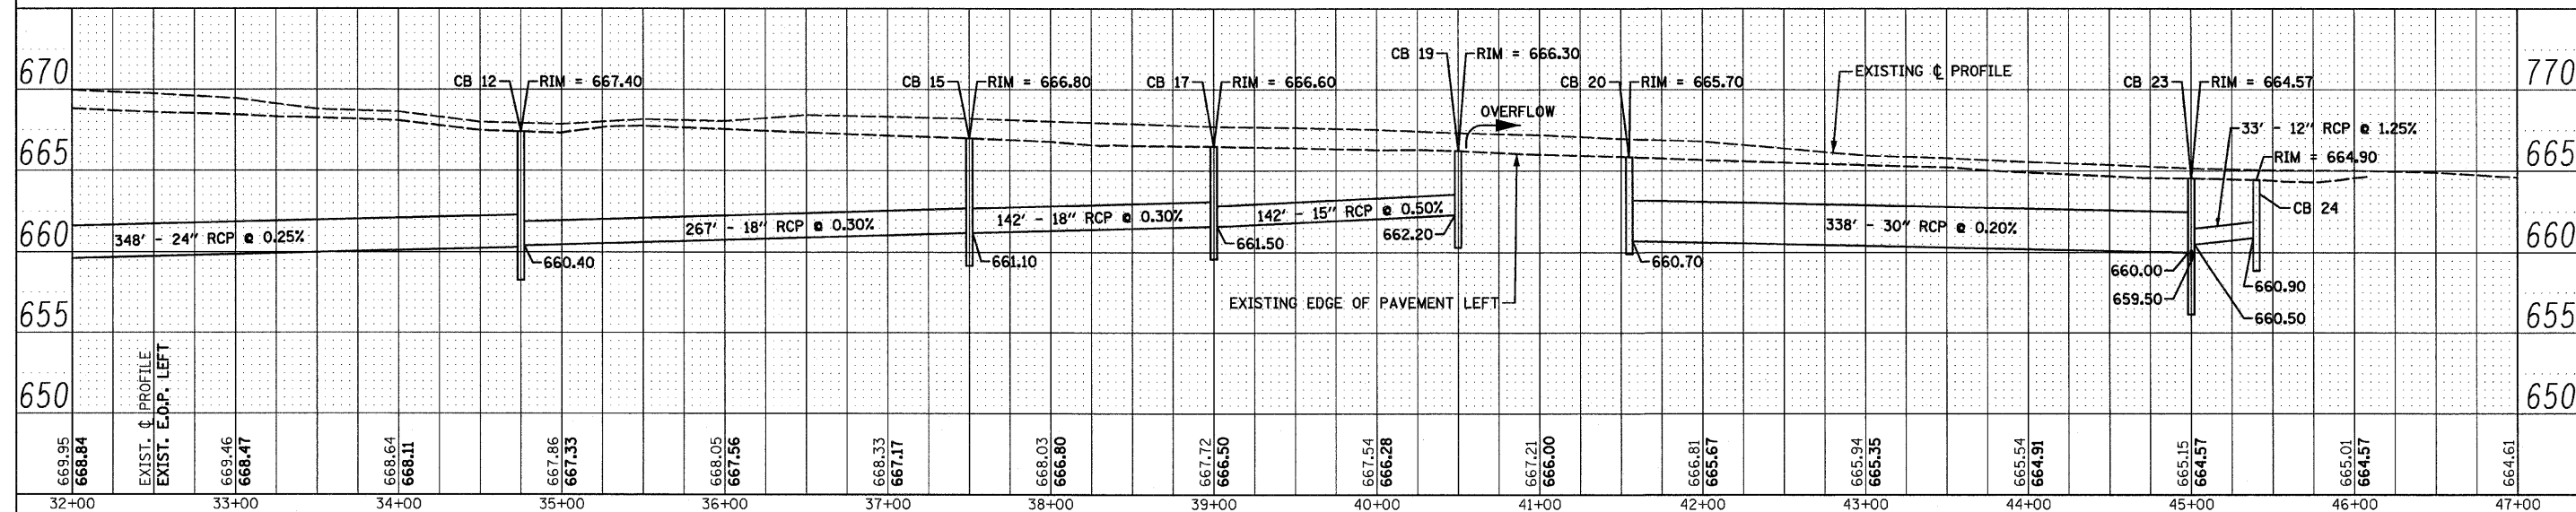

FILE NAME = D:\16015-shr-dra\2.dgn	DESIGNED - S.J.P.	REVISIONS	F.A.P. RTE.	SECTION	COUNTY	TOTAL SHEETS	SHEET NO.
PLT DATE = 3/22/2010	DRAWN - A.C.S.	REVISIONS	370	2009-015 T	COOK	20	8
CHRISTIAN-ROGE & ASSOCIATES, INC. ENGINEERS-PLANNERS-SURVEYORS 211 WEST WACKER DRIVE CHICAGO, ILLINOIS 60606 PHONE: (312)372-2023 FAX: (312)372-5274	CHECKED - S.J.P.	REVISIONS	DRAINAGE AND UTILITY PLAN AND PROFILE WESTERN AVE.				CONTRACT NO. 60G15
DATE - MARCH 19, 2010	REVISIONS	SCALE: 1" = 50'	SHEET NO. 2 OF 4 SHEETS		STA. 32+00 TO STA. 46+00		FED. ROAD DIST. NO. 1 ILLINOIS FED. AID PROJECT

STATE OF ILLINOIS
 DEPARTMENT OF TRANSPORTATION