



F.A.P. RTE.	SECTION	COUNTY	TOTAL SHEETS	SHEET NO.
310	60-16	MADISON	662	182

STA. TO STA.
 FED. ROAD DIST. NO. ILLINOIS FED. AID PROJECT
 CONTRACT NO. 76311

NOTE: (B) (C) & (D) REFER TO DETAILS B, C, & D ON TRAFFIC SIGNAL DETAIL SHEET

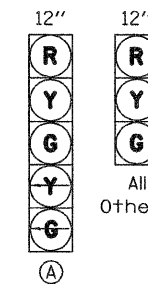

All Others

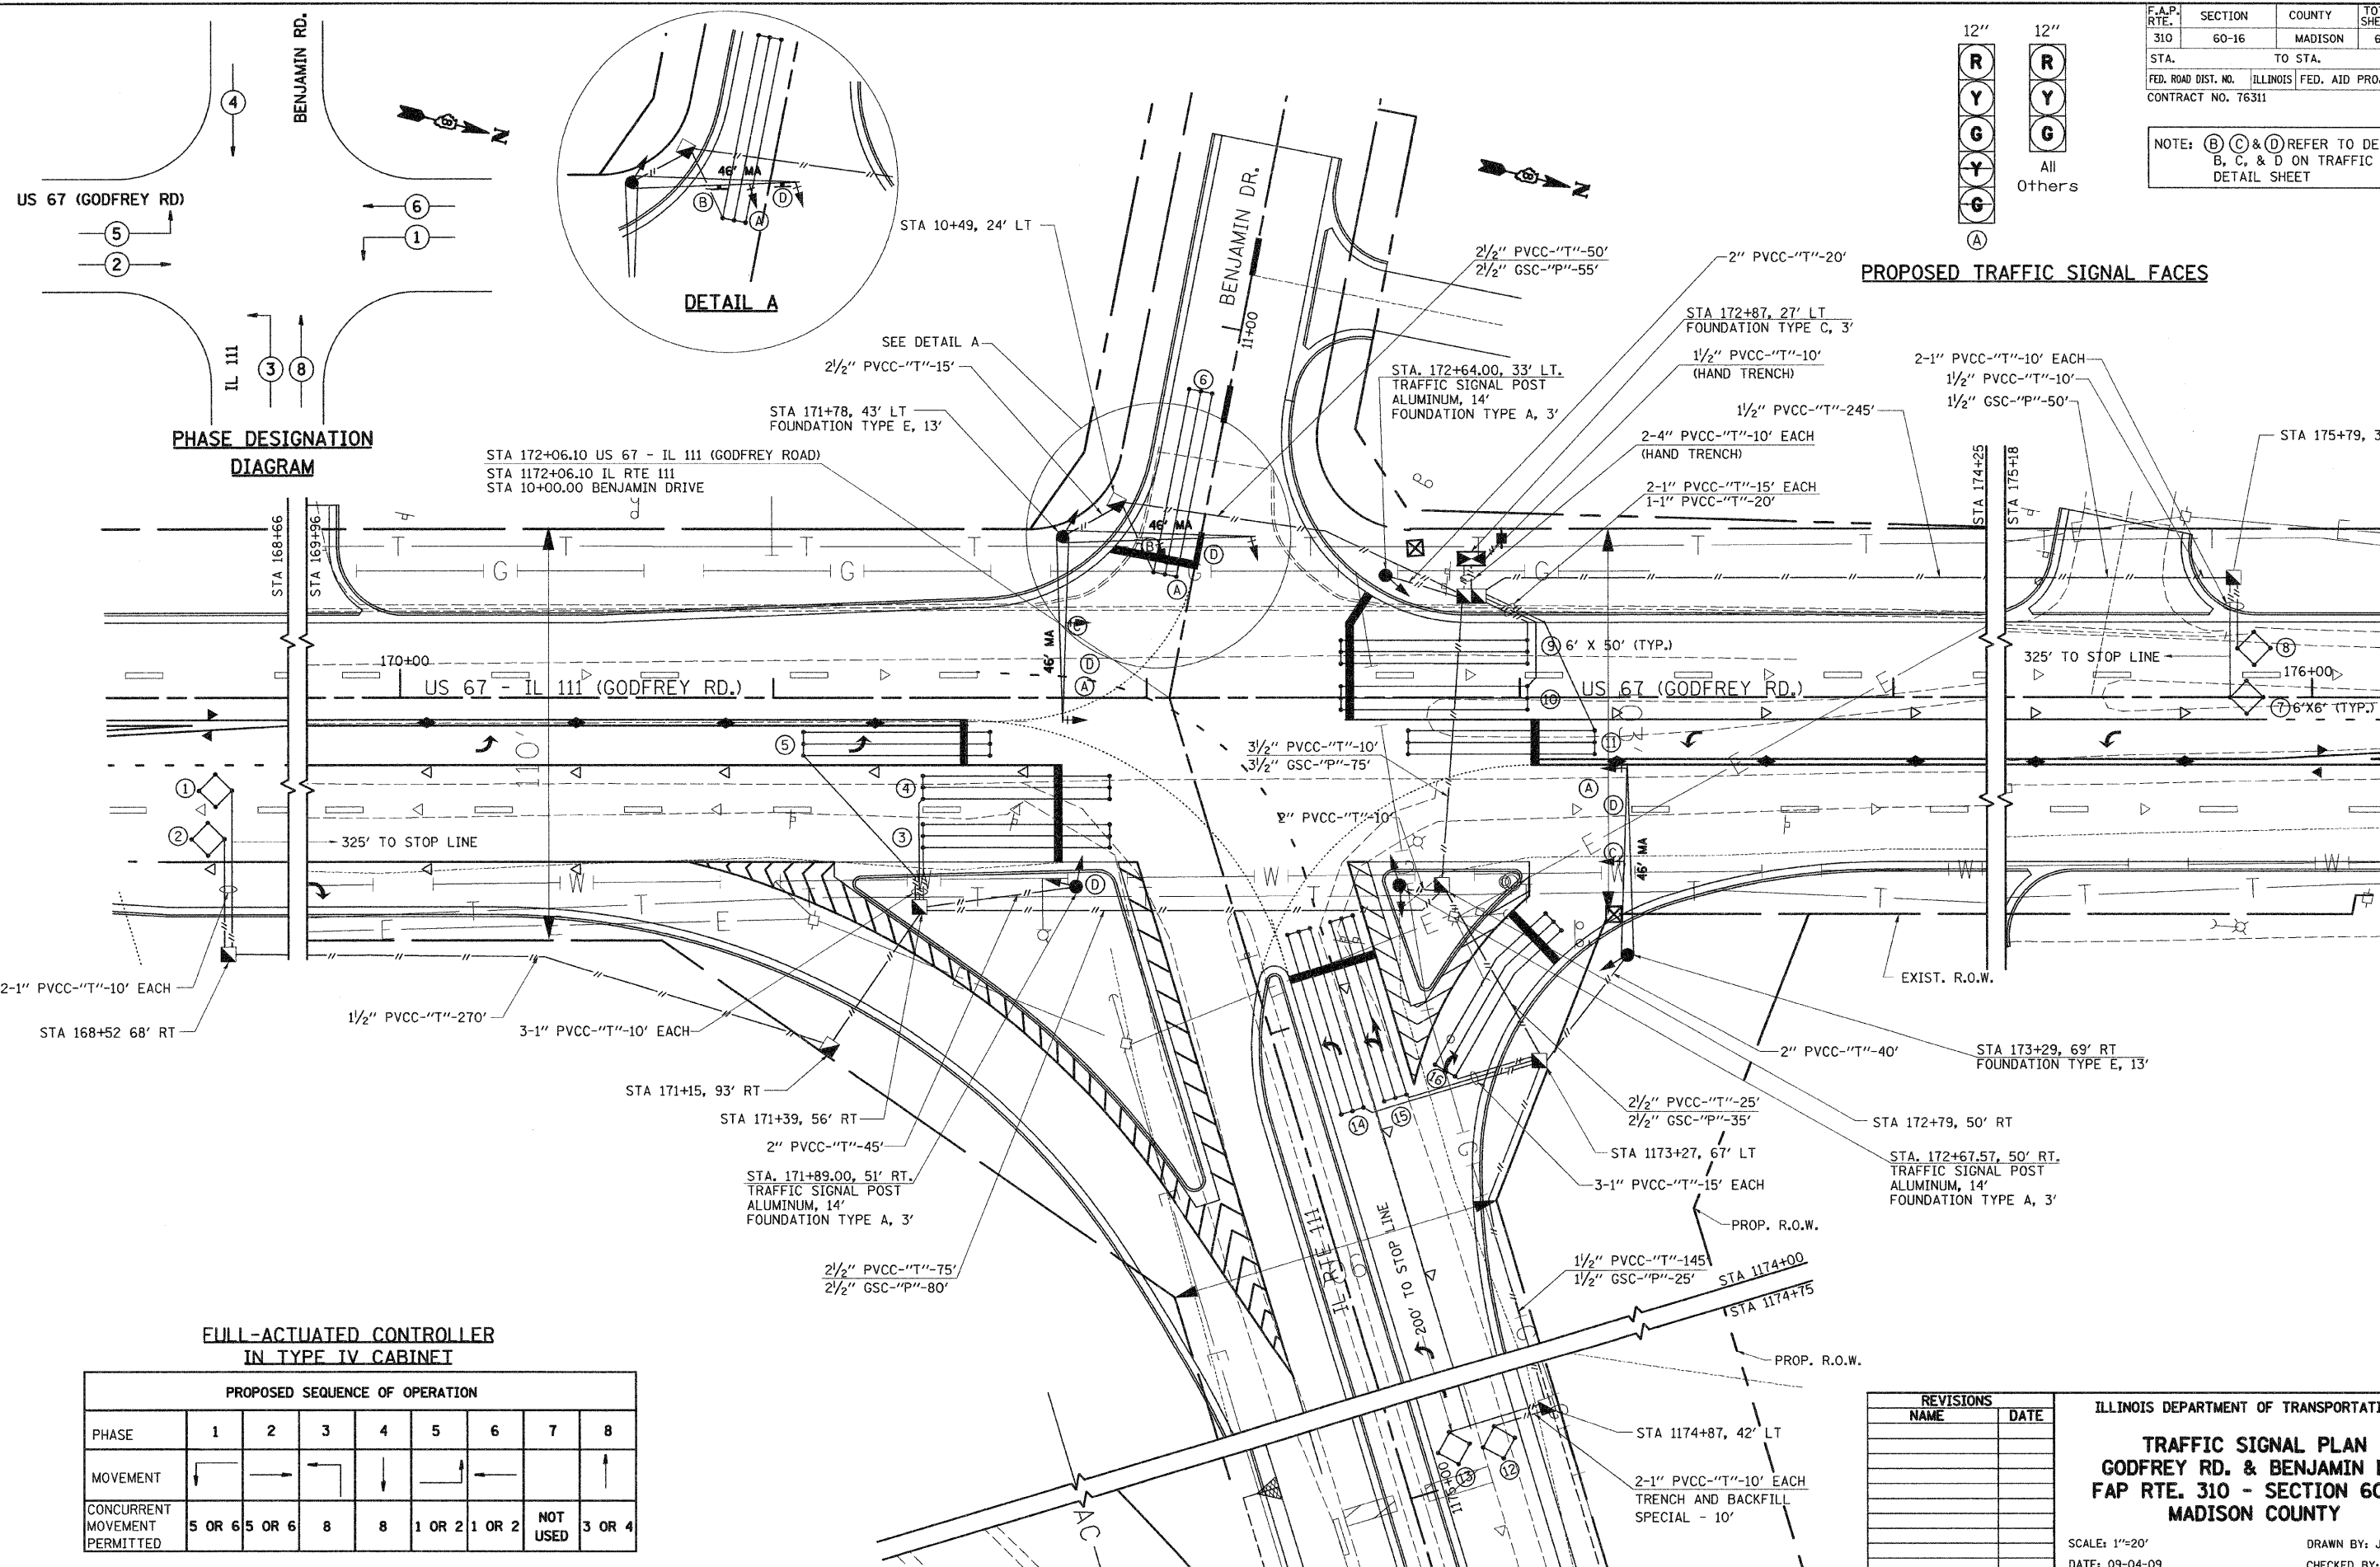

**FULL-ACTUATED CONTROLLER
 IN TYPE IV CABINET**

PROPOSED SEQUENCE OF OPERATION								
PHASE	1	2	3	4	5	6	7	8
MOVEMENT	↓	→	←	↑	←	→		↑
CONCURRENT MOVEMENT PERMITTED	5 OR 6	5 OR 6	8	8	1 OR 2	1 OR 2	NOT USED	3 OR 4

REVISIONS	
NAME	DATE

ILLINOIS DEPARTMENT OF TRANSPORTATION

**TRAFFIC SIGNAL PLAN
 GODFREY RD. & BENJAMIN DR.
 FAP RTE. 310 - SECTION 60-16
 MADISON COUNTY**

SCALE: 1"=20'
 DATE: 09-04-09

DRAWN BY: J.T.C.
 CHECKED BY: K.C.