
 


F.A.P. RTE.	SECTION	COUNTY	TOTAL SHEETS	SHEET NO.
FAP399	36R-1,37R-2	TAZEWELL	449	124
STA 7+650		TO STA 7+825		
FED. ROAD DIST. NO. 4		ILLINOIS FED. AID PROJECT		


BY	DATE
LCE	6-2-09
FINAL SURVEY PLOTTED	
NOTE BOOK TEMPLATE	
AREAS CHECKED	
NO.	

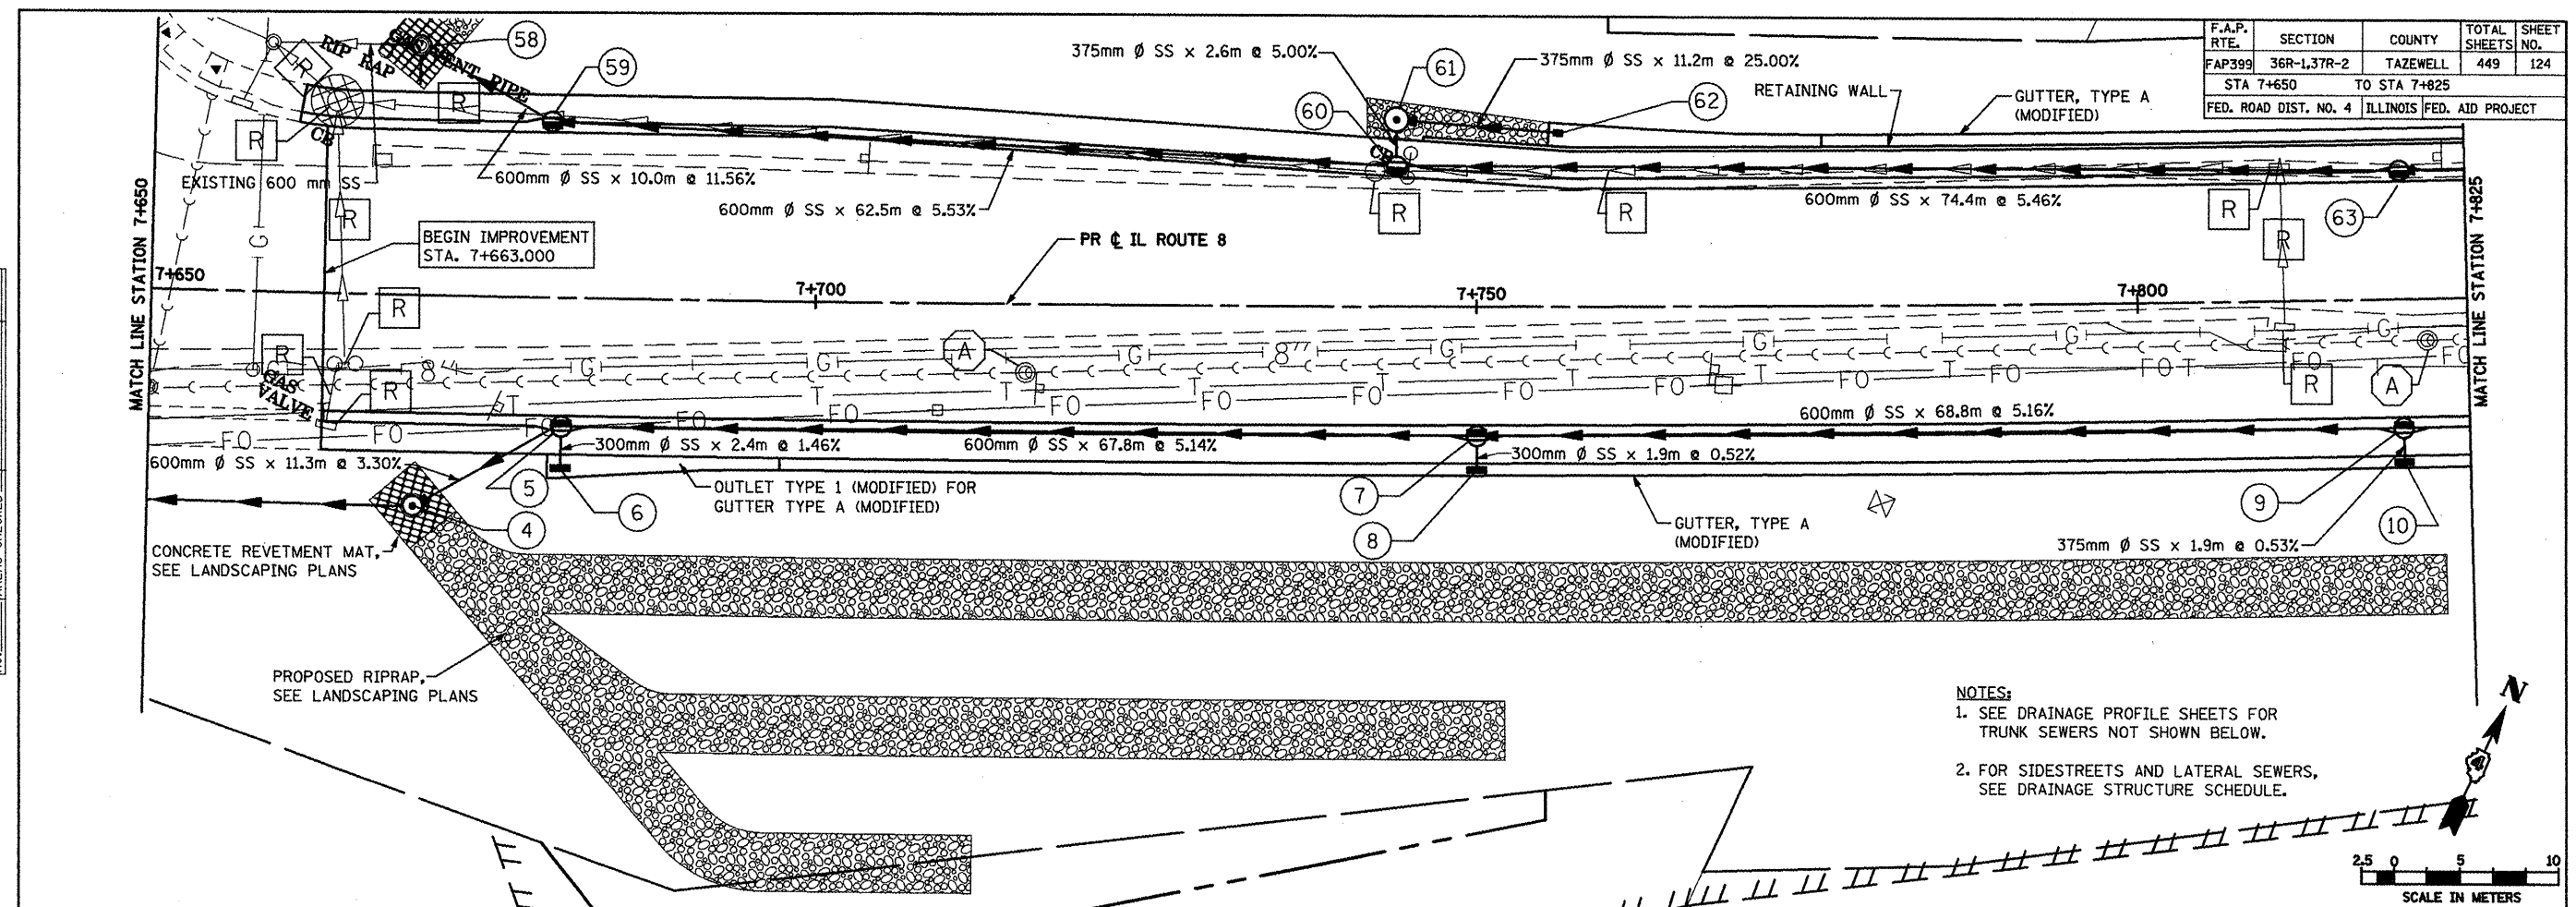

- NOTES:
- SEE DRAINAGE PROFILE SHEETS FOR TRUNK SEWERS NOT SHOWN BELOW.
 - FOR SIDESTREETS AND LATERAL SEWERS, SEE DRAINAGE STRUCTURE SCHEDULE.



BY	DATE
LCE	6-2-09
ORIGINAL SURVEY PLOTTED	
NOTE BOOK TEMPLATE	
AREAS CHECKED	
NO.	

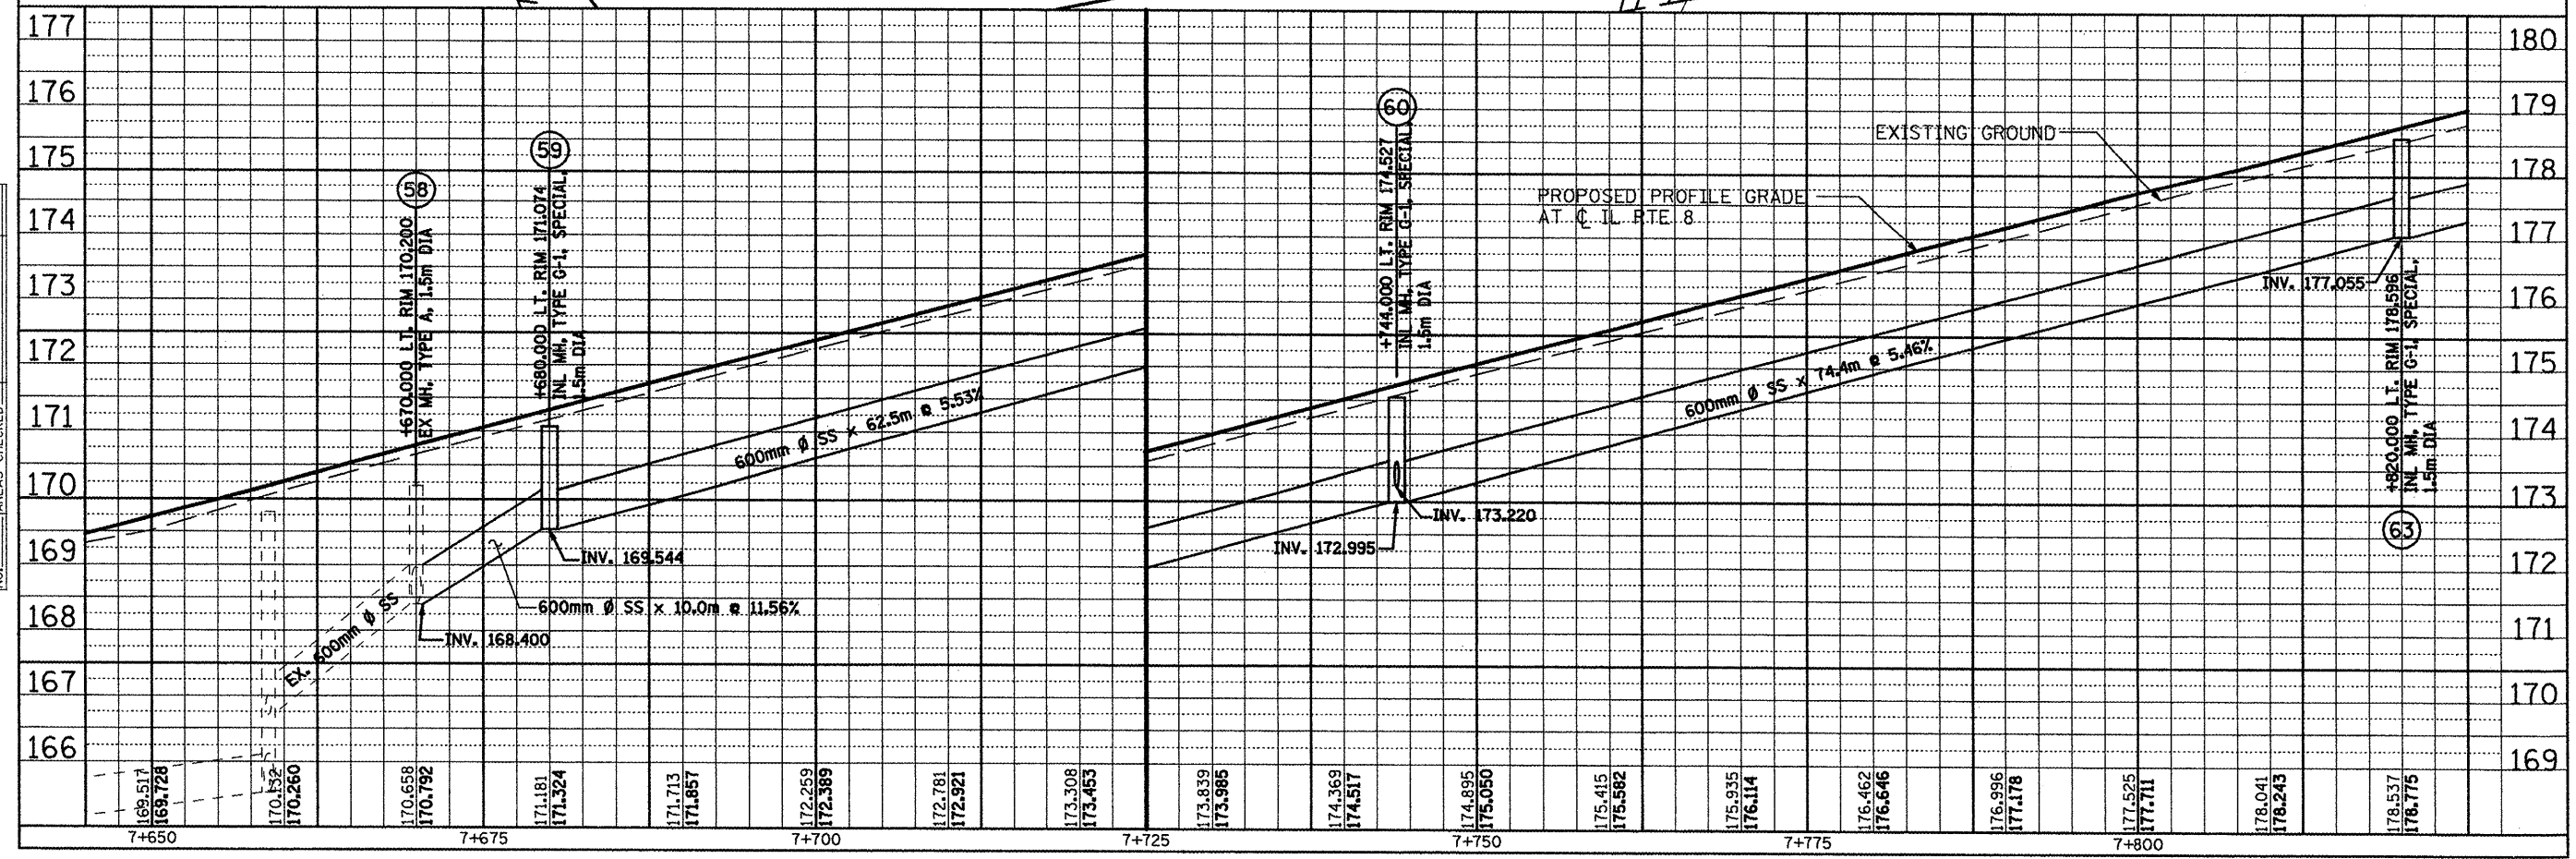

SCALE: H: 1:250, V: 1:50 DRAINAGE & UTILITIES PLAN AND PROFILE