

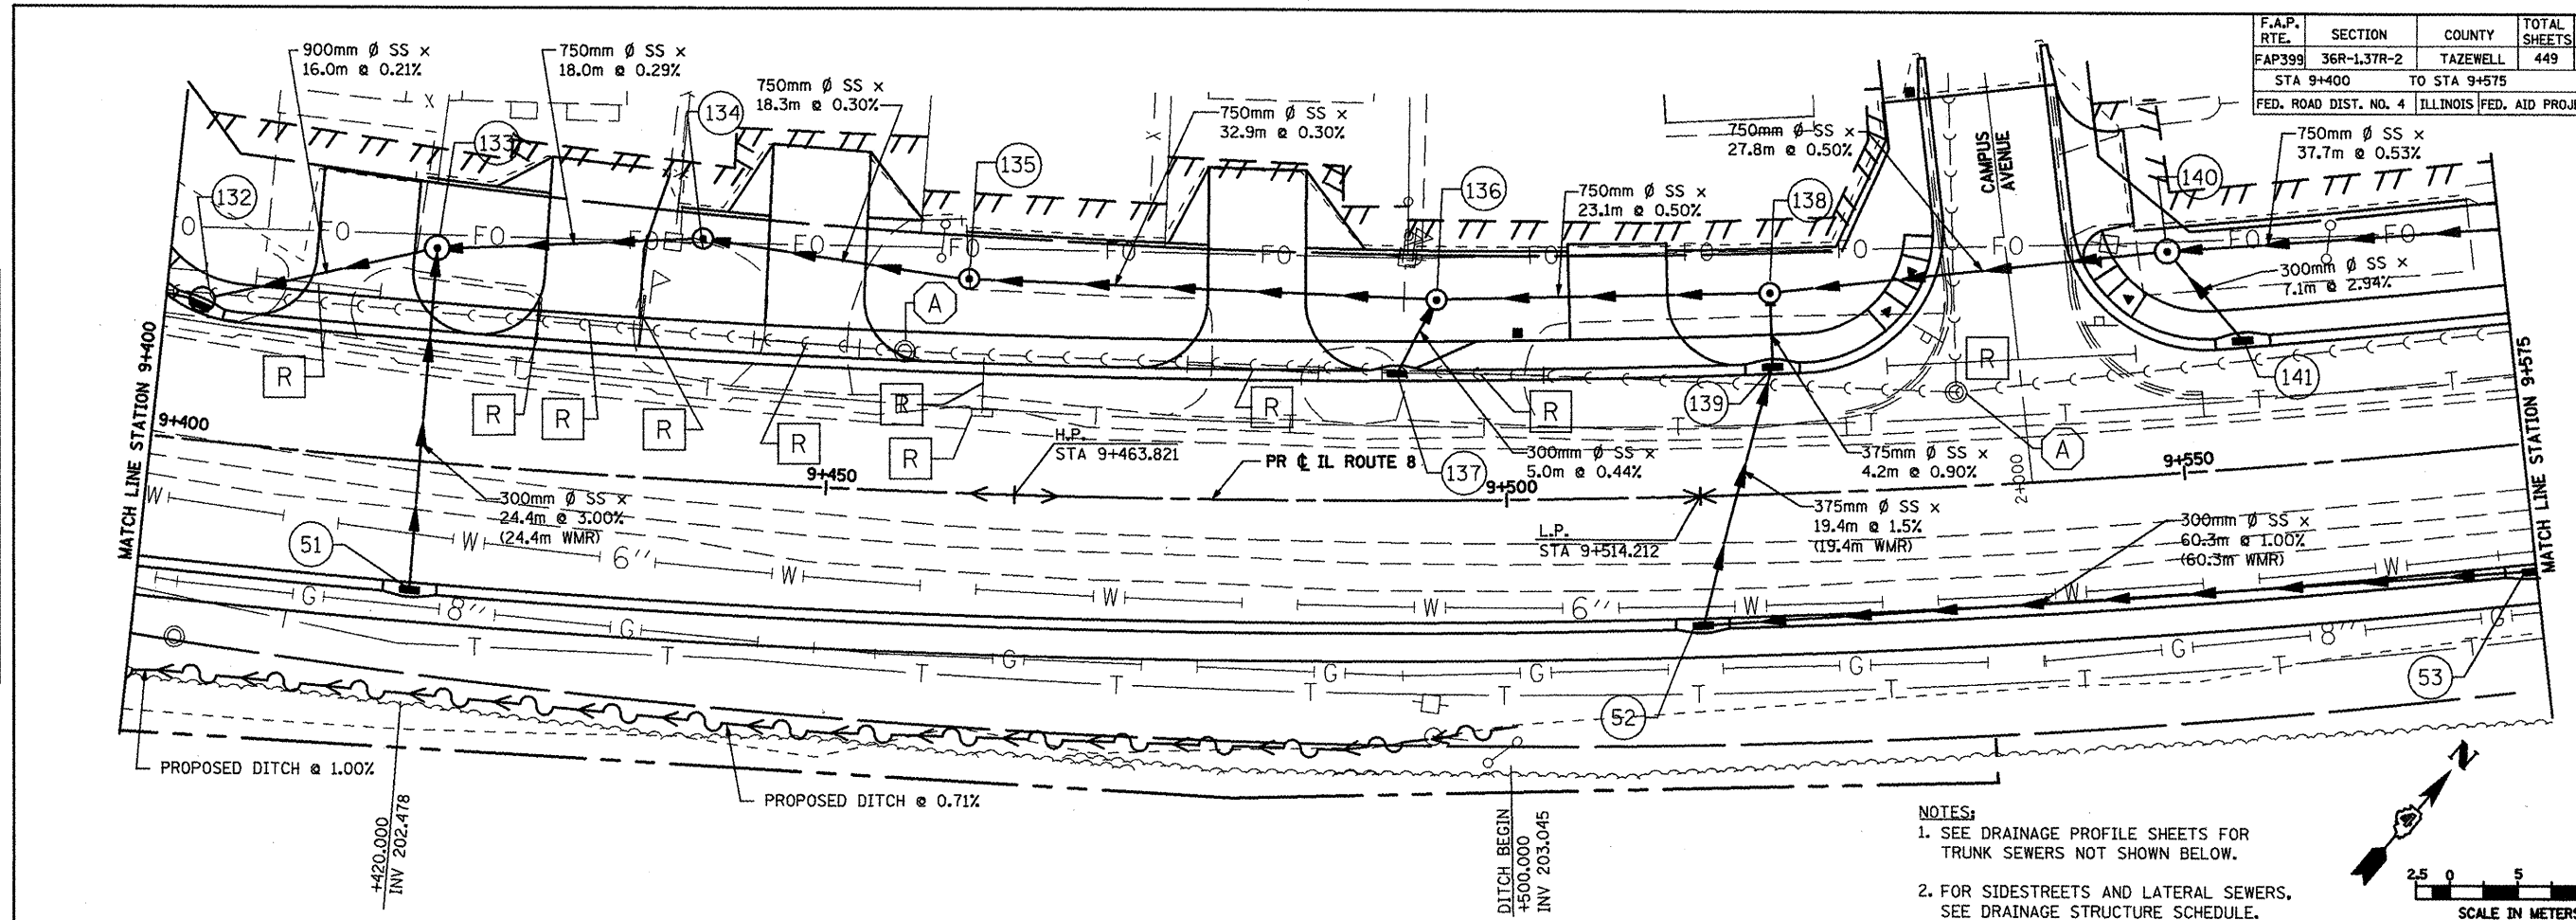


F.A.P. RTE.	SECTION	COUNTY	TOTAL SHEETS	SHEET NO.
FAP399	36R-1.37R-2	TAZEWELL	449	134
STA 9+400 TO STA 9+575				
FED. ROAD DIST. NO. 4 ILLINOIS FED. AID PROJECT				

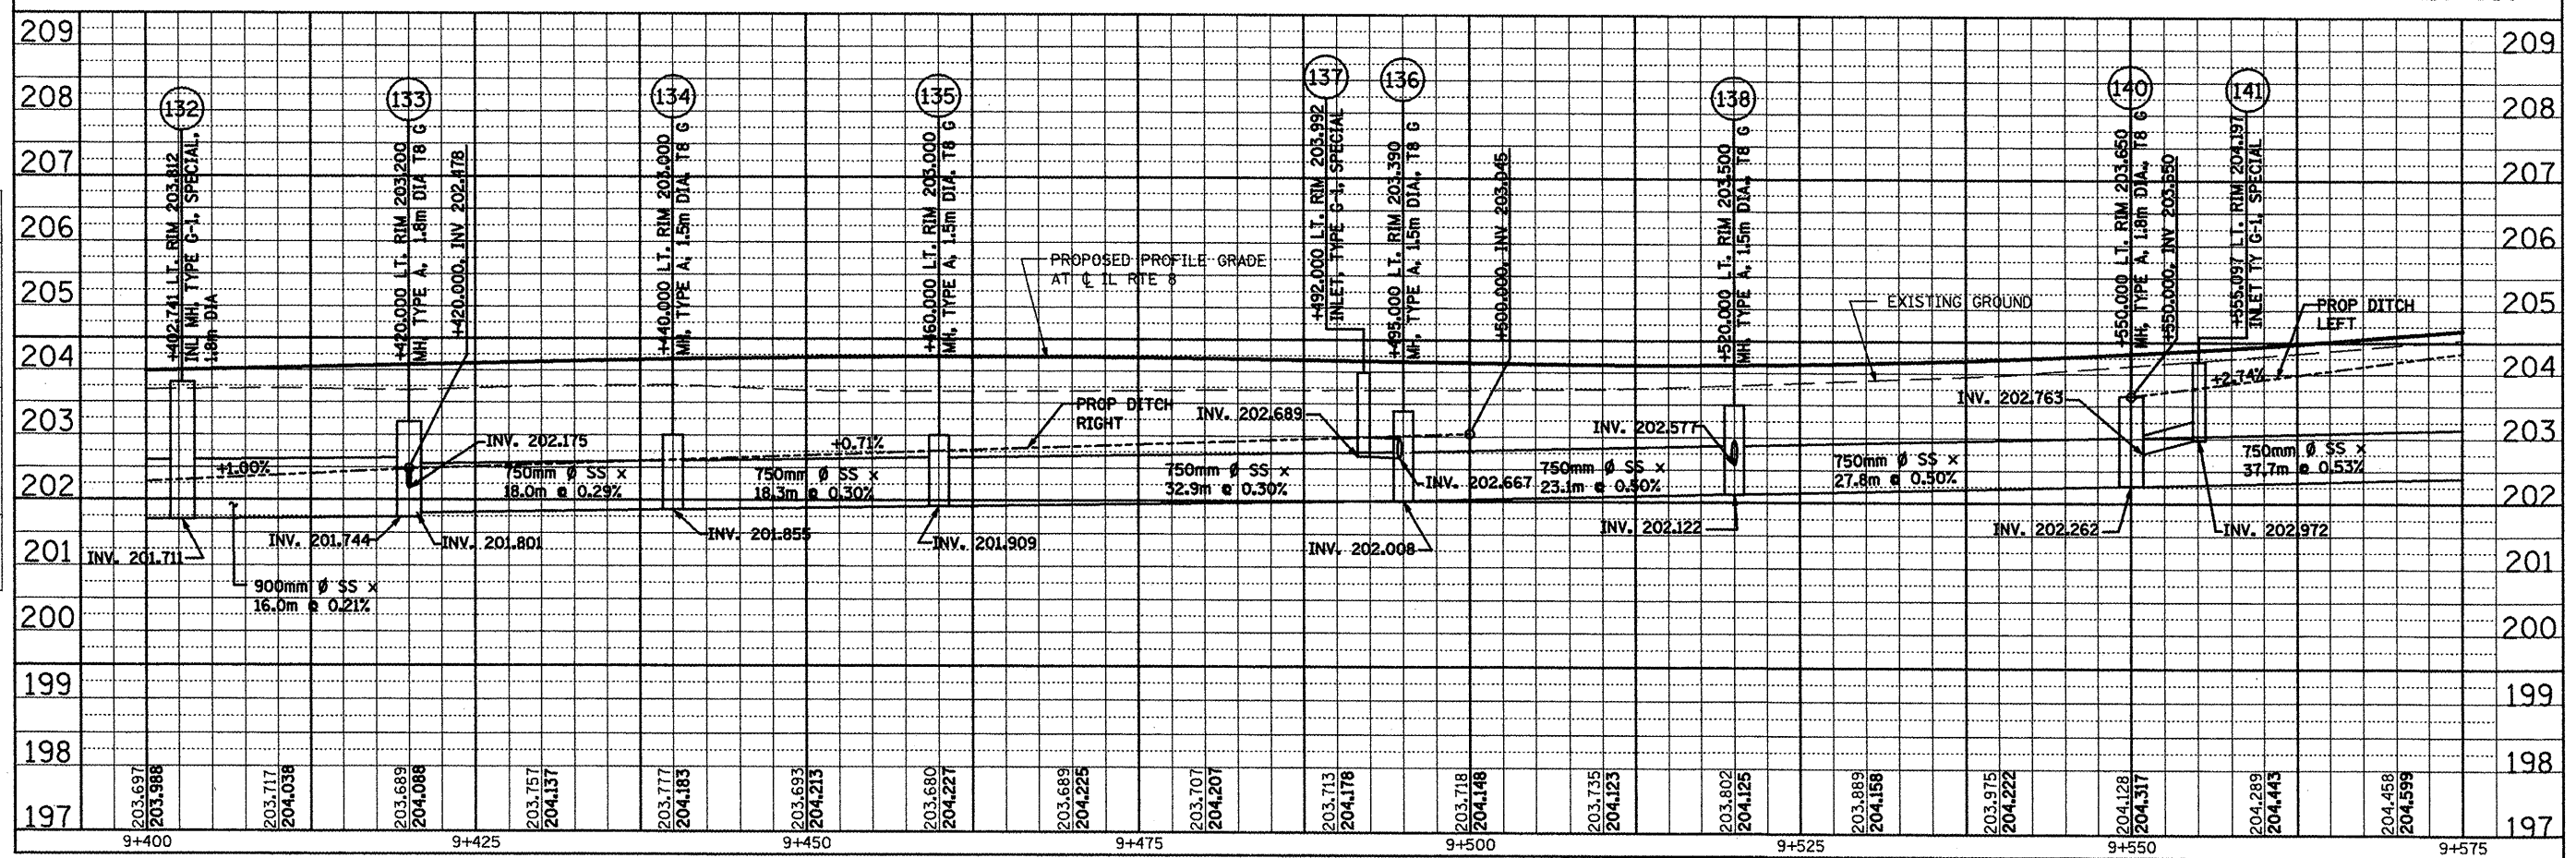

- NOTES:
- SEE DRAINAGE PROFILE SHEETS FOR TRUNK SEWERS NOT SHOWN BELOW.
 - FOR SIDESTREETS AND LATERAL SEWERS, SEE DRAINAGE STRUCTURE SCHEDULE.

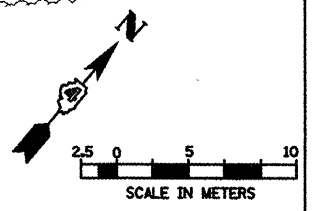

SCALE: H: 1:250, V: 1:50 DRAINAGE & UTILITIES PLAN AND PROFILE

DATE	
BY	
FINAL SURVEY PLOTTED	
NOTE BOOK TEMPLATE	
AREAS CHECKED	
NO.	

DATE	
BY	
ORIGINAL SURVEY PLOTTED	
NOTE BOOK TEMPLATE	
AREAS CHECKED	
NO.	