


DATE	
BY	
REVIEWED	
PLANNED	
NOTED	
NO.	
NO.	
NO.	
NO.	

DATE	
BY	
REVIEWED	
PLANNED	
NOTED	
NO.	
NO.	
NO.	
NO.	

MATCHLINE STA. 204+50.00  
SEE ILLINOIS ROUTE 8 DRAINAGE PLANS LT SIDE  
SHEET 2 OF 3

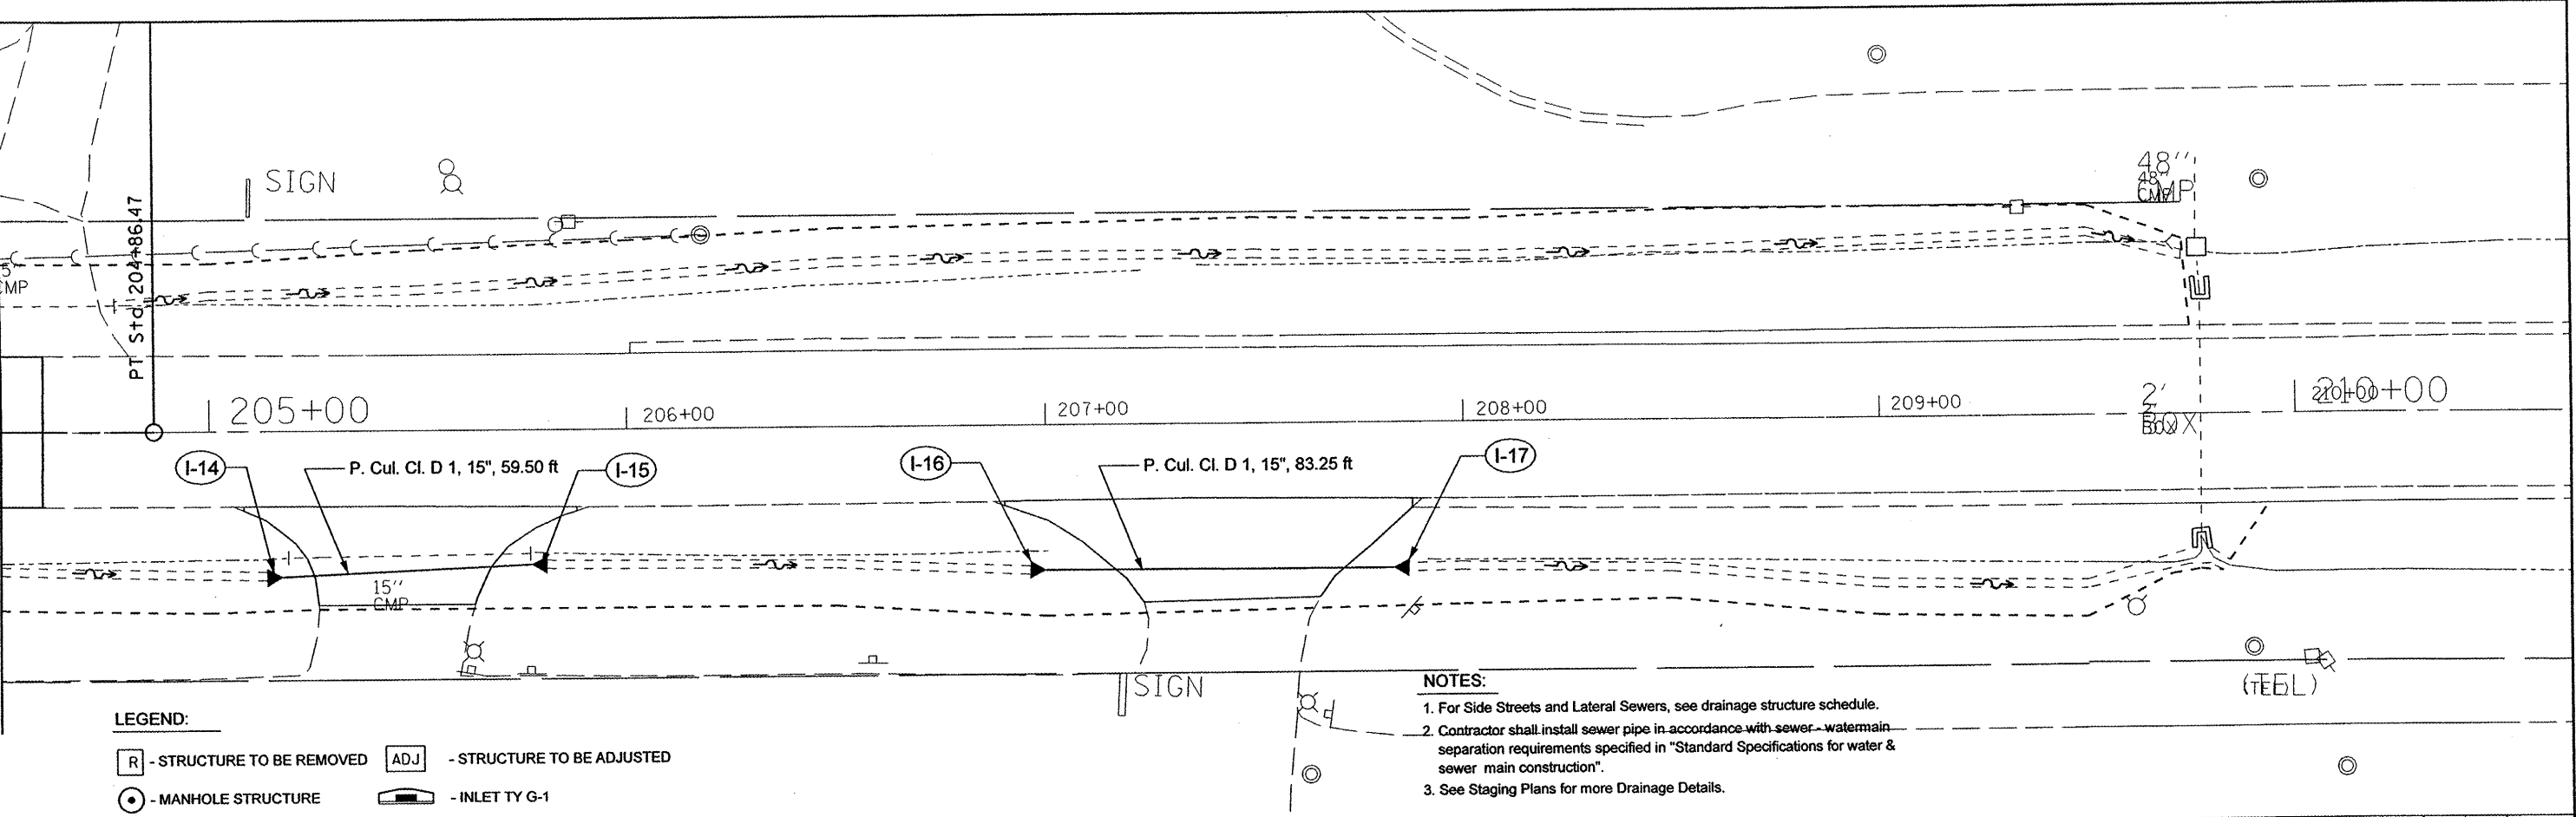


**LEGEND:**

- [R] - STRUCTURE TO BE REMOVED
- [ADJ] - STRUCTURE TO BE ADJUSTED
- - MANHOLE STRUCTURE
- [INLET] - INLET TY G-1

**NOTES:**

1. For Side Streets and Lateral Sewers, see drainage structure schedule.
2. Contractor shall install sewer pipe in accordance with sewer-watermain separation requirements specified in "Standard Specifications for water & sewer main construction".
3. See Staging Plans for more Drainage Details.

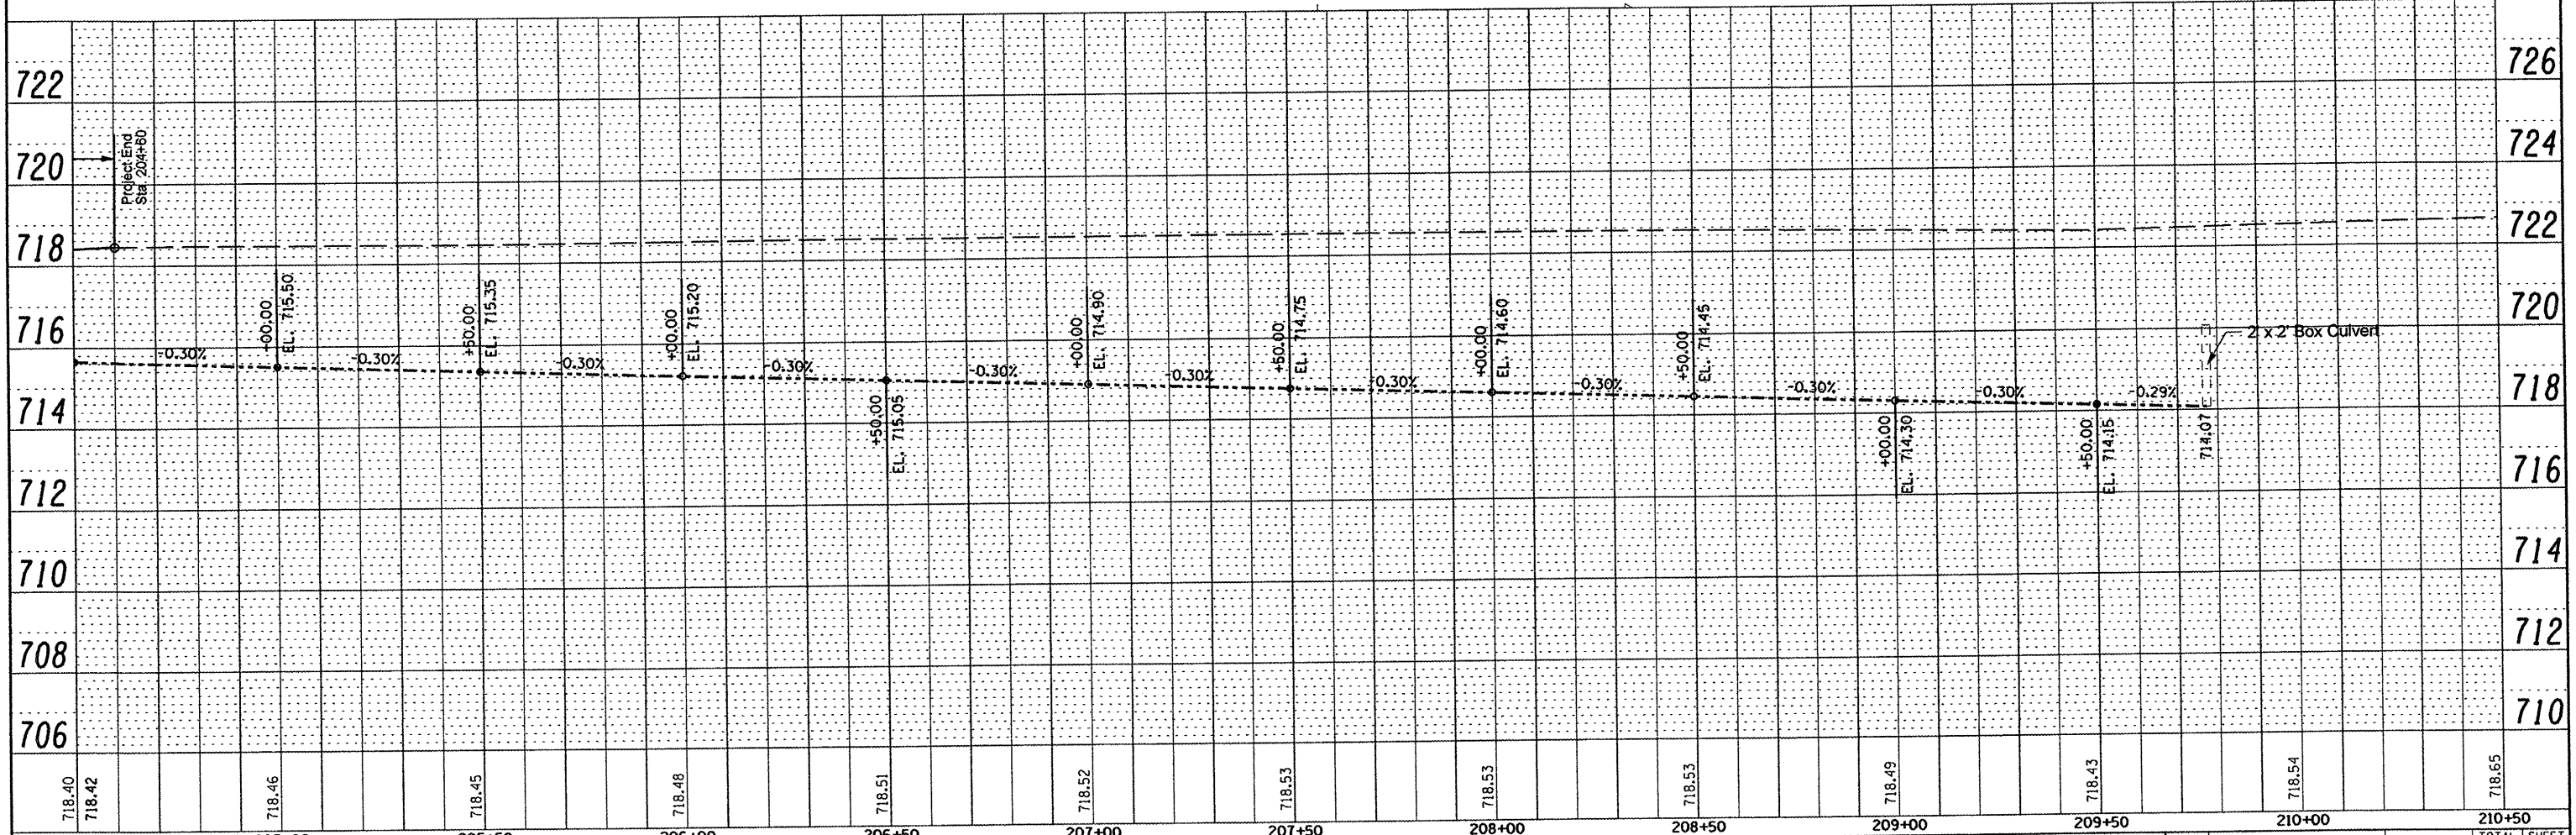

FILE NAME =	USER NAME = *USER*	DESIGNED - ENE	REVISED -	<b>STATE OF ILLINOIS DEPARTMENT OF TRANSPORTATION</b>	<b>ILLINOIS ROUTE 8 DRAINAGE PLANS LT SIDE</b>	SECTION	COUNTY	TOTAL SHEETS	SHEET NO.	
#FILE#		DRAWN - LEC	REVISED -			04-00141-00-FP	TAZEWELL	187	75	
		CHECKED - ENE	REVISED -							
		DATE	REVISED -							
						CONTRACT NO. 89352				
					SCALE: 1" = 20'-0"		SHEET NO. 3 OF 3 SHEETS		STA. 204+50.00 TO STA. 210+50.00	
					FED. ROAD DIST. NO.		ILLINOIS FED. AID PROJECT			