



TYPICAL SPLICE DETAIL

N.T.S.

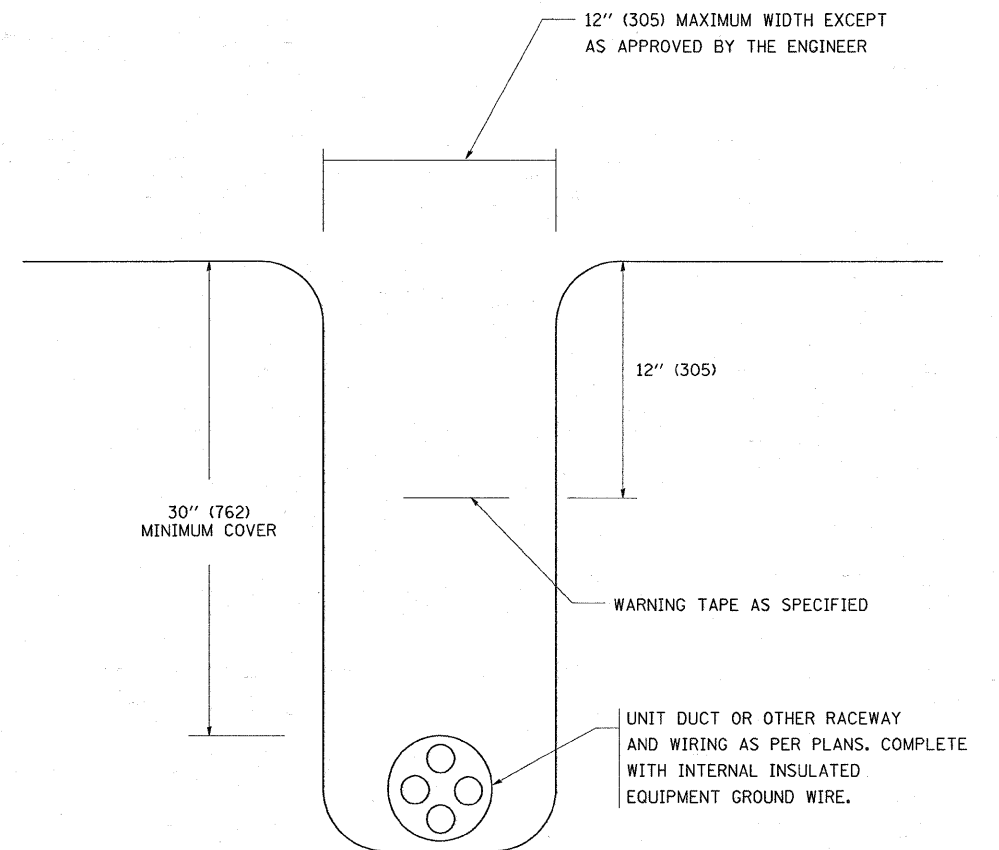

TYPICAL WIRING IN TRENCH DETAIL

N.T.S.

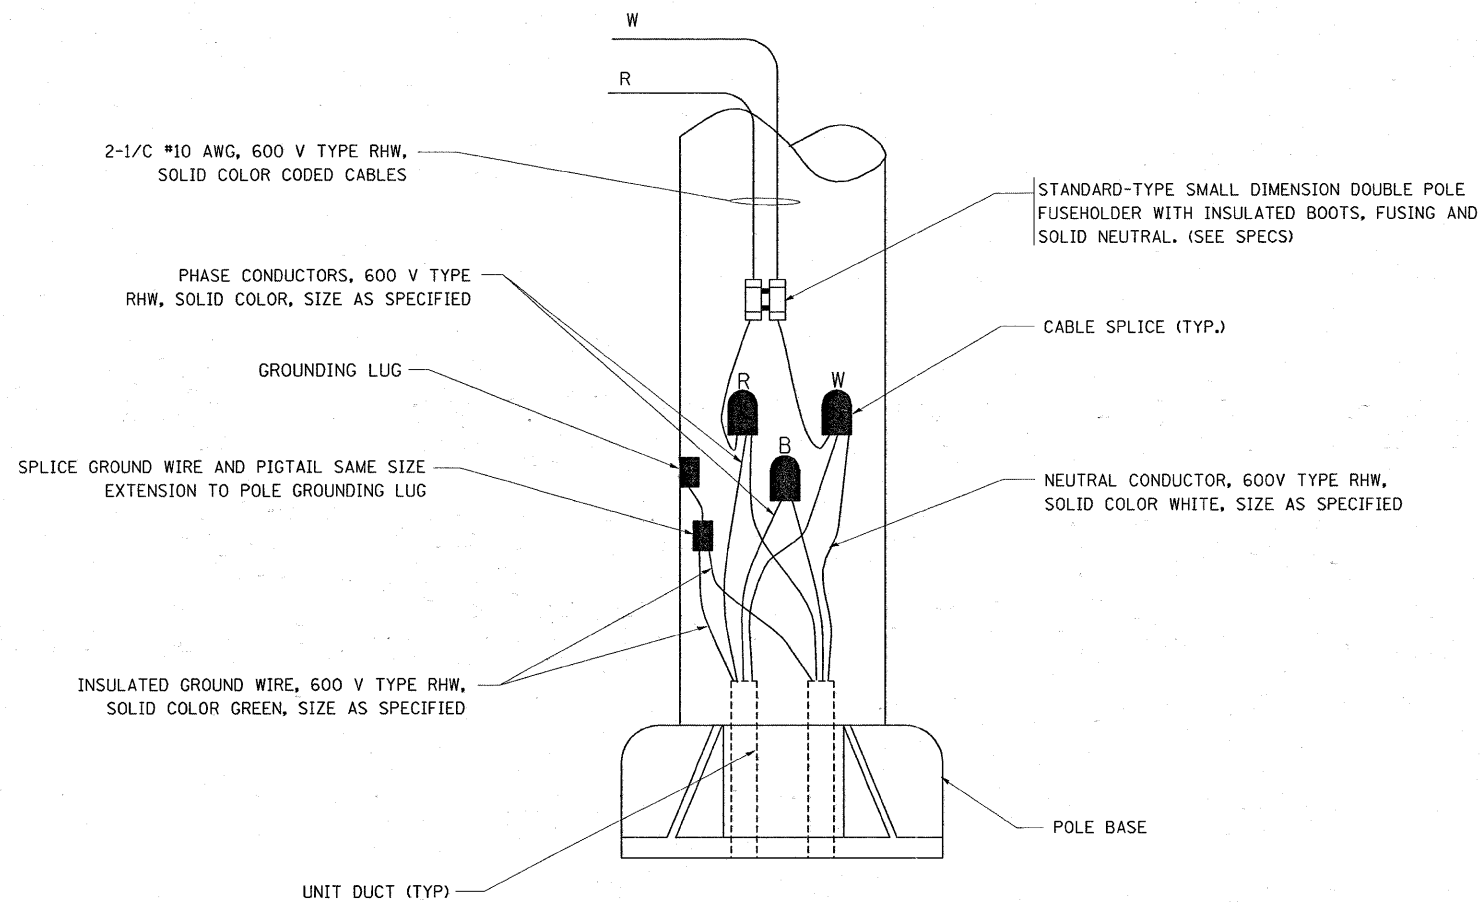

POLE WIRING DETAIL

N.T.S.

FILE NAME =	USER NAME = abrauh	DESIGNED -	REVISED - 08-08-03	STATE OF ILLINOIS DEPARTMENT OF TRANSPORTATION	MISC. ELECTRICAL DETAILS SHEET A		F.A.P. RTE.	SECTION	COUNTY	TOTAL SHEETS	SHEET NO.
c:\pwork\PWIDOT\ABREUAH\dms93682\01sStd.dgn		DRAWN -	REVISED -		347	2Y-N	DUPAGE	40	27		
PLOT SCALE = 50,0000' / IN.		CHECKED -	REVISED -		BE-702		CONTRACT NO. 60E65				
PLOT DATE = 3/20/2009		DATE -	REVISED -		SCALE: NONE	SHEET NO. 1 OF 1 SHEETS	STA.	TO STA.	FED. ROAD DIST. NO. 1 ILLINOIS FED. AID PROJECT		