


DATE	BY	REVISIONS	DATE	BY	REVISIONS
PROFILE	DATE	BY	DATE	BY	REVISIONS
NOTE BOOK	NO.				

CHRISTOPHER B. BURKE ENGINEERING LTD.
9575 West Higgins Road, Suite 600
Rosemont, Illinois 60018
(617) 823-0500

N:\scor\10300040\Task FF-IH IL 19 Set\plg\LIT_Westview&Barrington.dgn

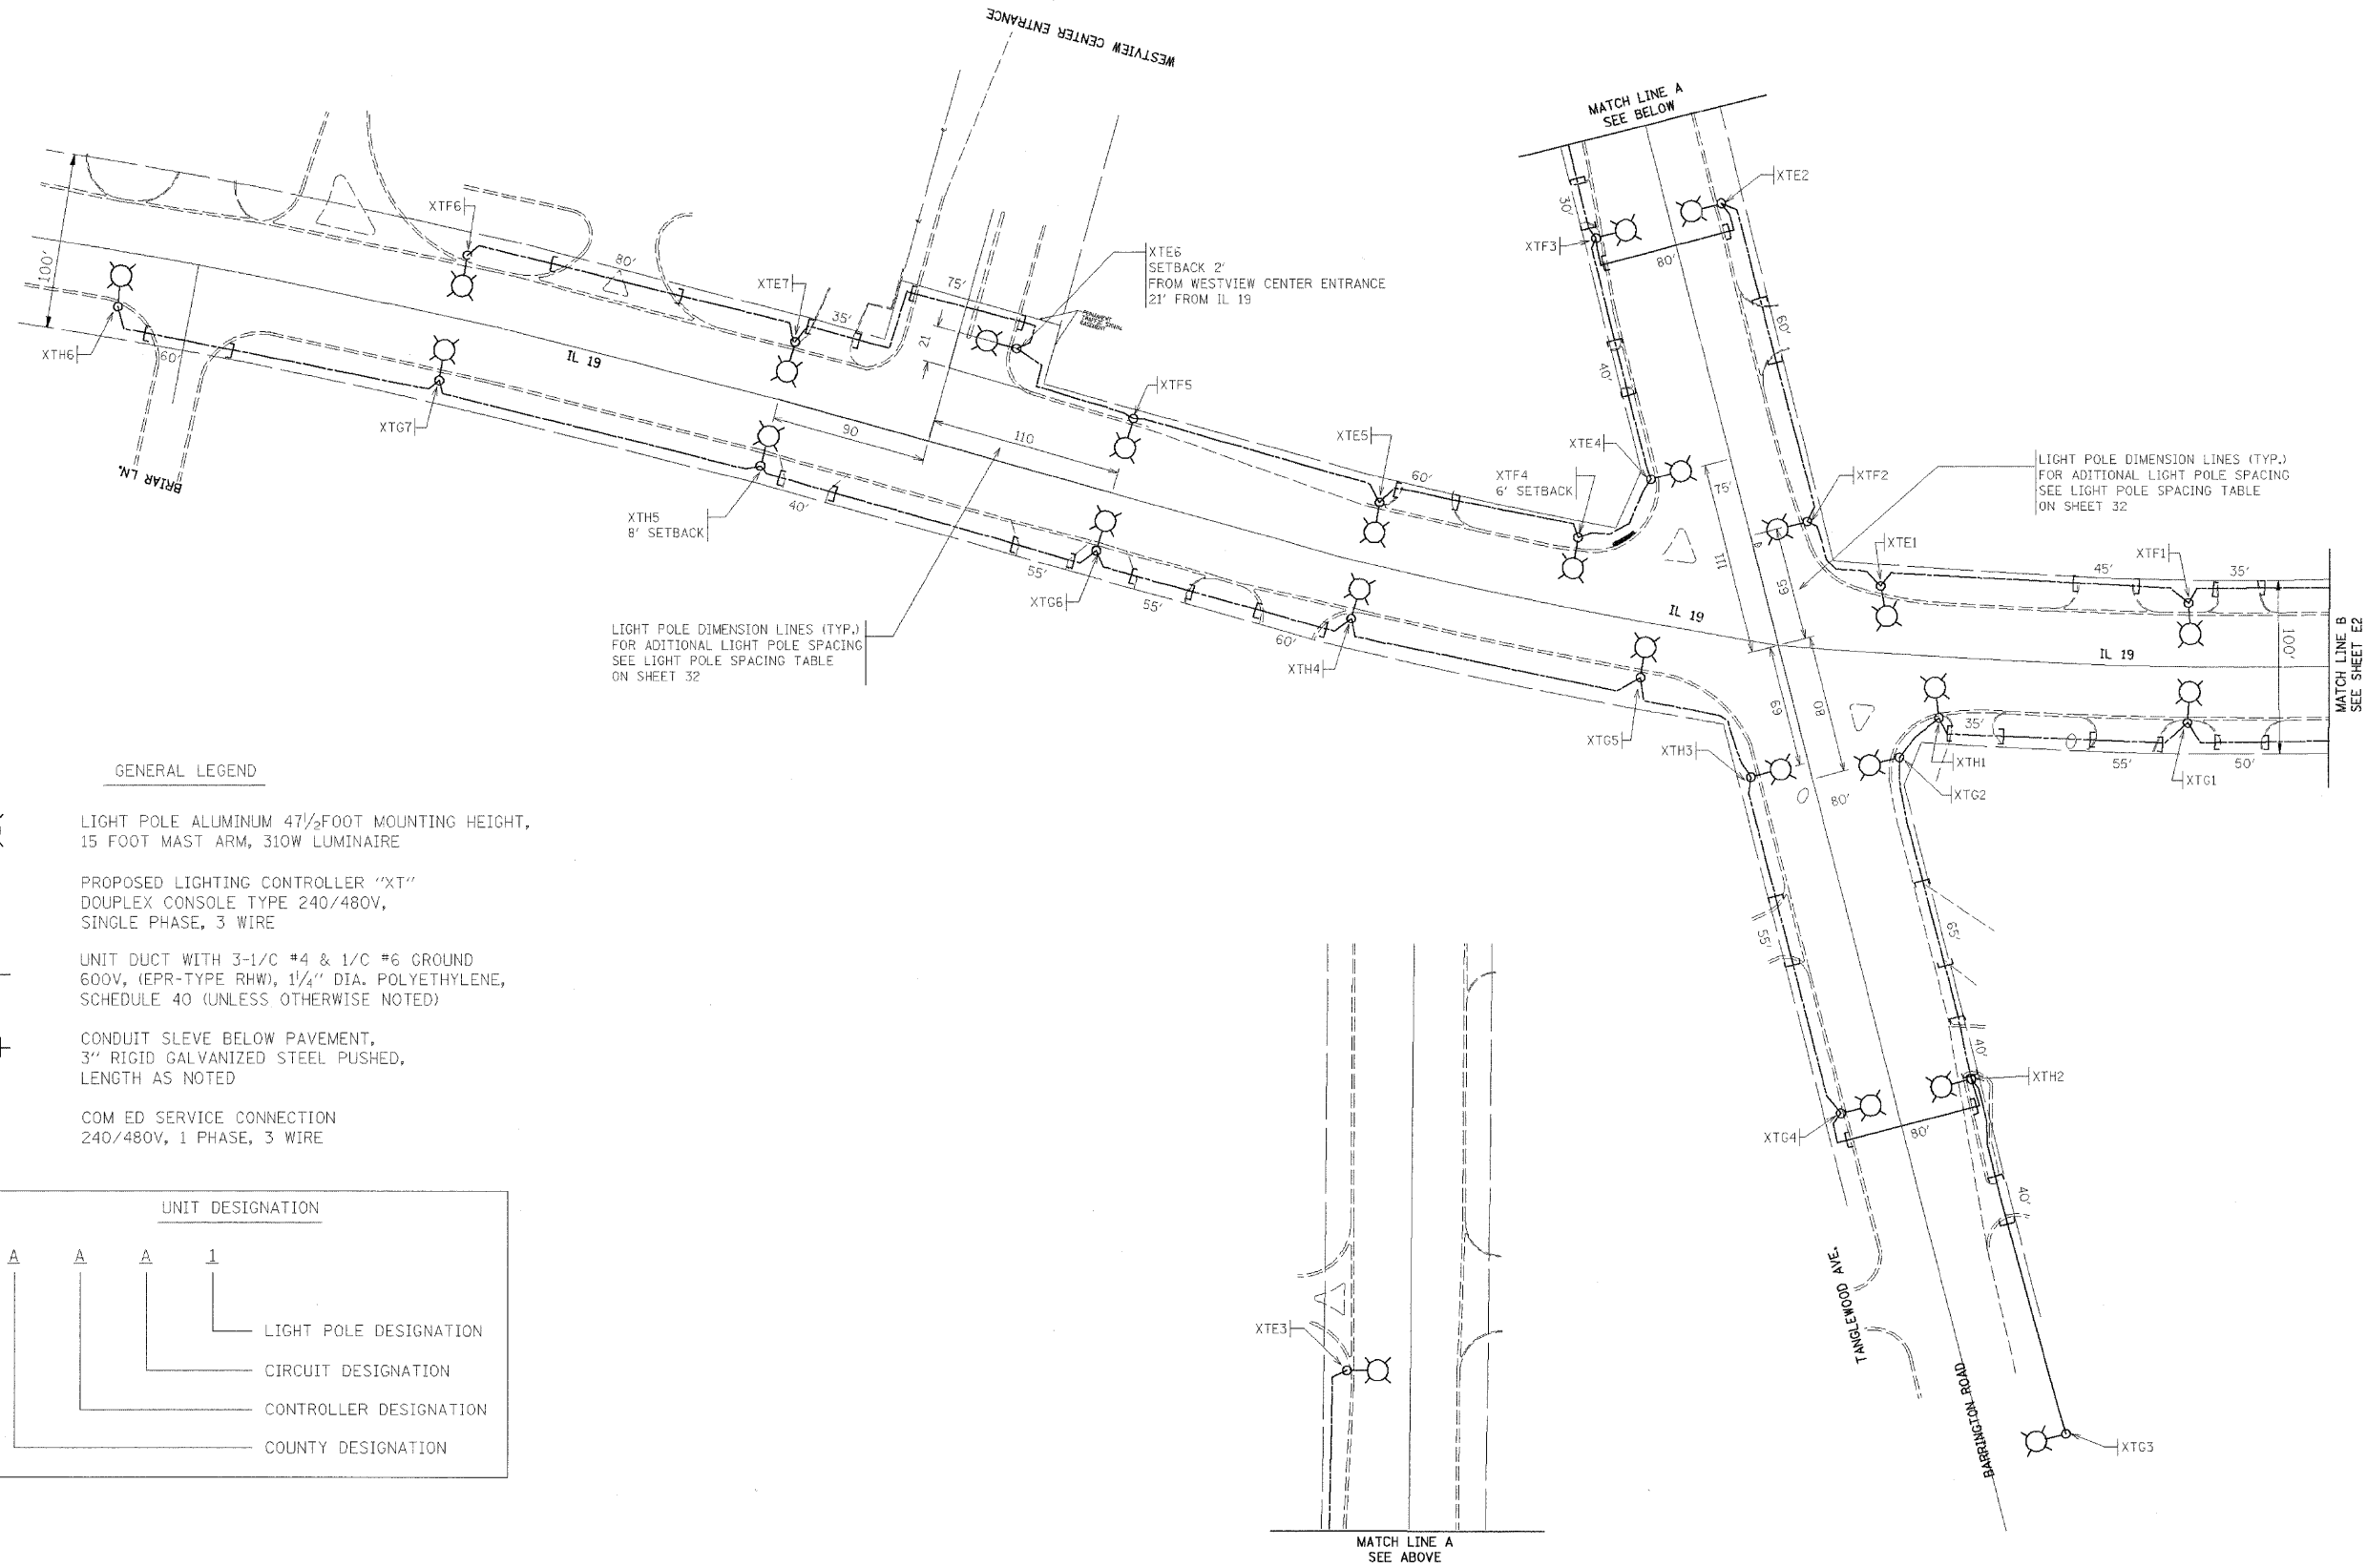

FILE NAME = ...LIT_Westview&Barrington.dgn	USER NAME = FPACIONE	DESIGNED - ABR	REVISID -	STATE OF ILLINOIS DEPARTMENT OF TRANSPORTATION	PROPOSED ROADWAY LIGHTING PLANS IL. ROUTE 19 (IRVING PARK ROAD) AT WESTVIEW CENTER TO BARRINGTON ROAD HANOVERT PARK, ILLINOIS	F.A.U. RTE.	SECTION	COUNTY	TOTAL SHEETS	SHEET NO.	
PLOT SCALE = 50'	DRAWN - FPB / FCP	CHECKED - MJT	REVISID -			1321	2009-034 TS	COOK	45	33	
PLOT DATE = 3/18/2009	DATE -	REVISID -	REVISID -			CONTRACT NO. 60G39					
SCALE: 1" = 50'						SHEET NO. OF SHEETS STA. TO STA.				FED. ROAD DIST. NO. ILLINOIS FED. AID PROJECT	