


PROFILE	DATE	BY
NOTE BOOK		
NO.		
SURVEYED	DATE	BY
GRADES CHECKED		
PLAN	DATE	BY
NOTE BOOK		
NO.		
SURVEYED	DATE	BY
ALTIMETER CHECKED		
PLAN	DATE	BY
NOTE BOOK		
NO.		
SURVEYED	DATE	BY
ALTIMETER CHECKED		
PLAN	DATE	BY
NOTE BOOK		
NO.		

CHRISTOPHER B. BURKE ENGINEERING LTD.
 9575 West Higgins Road, Suite 600
 Rosemont, Illinois 60018
 (617) 823-0500

NA:\data\20090408\Task FF-HH IL 19 Safety\TheTraffic\IL19Barrington&Kingsbury.dgn

PROPOSED LIGHTING CONTROLLER "XT"
 DUPLEX CONSOLE TYPE 240/480V
 SINGLE PHASE, 3 WIRE

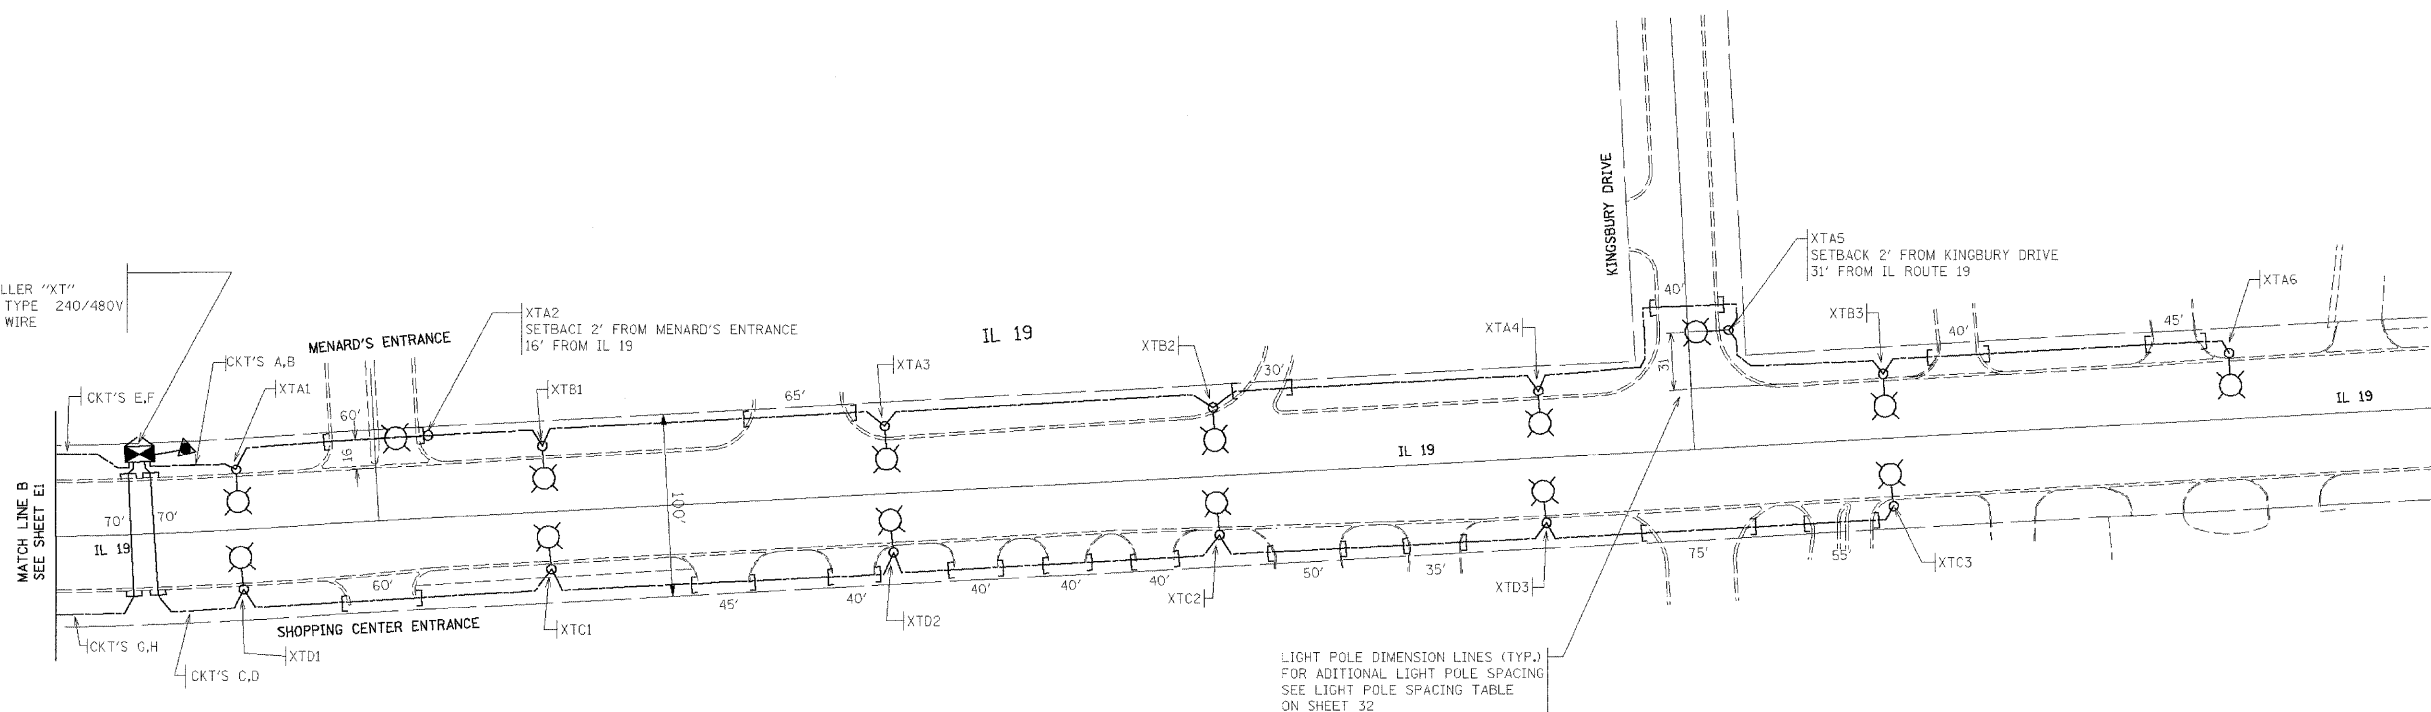


LIGHT POLE DIMENSION LINES (TYP.)
 FOR ADDITIONAL LIGHT POLE SPACING
 SEE LIGHT POLE SPACING TABLE
 ON SHEET 32

GENERAL LEGEND

- LIGHT POLE ALUMINUM 47 1/2 FOOT MOUNTING HEIGHT, 15 FOOT MAST ARM, 31CW LUMINAIRE
- PROPOSED LIGHTING CONTROLLER "XT"
 DUPLEX CONSOLE TYPE 240/480V,
 SINGLE PHASE, 3 WIRE
- UNIT DUCT WITH 3-1/2 #4 & 1/2 #6 GROUND
 600V, (EPR-TYPE RHW), 1 1/4" DIA. POLYETHYLENE,
 SCHEDULE 40 (UNLESS OTHERWISE NOTED)
- CONDUIT SLEVE BELOW PAVEMENT,
 3" RIGID GALVANIZED STEEL PUSHED,
 LENGTH AS NOTED
- COM ED SERVICE CONNECTION
 240/480V, 1 PHASE, 3 WIRE

UNIT DESIGNATION

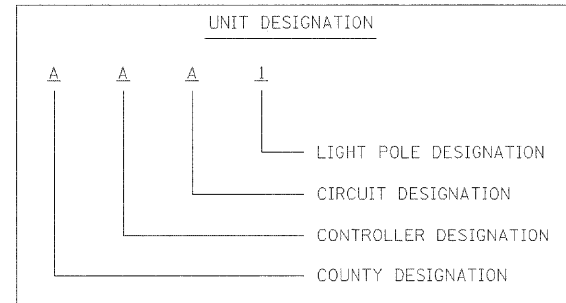

FILE NAME =	USER NAME = FPAIONE	DESIGNED - ABR	REVISED -	STATE OF ILLINOIS DEPARTMENT OF TRANSPORTATION	PROPOSED ROADWAY LIGHTING PLANS IL. ROUTE 19 (IRVING PARK ROAD) EAST OF BARRINGTON ROAD TO KINGSBURY DRIVE HANOVER PARK, ILLINOIS		F.A.U. RTE.	SECTION	COUNTY	TOTAL SHEETS	SHEET NO.
...\\LIT_Barrington&Kingsbury.dgn		DRAWN - FPB / FCP	REVISED -		1321	2009-034 TS	COOK	45	34		
PLOT SCALE = 50'		CHECKED - MJT	REVISED -		CONTRACT NO. 60G39						
PLOT DATE = 3/18/2009		DATE -	REVISED -		SCALE: 1" = 50'	SHEET NO. OF SHEETS	STA. TO STA.	FED. ROAD DIST. NO.	ILLINOIS FED. AID PROJECT		