
 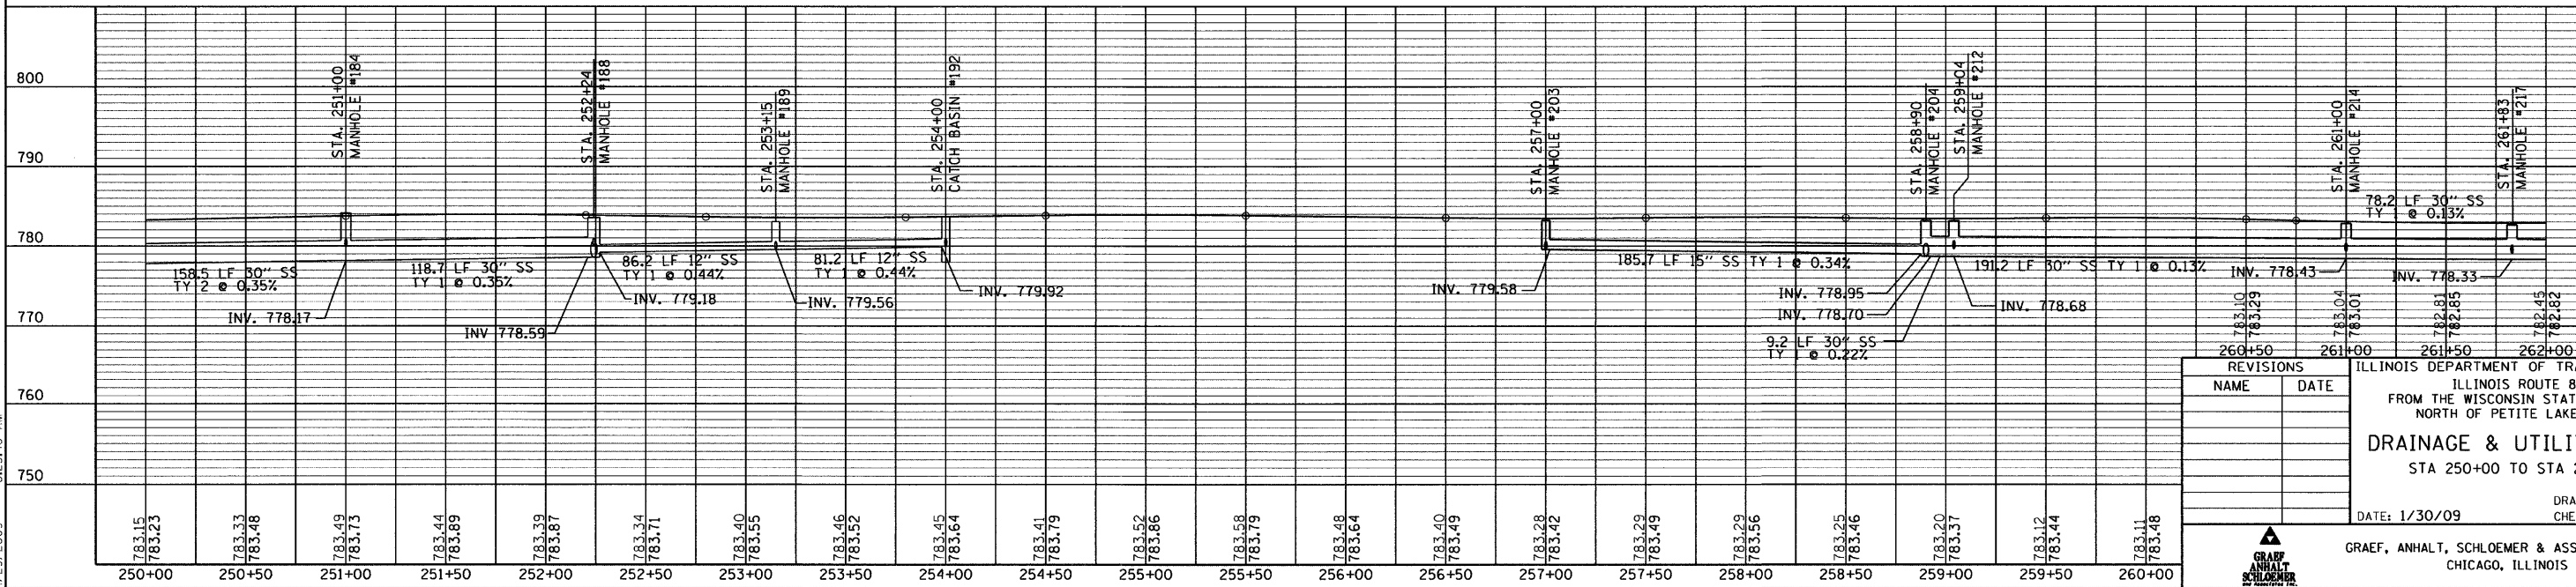

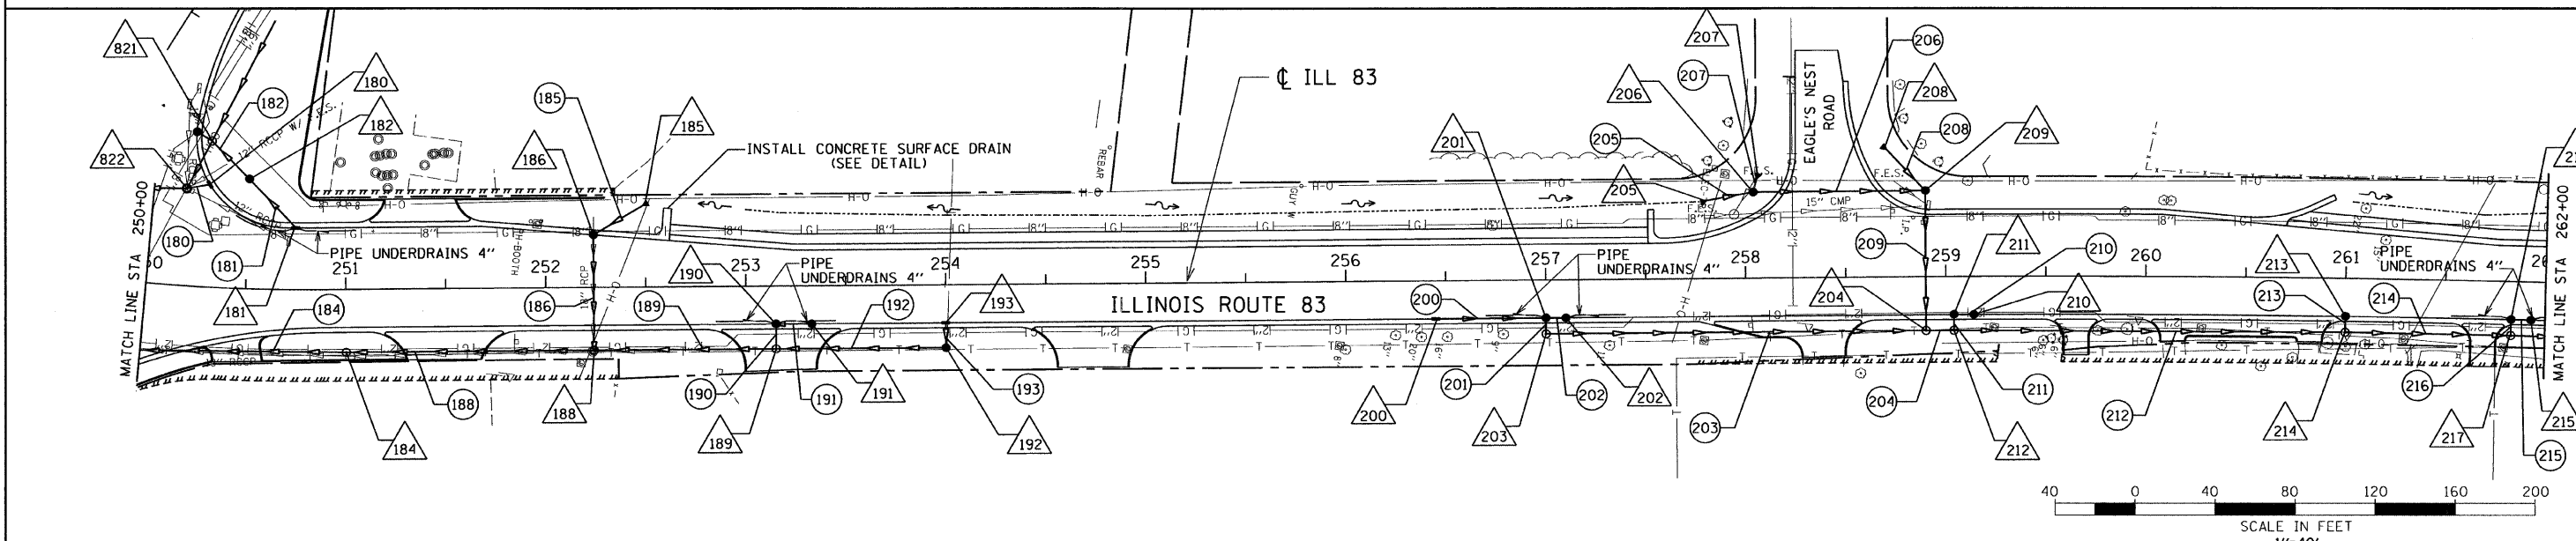


CONTRACT NO. 62700

|                     |          |                  |              |           |
|---------------------|----------|------------------|--------------|-----------|
| F.A. ROUTE NO.      | SECTION  | COUNTY           | TOTAL SHEETS | SHEET NO. |
| 866                 | *        | LAKE             | 554          | 139       |
| FED. ROAD DIST. NO. | ILLINOIS | FED. AID PROJECT |              |           |

\*(L-2(W,R);6,6A & 6 EXT) WRS-1

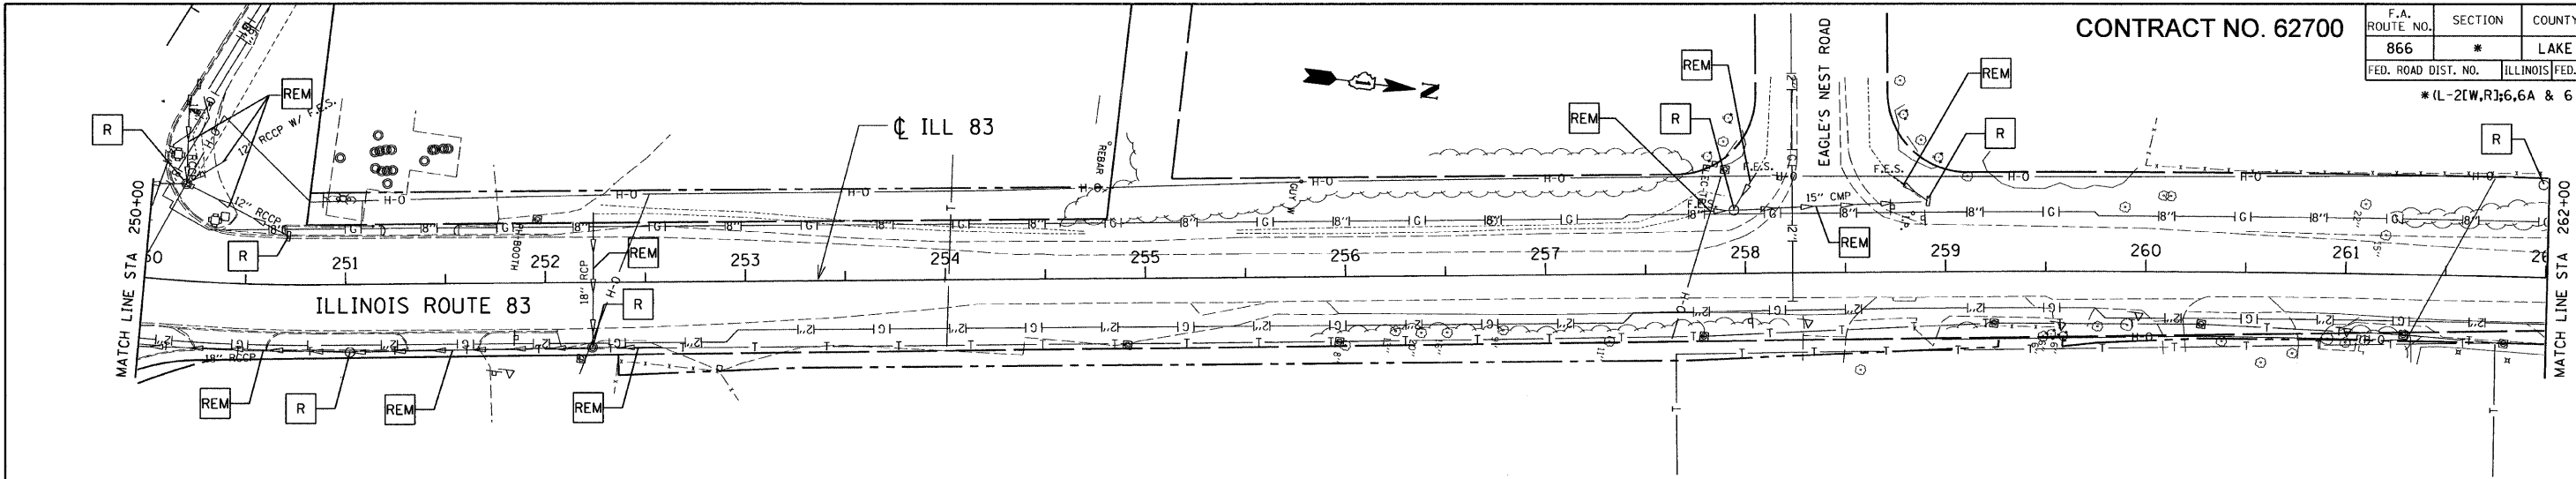

| REVISIONS |      |
|-----------|------|
| NAME      | DATE |
|           |      |
|           |      |

ILLINOIS DEPARTMENT OF TRANSPORTATION  
ILLINOIS ROUTE 83  
FROM THE WISCONSIN STATE LINE TO  
NORTH OF PETITE LAKE ROAD

### DRAINAGE & UTILITY PLAN

STA 250+00 TO STA 262+00

DATE: 1/30/09  
DRAWN BY: WS  
CHECKED BY: MW

GRAEF, ANHALT, SCHLOEMER & ASSOCIATES, INC.  
CHICAGO, ILLINOIS

G:\20040424.N\mns\dicnse+140\dj\m09.dgn 4/29/2009 8:25:40 AM