


F.A.I. RTE.	SECTION	COUNTY	TOTAL SHEETS	SHEET NO.
90/94		COOK	28	20
STA. 606+25		TO STA. 611+25		
FED. ROAD DIST. NO. 1 ILLINOIS FED. AID PROJECT				
• (2021-922 PT1 & 2122-921 PT1) I-2 62987				

NOTES:

- EXISTING WOOD POST TO BE REMOVED. EXISTING FLASHING BEACONS AND WARNING SIGN TO BE REMOVED FROM WOOD POST AND BE INSTALLED ON NEW STEEL POLE.
- EXISTING 3/C #12 TO BE PULLED BACK TO EXISTING SURVEILLANCE CABINET 37 AND REMOVED.

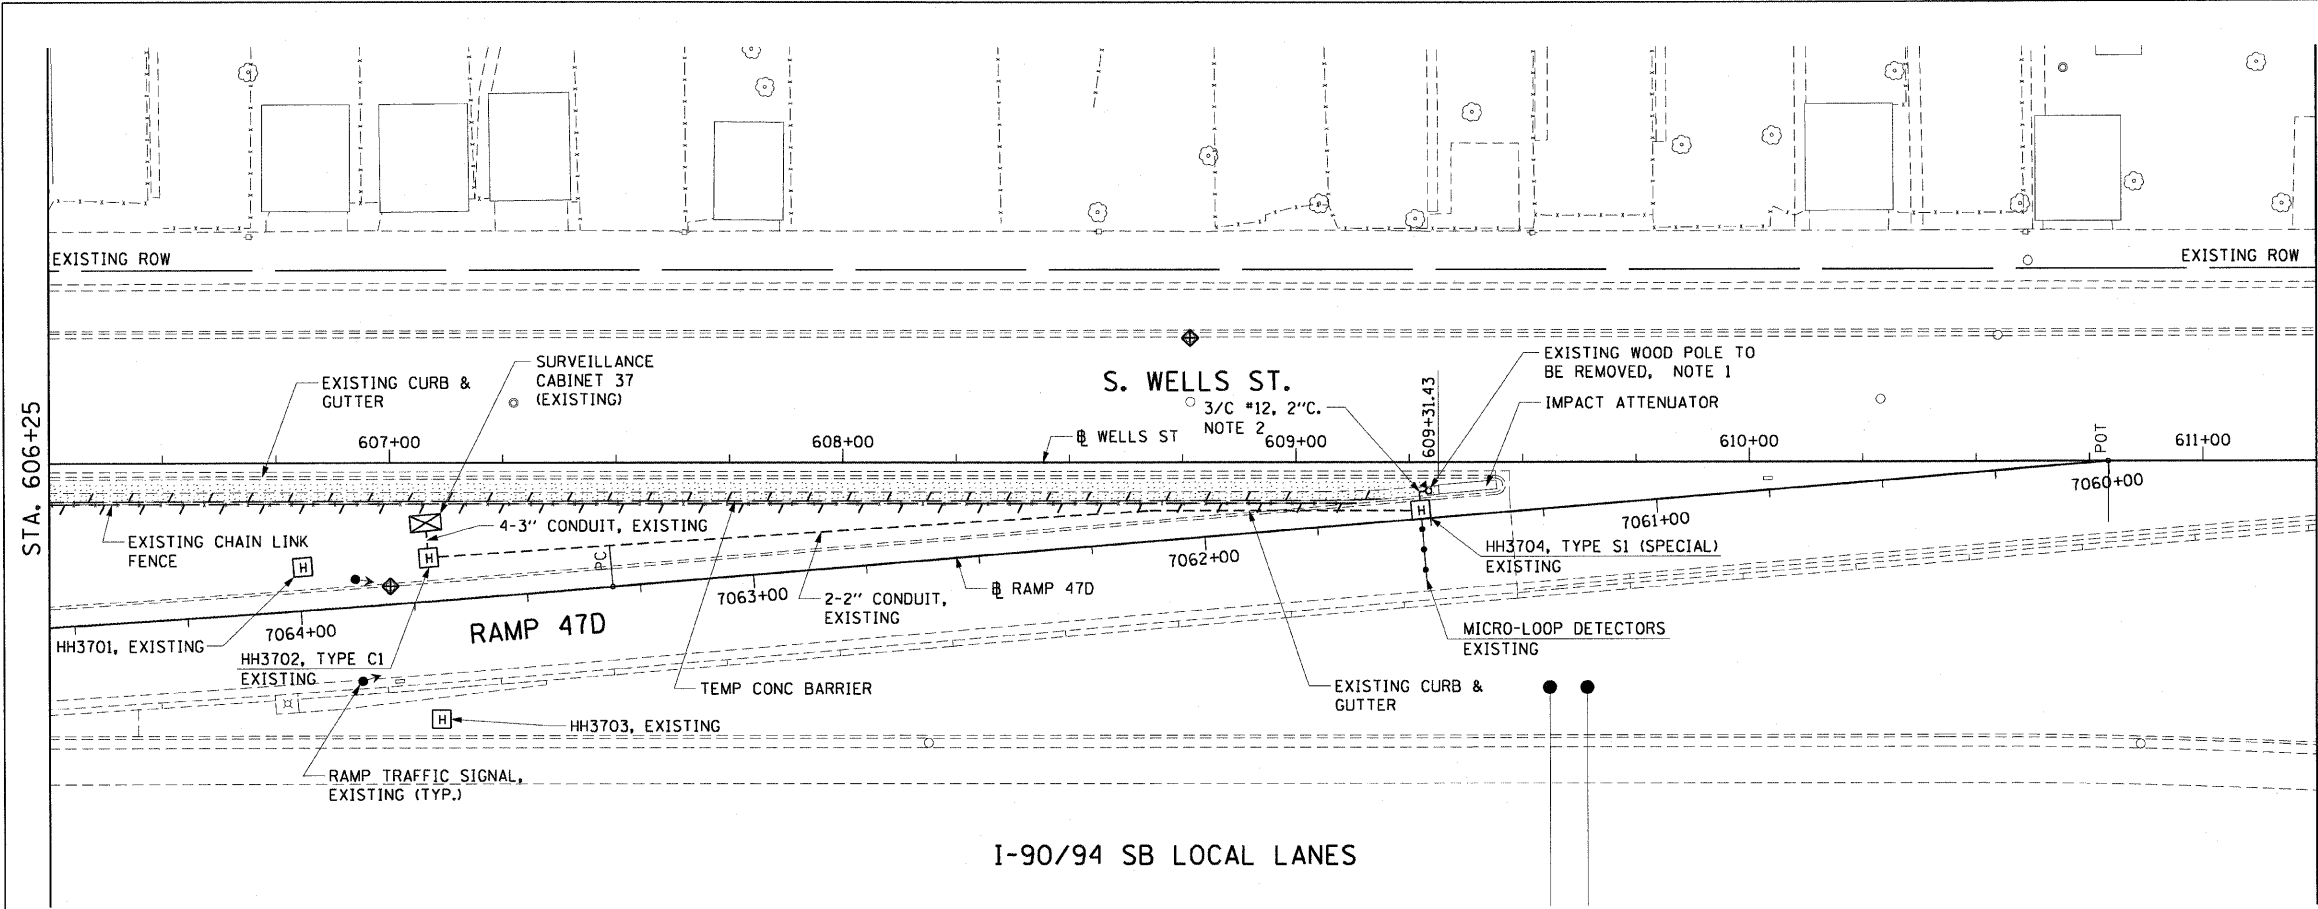

 

**EXISTING CONDITIONS AND REMOVAL
PROPOSED IMPROVEMENTS**

NOTES:

- NEW STEEL POLE TO BE INSTALLED AT END OF NEW KNEE WALL. EXISTING FLASHING BEACONS AND WARNING SIGN REMOVED FROM WOOD POST ARE TO BE INSTALLED ON NEW STEEL POLE. SEE DRAWING DT-35A FOR DETAILS.
- EXISTING 2\"/>

FOR INFORMATION ONLY

ALL ELECTRICAL WORK SHOWN ON THIS SHEET WILL BE DONE BY MEADE ELECTRIC UNDER CONTRACT 62583.

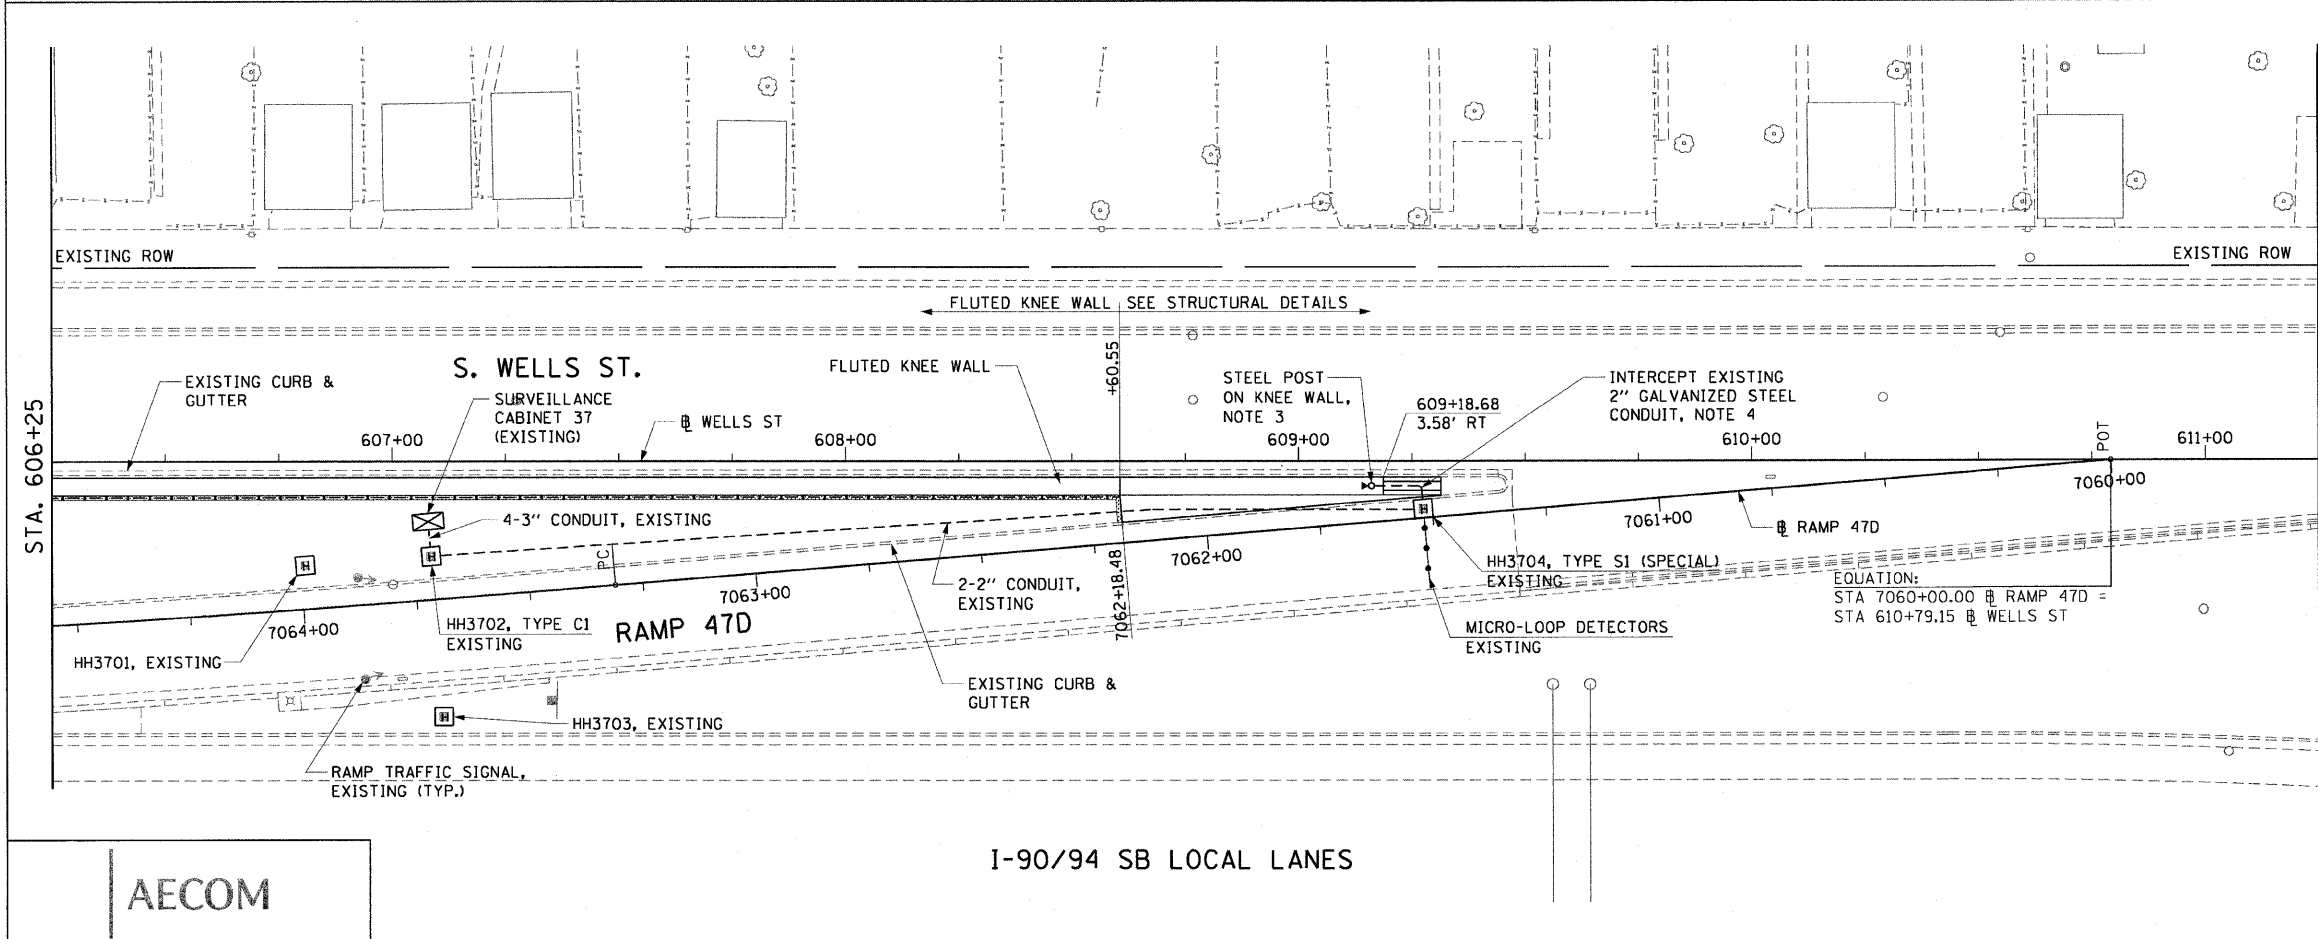

REVISIONS	
NAME	DATE

ILLINOIS DEPARTMENT OF TRANSPORTATION
F.A.I. 90/94 (DAN RYAN EXPRESSWAY)
59TH ST TO 47TH ST (SOUTHBOUND KNEE WALLS)

ELECTRICAL PLAN

SCALE: 1"=20'
DATE: JANUARY 14, 2009

DRAWN BY: HR
CHECKED BY: JPC



I-90/94 SB LOCAL LANES

3/10/2009 2:35:03 PM