
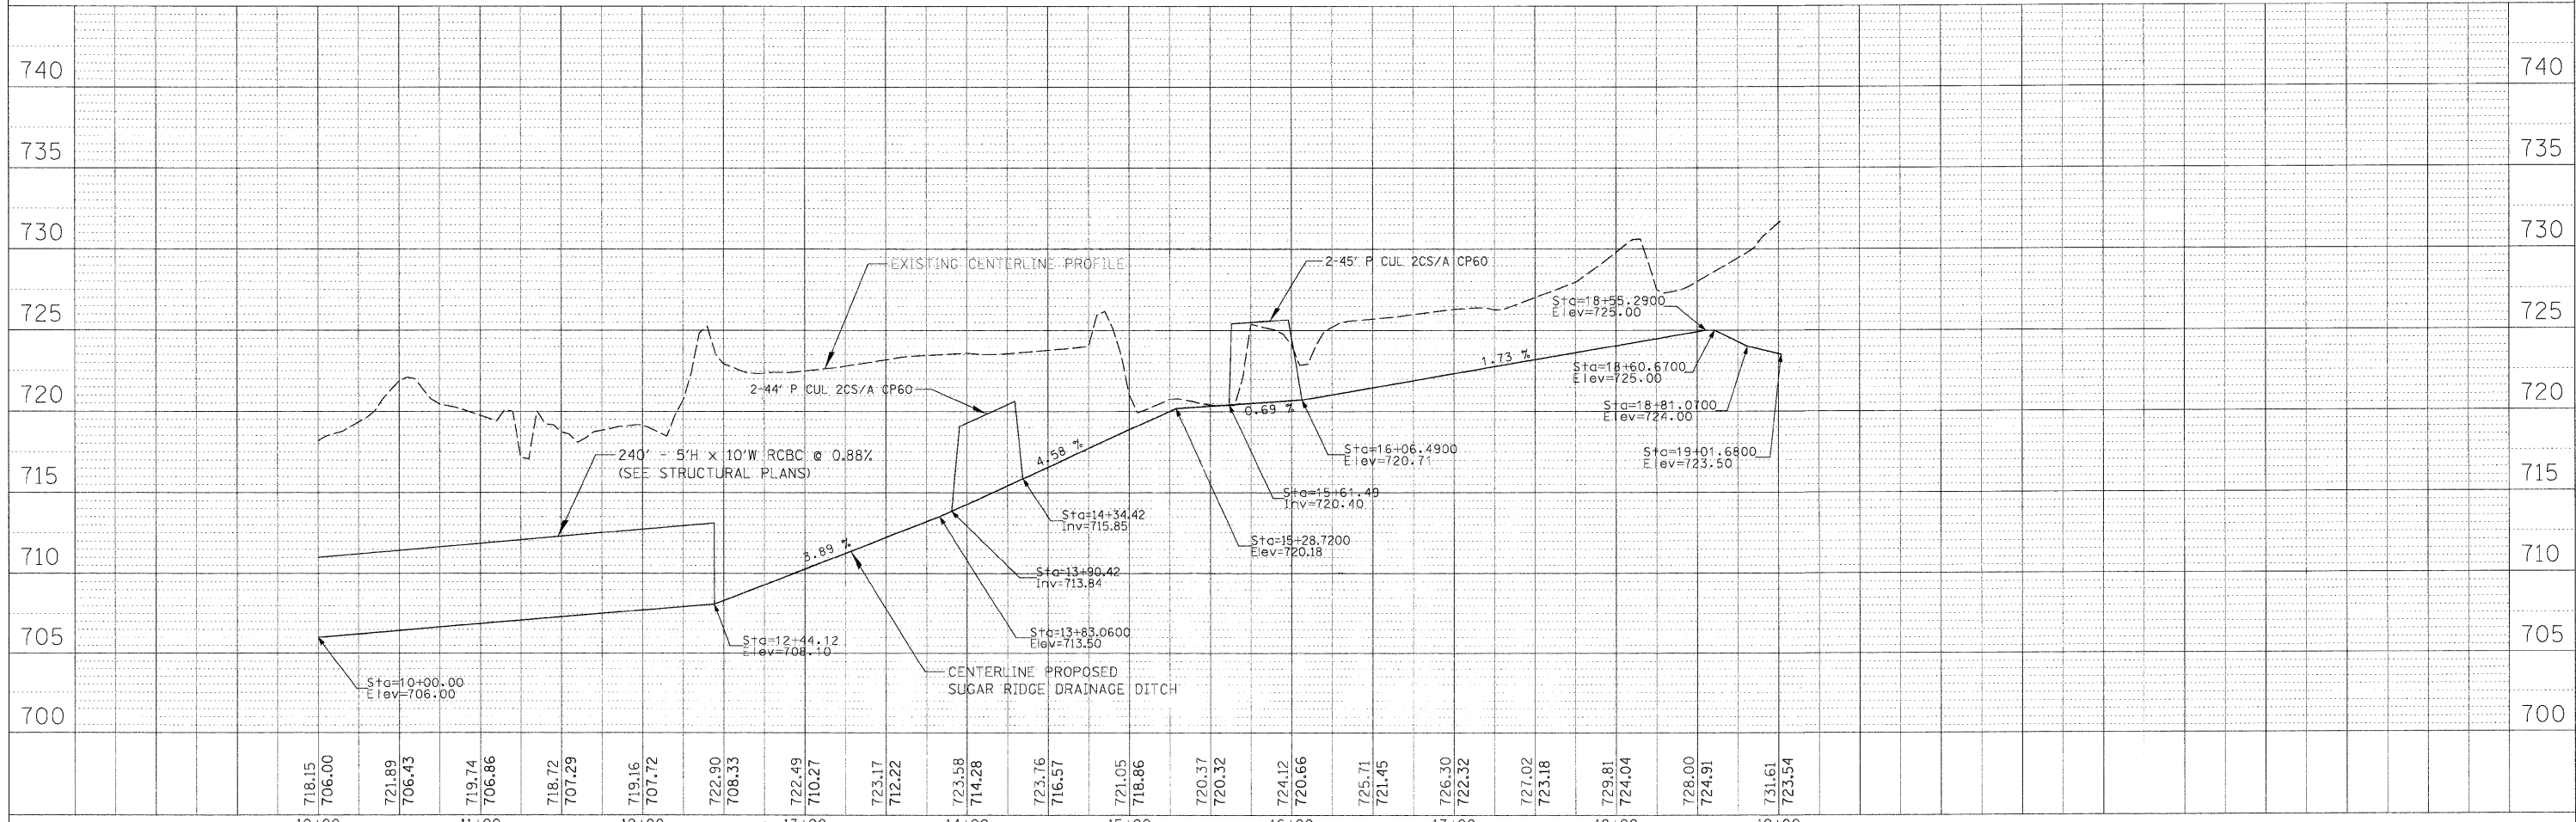


PLAN	SURVEYED	DATE
	PLOTTED	BY
	NOTED	
	FILED	
	NO. _____	
	DATE _____	

PROFILE	SURVEYED	DATE
	PLOTTED	BY
	NOTED	
	FILED	
	NO. _____	
	DATE _____	

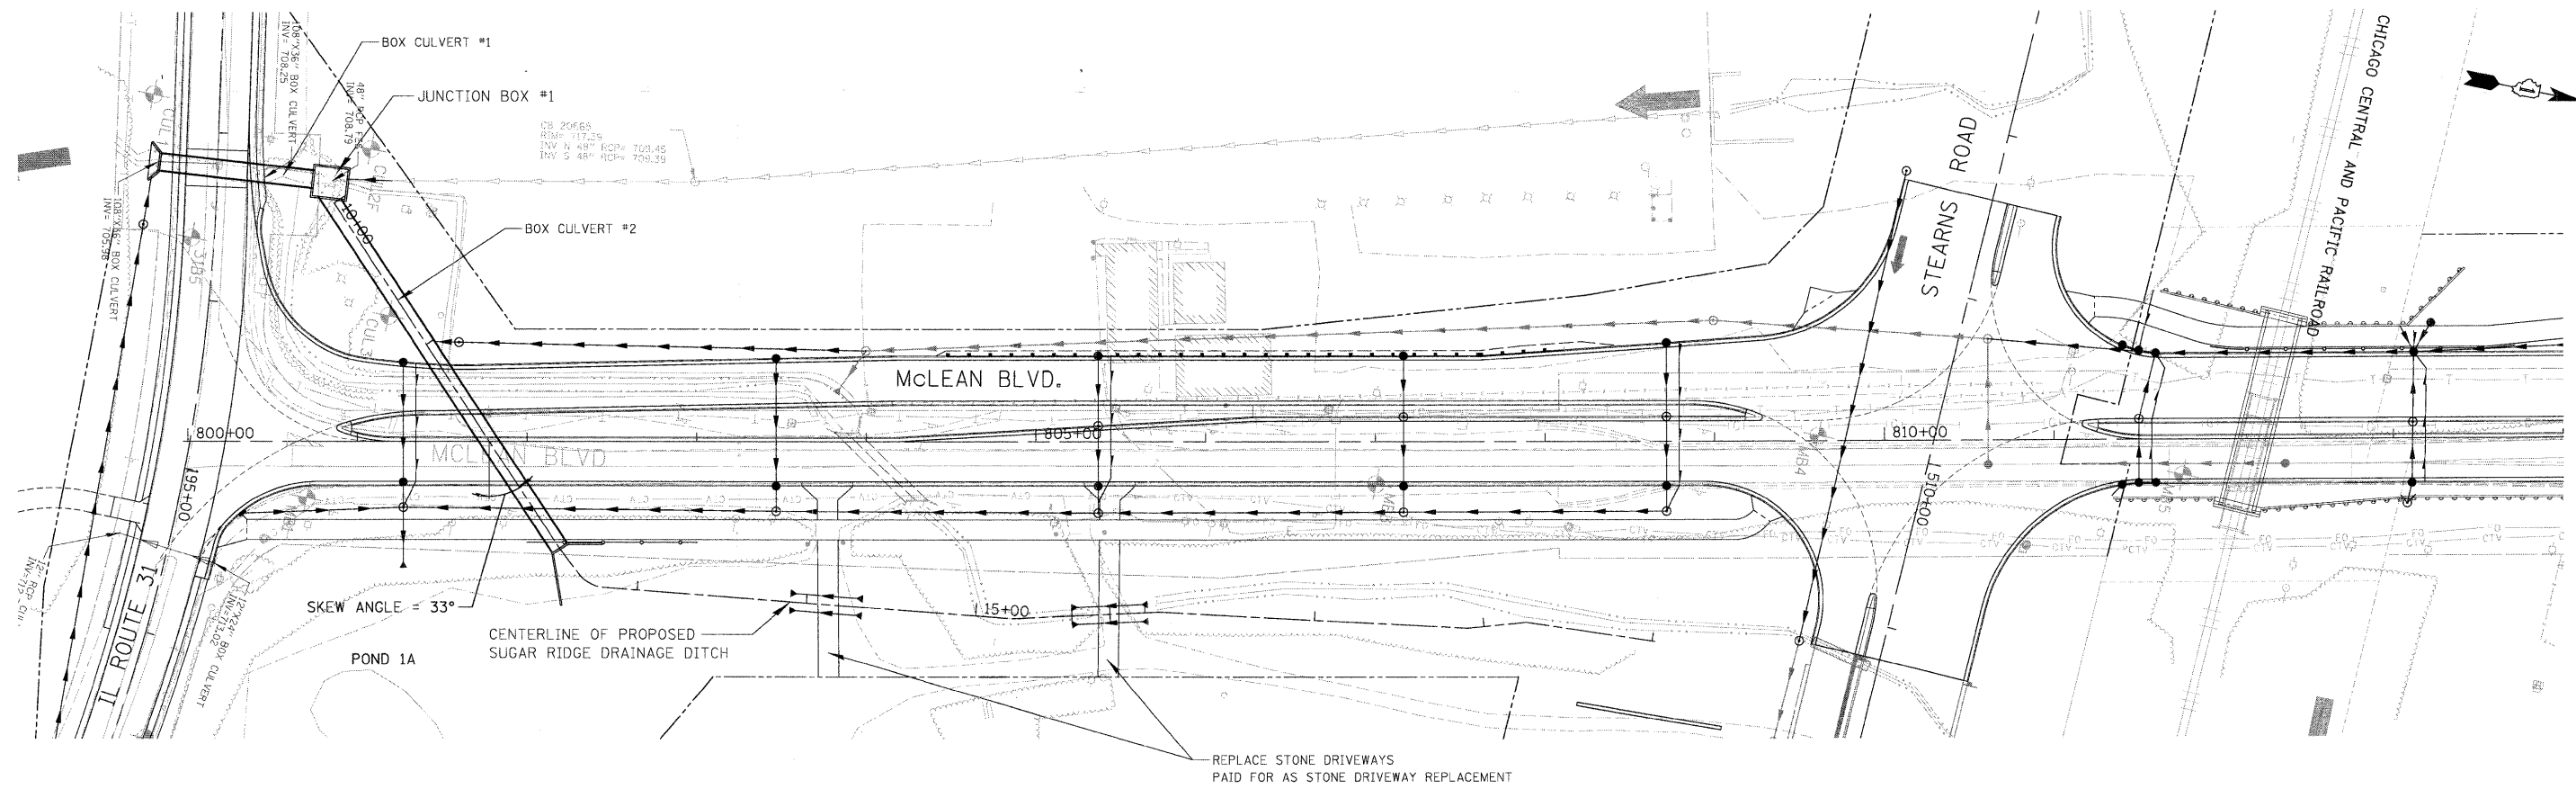

FILE NAME = DPP_07996_04.SHT	USER NAME = dvrmond	DESIGNED - JWJ	REVISED -	<b>STATE OF ILLINOIS DEPARTMENT OF TRANSPORTATION</b>	<b>NEW STEARN'S ROAD - STAGE 2 SUGAR RIDGE DRAINAGE DITCH - DRAINAGE PLAN &amp; PROFILE</b>	F.A.I. RTE. 361	SECTION 06-00214-10-BR	COUNTY KANE	TOTAL SHEETS 219	SHEET NO. 37		
PLLOT SCALE = 50'	PLLOT DATE = 3/27/2009	DRAWN - DJV	REVISED -			SCALE: 1"=50'	SHEET NO. 5 OF 6 SHEETS	STA. 10+00 TO STA. 19+01.68	FED. ROAD DIST. NO. 1 ILLINOIS FED. AID PROJECT			
		CHECKED - JWJ	REVISED -			CONTRACT NO.						
		DATE -	REVISED -									