
 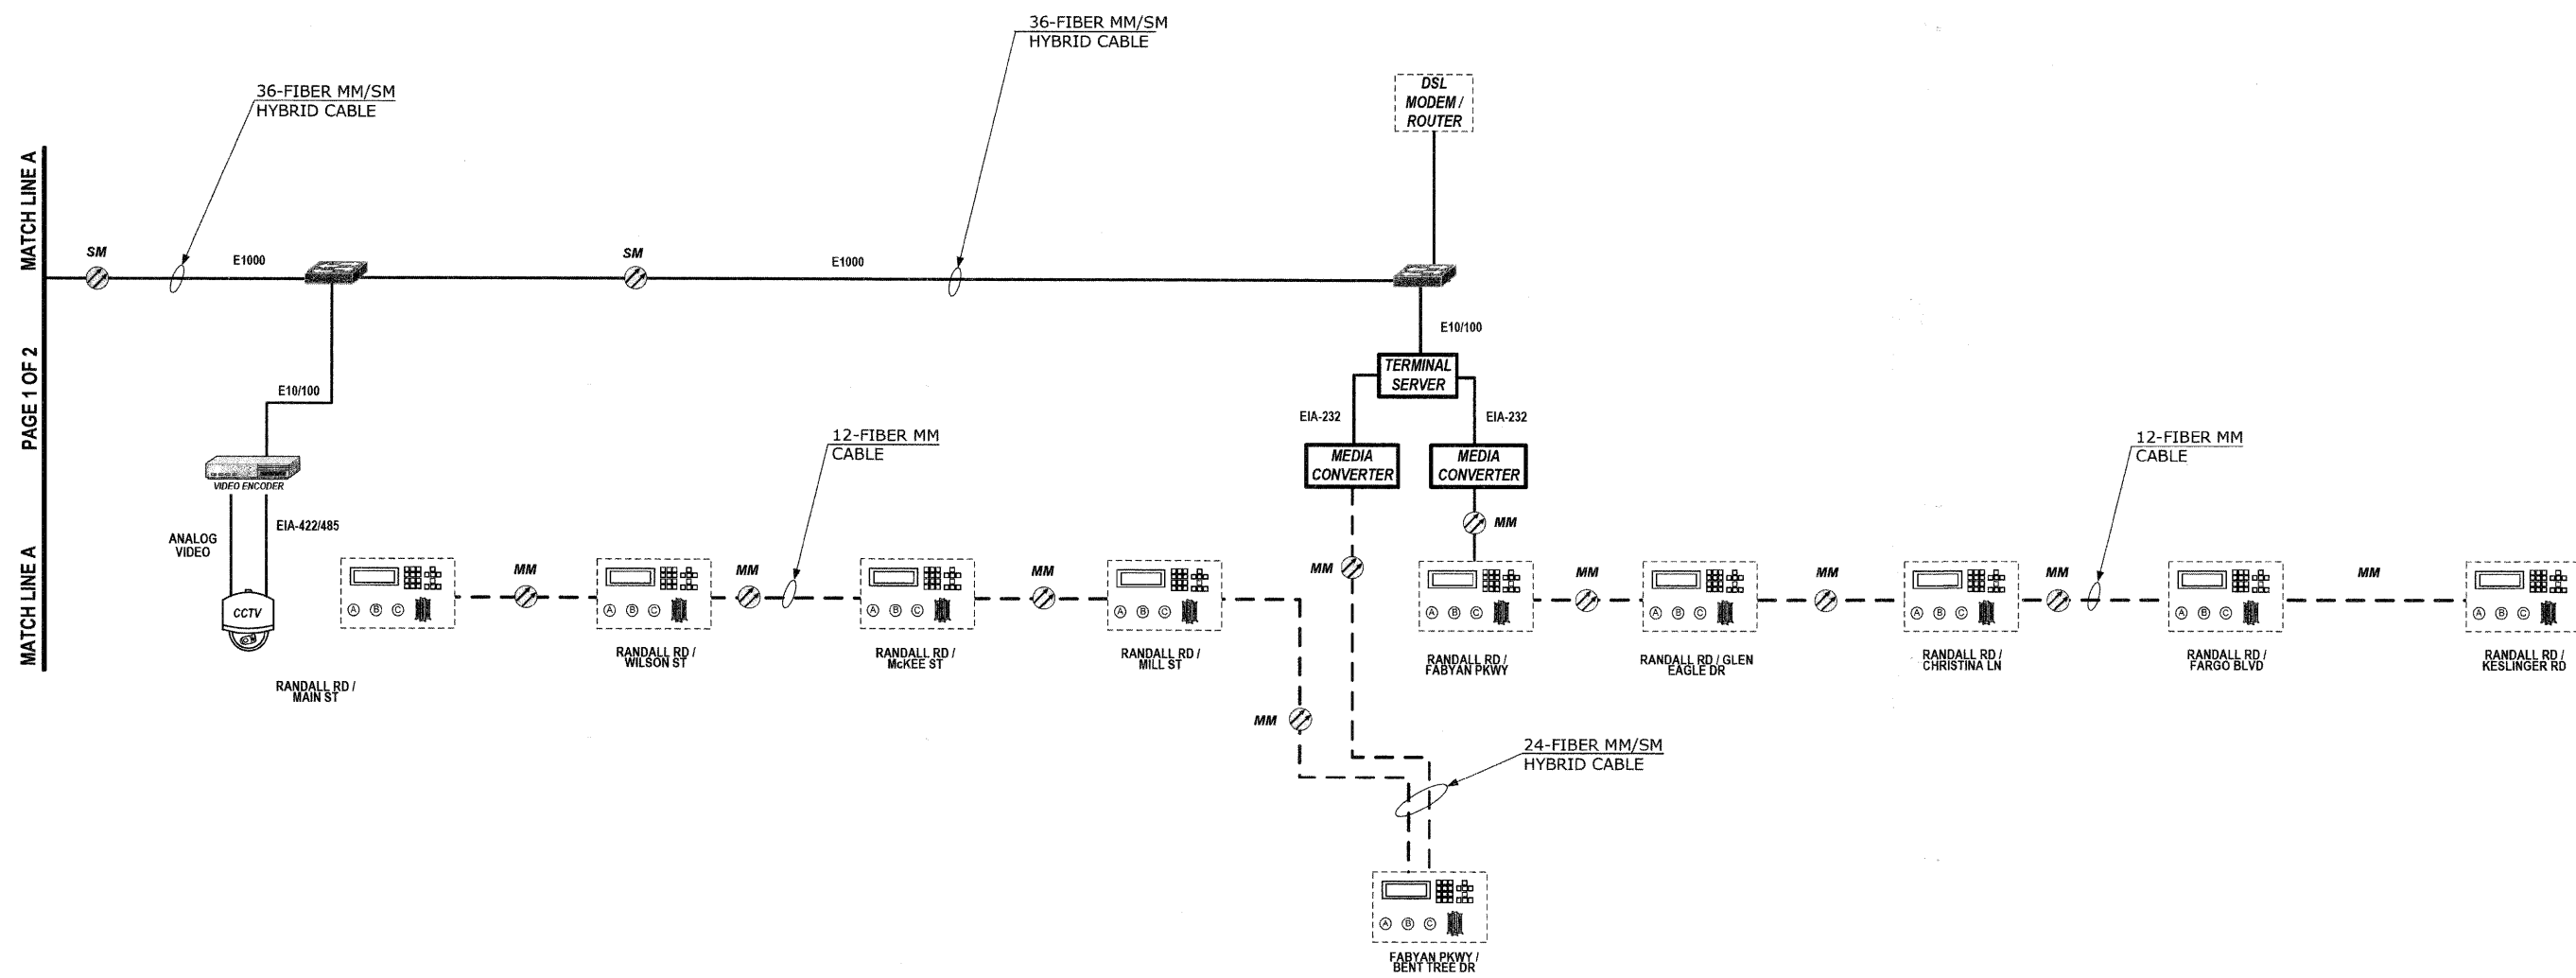



DATE: _____ BY: _____
 SURVEYED: _____ ALIGNMENT CHECKED: _____ (DATE) _____ (NAME)
 PLAN: _____ NOTE BOOK NO: _____
 HNTB
 DATE: _____ BY: _____
 PROFILE: _____ NOTE BOOK NO: _____
 HNTB CORPORATION
 111 N. CANAL STREET
 SUITE 200
 CHICAGO, IL 60606
 (312) 850-9119

KEY

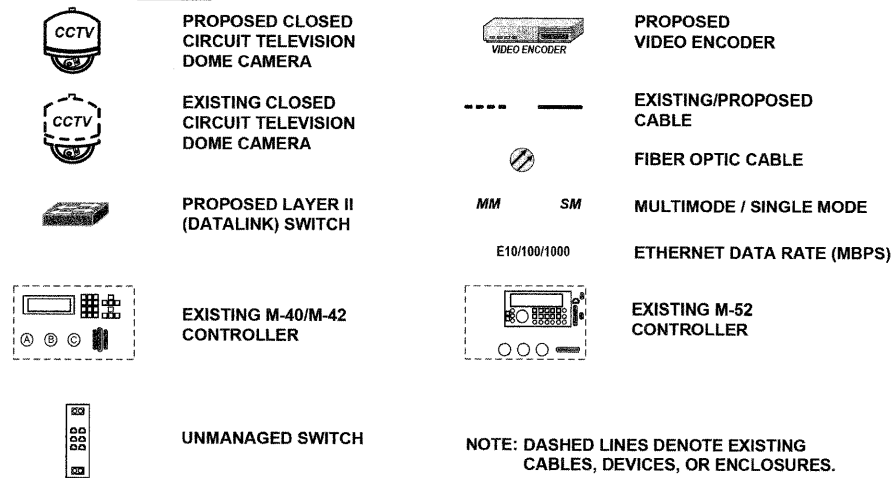

FILE NAME =	USER NAME =	DESIGNED JOSH ZVOLANEK	REVISED -
		CHECKED YOUNGJAE JU	REVISED -
		DRAWN JOSH ZVOLANEK	REVISED -
		DATE 2/20/2009	REVISED -

STATE OF ILLINOIS
 DEPARTMENT OF TRANSPORTATION

COMMUNICATIONS PLAN (PAGE 2 OF 2)
 RANDALL ROAD
 ORCHARD ROAD TO FABYAN PARKWAY

RTE. 336	SECTION 07-00366-00-TL	COUNTY KANE	TOTAL SHEETS 43	SHEET NO. 20
CONTRACT NO. 63128				
FED. ROAD DIST. NO. ILLINOIS FED. AID PROJECT				

SCALE: NTS