
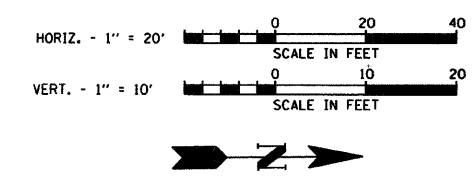



F.H. 1
 FIRE HYDRANT W/ AUX.
 VALVE AND VALVE BOX
 STA. 615+50.0, 17.6' LT

F.A.U. ROUTE NO.	SECTION	COUNTY	TOTAL SHEETS	SHEET NO.
4011	07-00072-00-PV	McHENRY	90	22
ILLINOIS PROJECT				
CONTRACT NO. 63137				

- NOTES:
- ALL CURB LINE STRUCTURE LOCATIONS & ELEVATIONS ARE INDICATED AT THE EDGE OF PAVEMENT. ALL OTHER STRUCTURES ARE INDICATED AT THEIR CENTER.
 - ALL PIPE LENGTHS ARE INDICATED TO INSIDE WALL OF STRUCTURE.

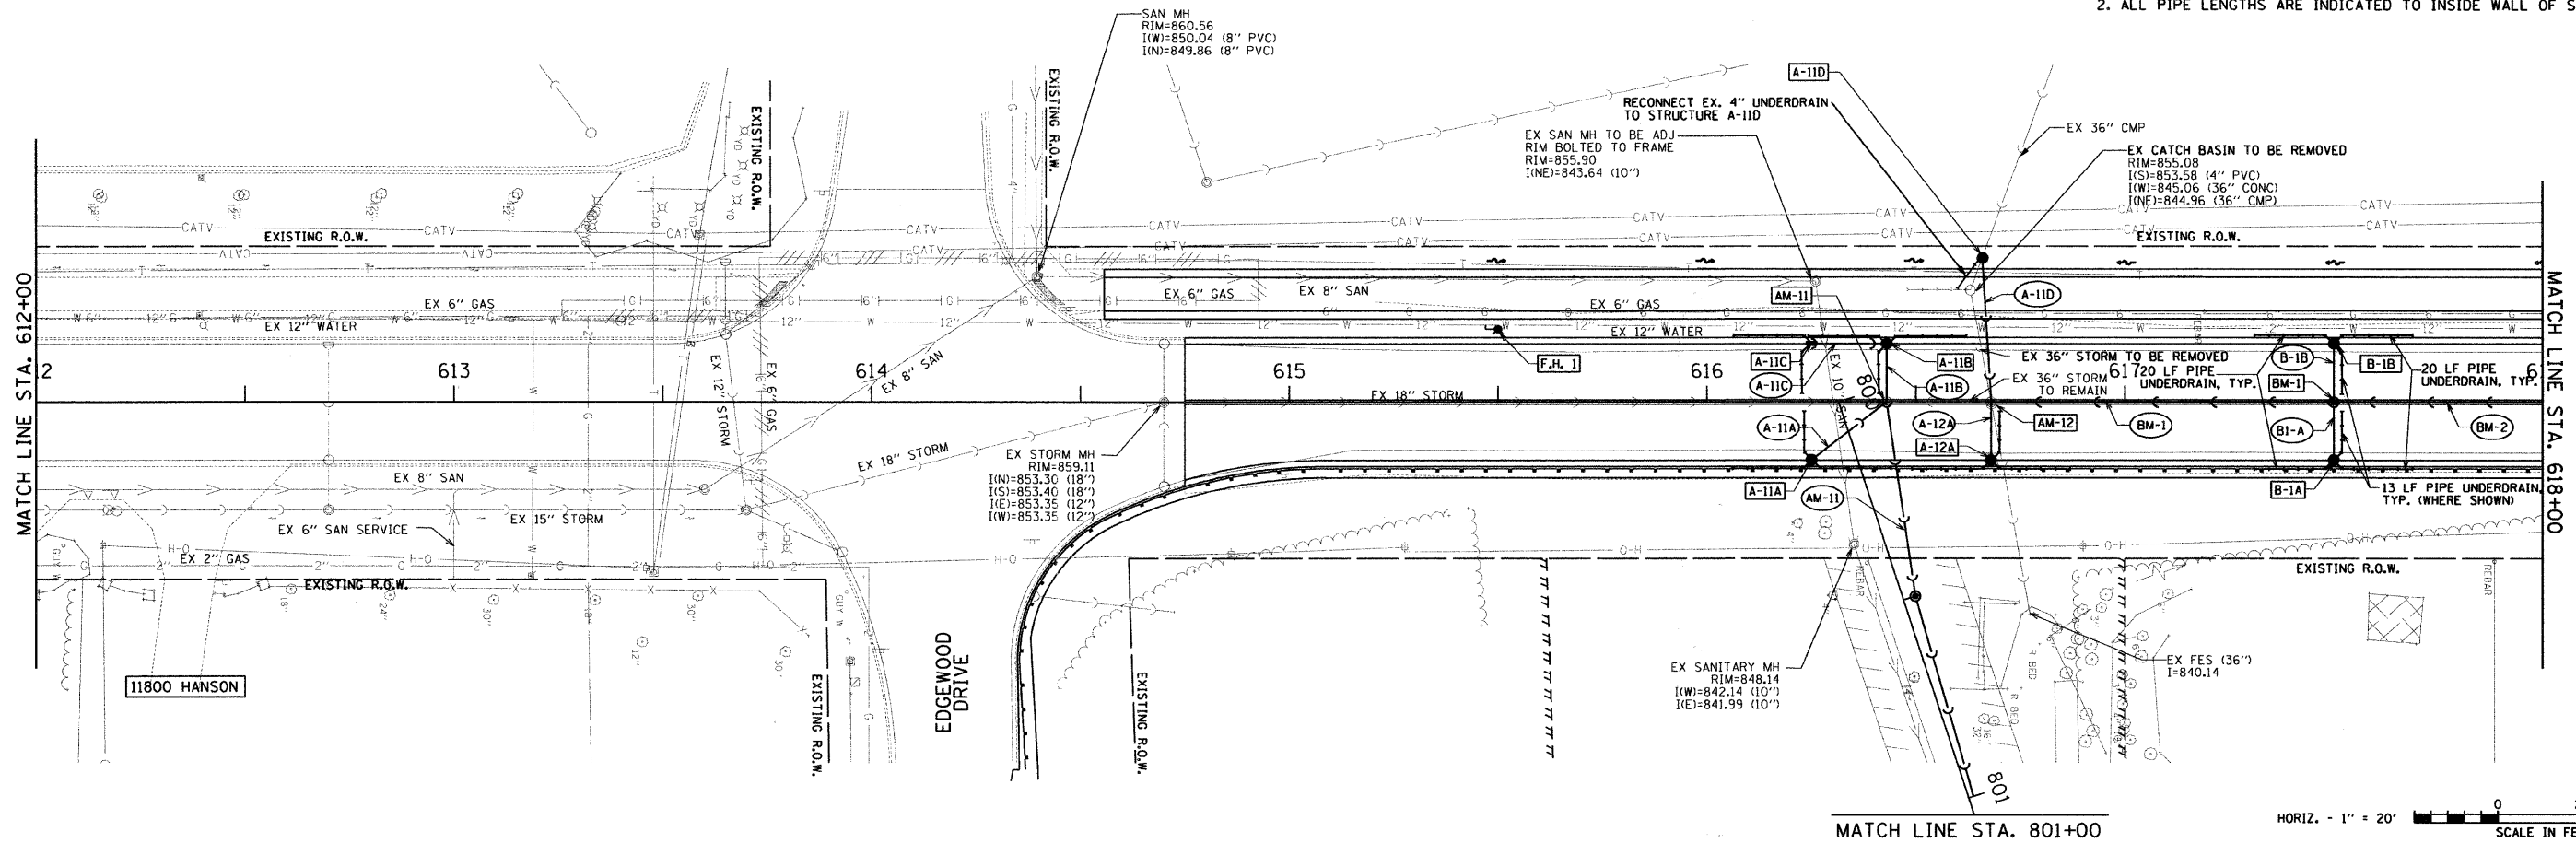

HANSON ROAD
 STORM SEWER PLANS

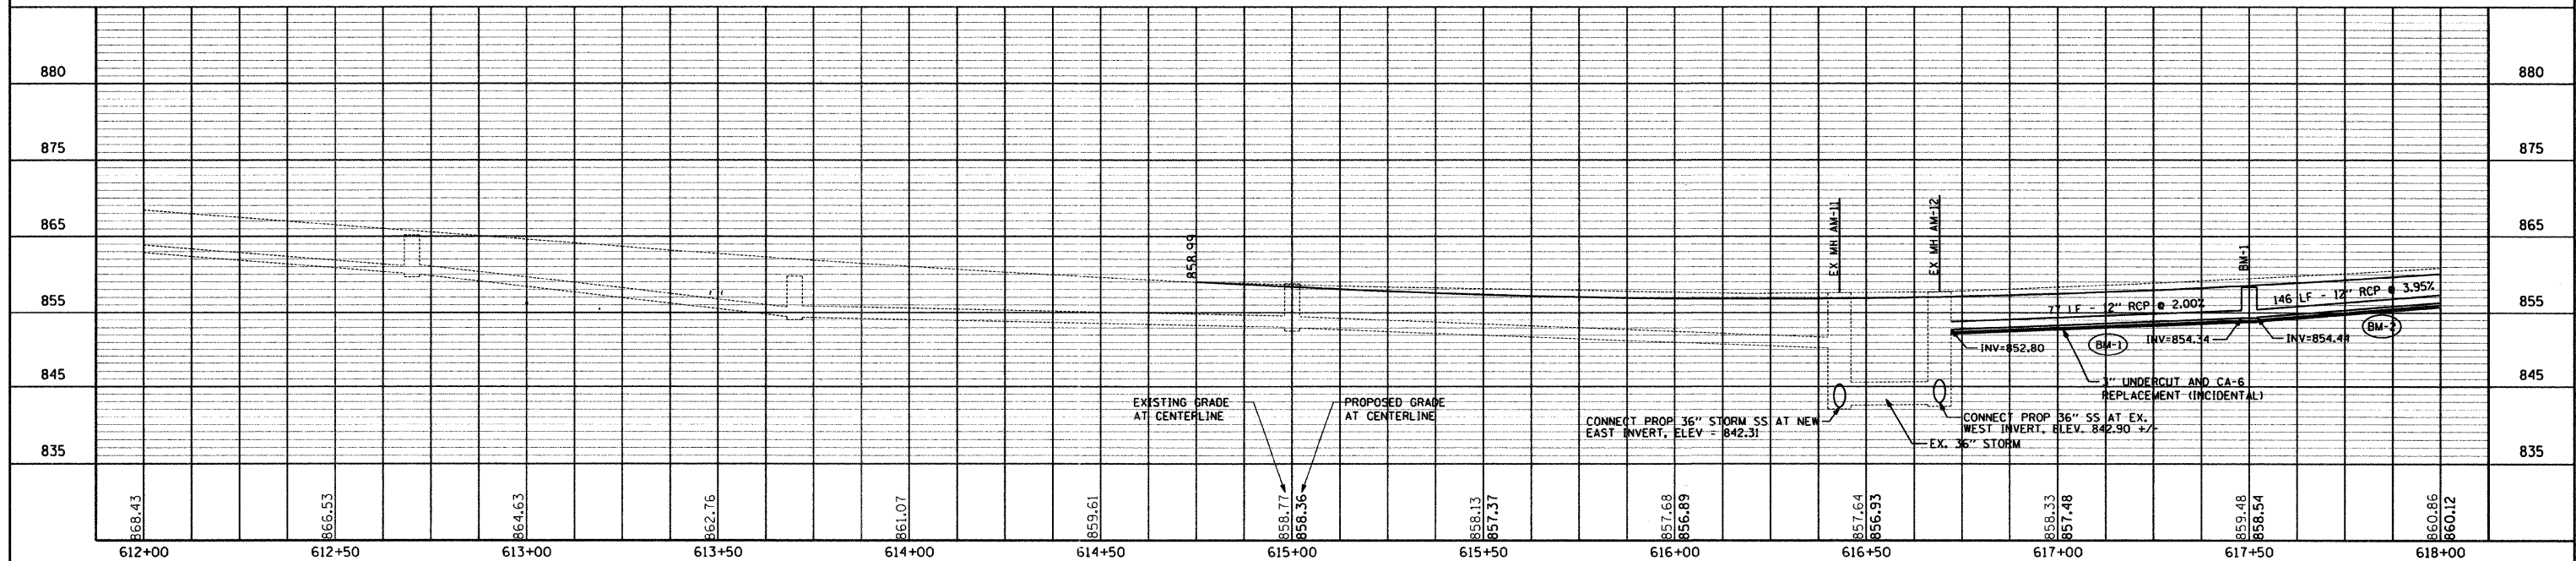

PLAN AND PROFILE

HANSON ROAD STA. 612+00 TO STA. 618+00