


F.A.U. ROUTE NO.	SECTION	COUNTY	TOTAL SHEETS	SHEET NO.
4011	07-00072-00-PV	McHENRY	80	24


ILLINOIS PROJECT

CONTRACT NO. 63137


- NOTES:
- ALL CURB LINE STRUCTURE LOCATIONS & ELEVATIONS ARE INDICATED AT THE EDGE OF PAVEMENT. ALL OTHER STRUCTURES ARE INDICATED AT THEIR CENTER.
  - ALL PIPE LENGTHS ARE INDICATED TO INSIDE WALL OF STRUCTURE.

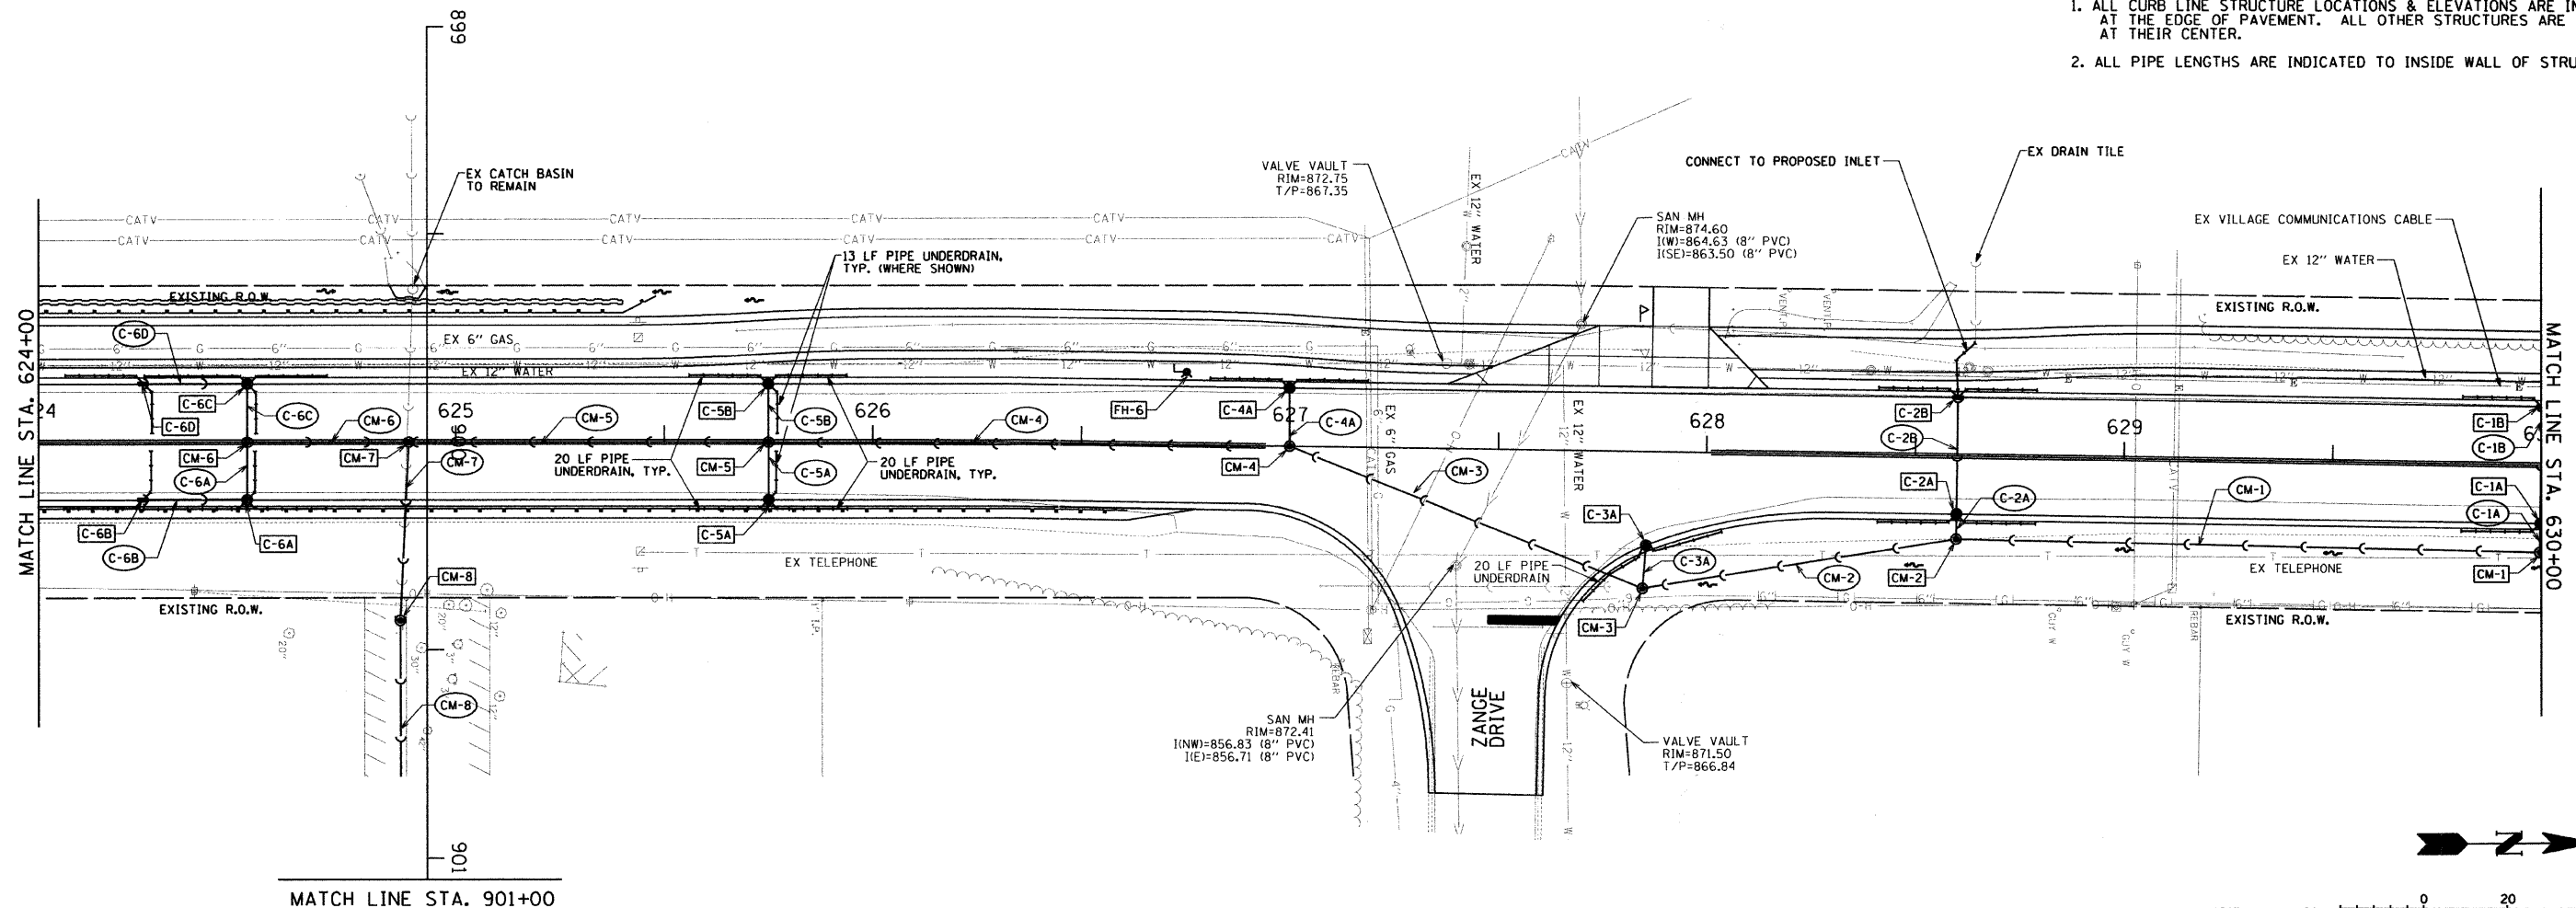

F.H. 6  
FIRE HYDRANT W/ AUX.  
VALVE AND VALVE BOX  
STA. 626+75.0, 17.5' LT

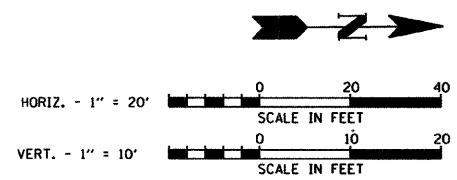

HANSON ROAD  
STORM SEWER PLANS

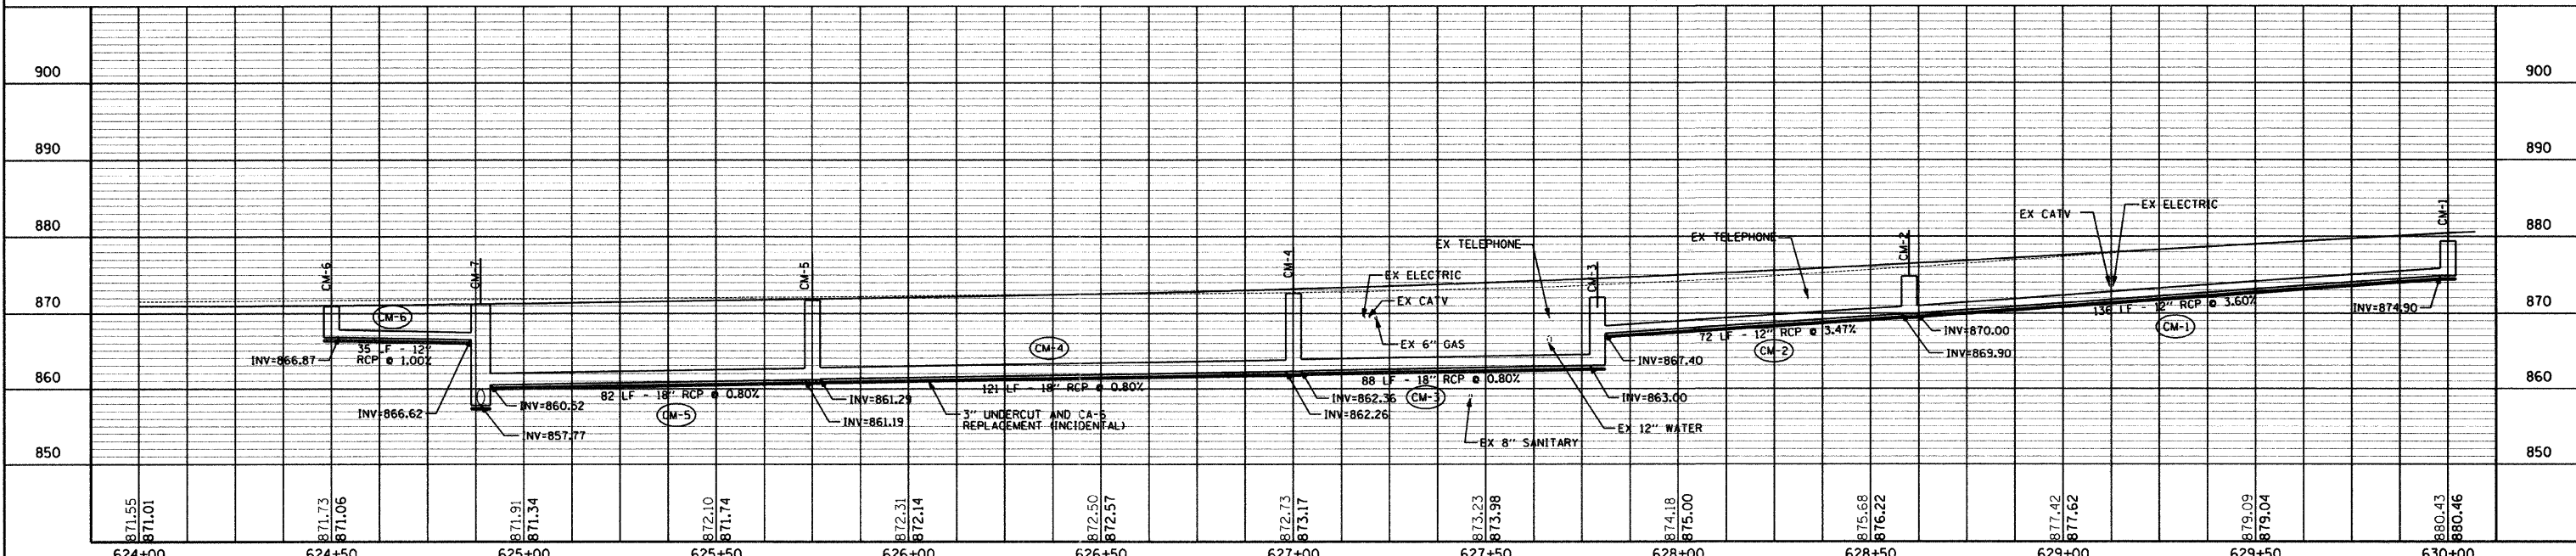

PLAN AND PROFILE

HANSON ROAD STA. 624+00 TO STA. 630+00