


V.V. 1
 VALVE VAULT NO. 1
 12" VALVE IN VALVE VAULT
 TY. A, 5' DIA.
 STA. 642+00.0 , 18.5' RT
 RIM=888+72

F.H. 5
 FIRE HYDRANT W/ AUX.
 VALVE AND VALVE BOX
 STA. 647+50.0, 17.5' LT


F.A.U. ROUTE NO.	SECTION	COUNTY	TOTAL SHEETS	SHEET NO.
4011	07-00072-00-PV	McHENRY	80	27

ILLINOIS PROJECT
 CONTRACT NO. 63137

- NOTES:
- ALL CURB LINE STRUCTURE LOCATIONS & ELEVATIONS ARE INDICATED AT THE EDGE OF PAVEMENT. ALL OTHER STRUCTURES ARE INDICATED AT THEIR CENTER.
 - ALL PIPE LENGTHS ARE INDICATED TO INSIDE WALL OF STRUCTURE.

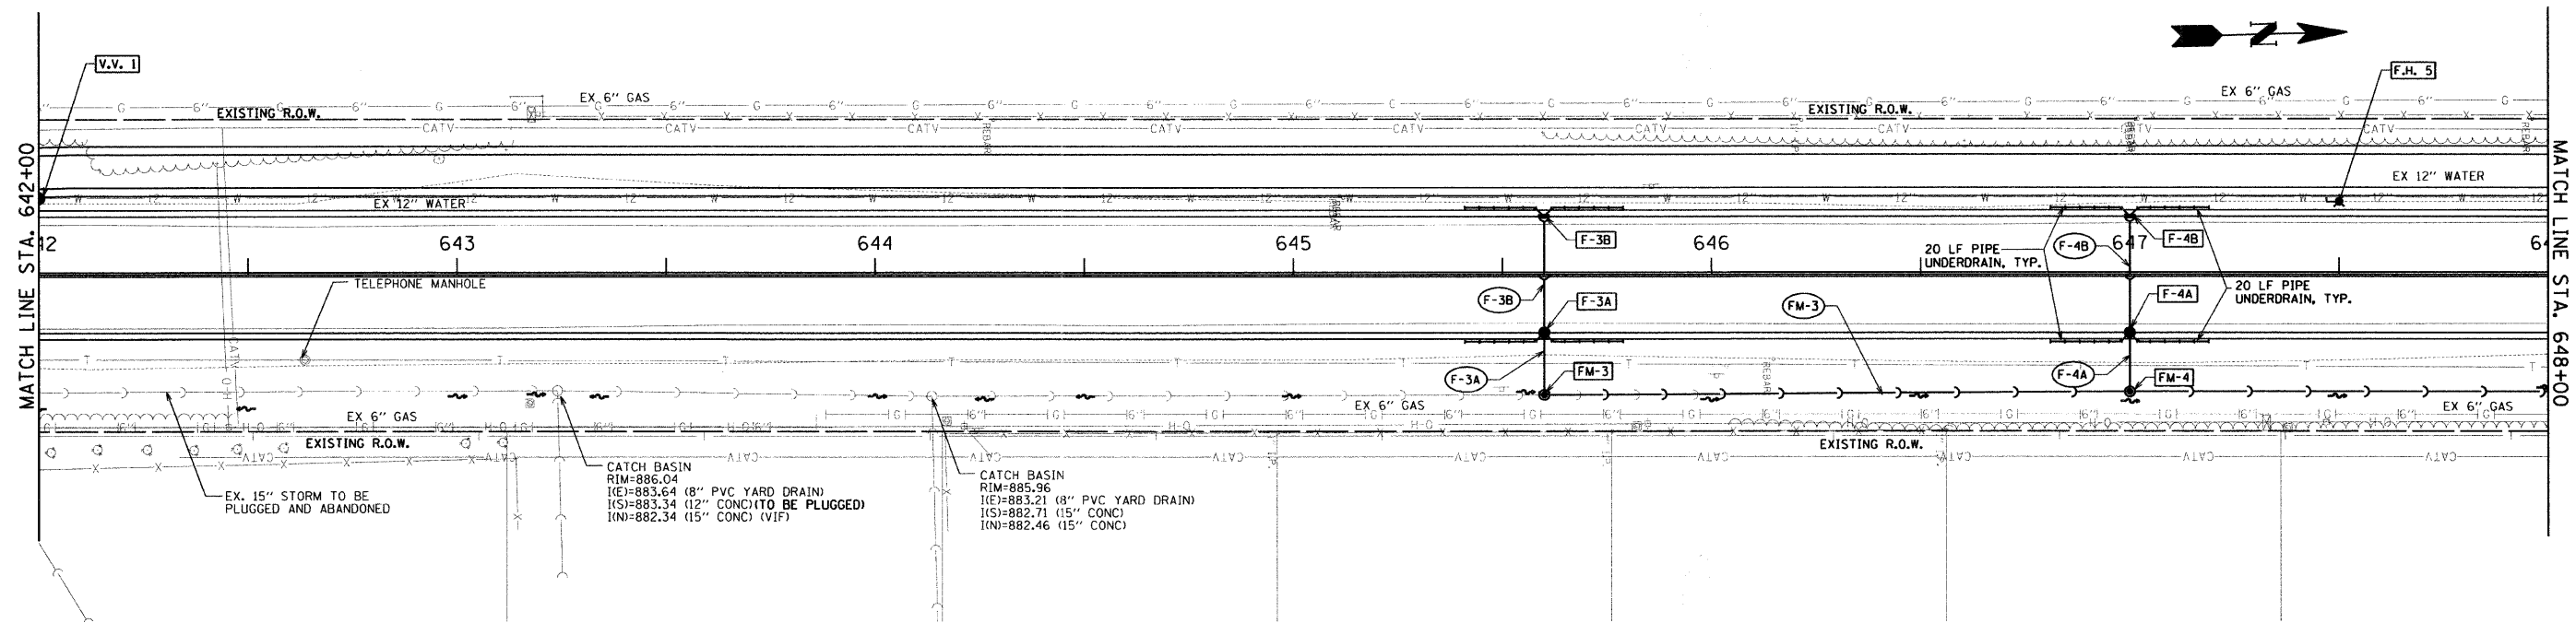

HANSON ROAD
 STORM SEWER PLANS

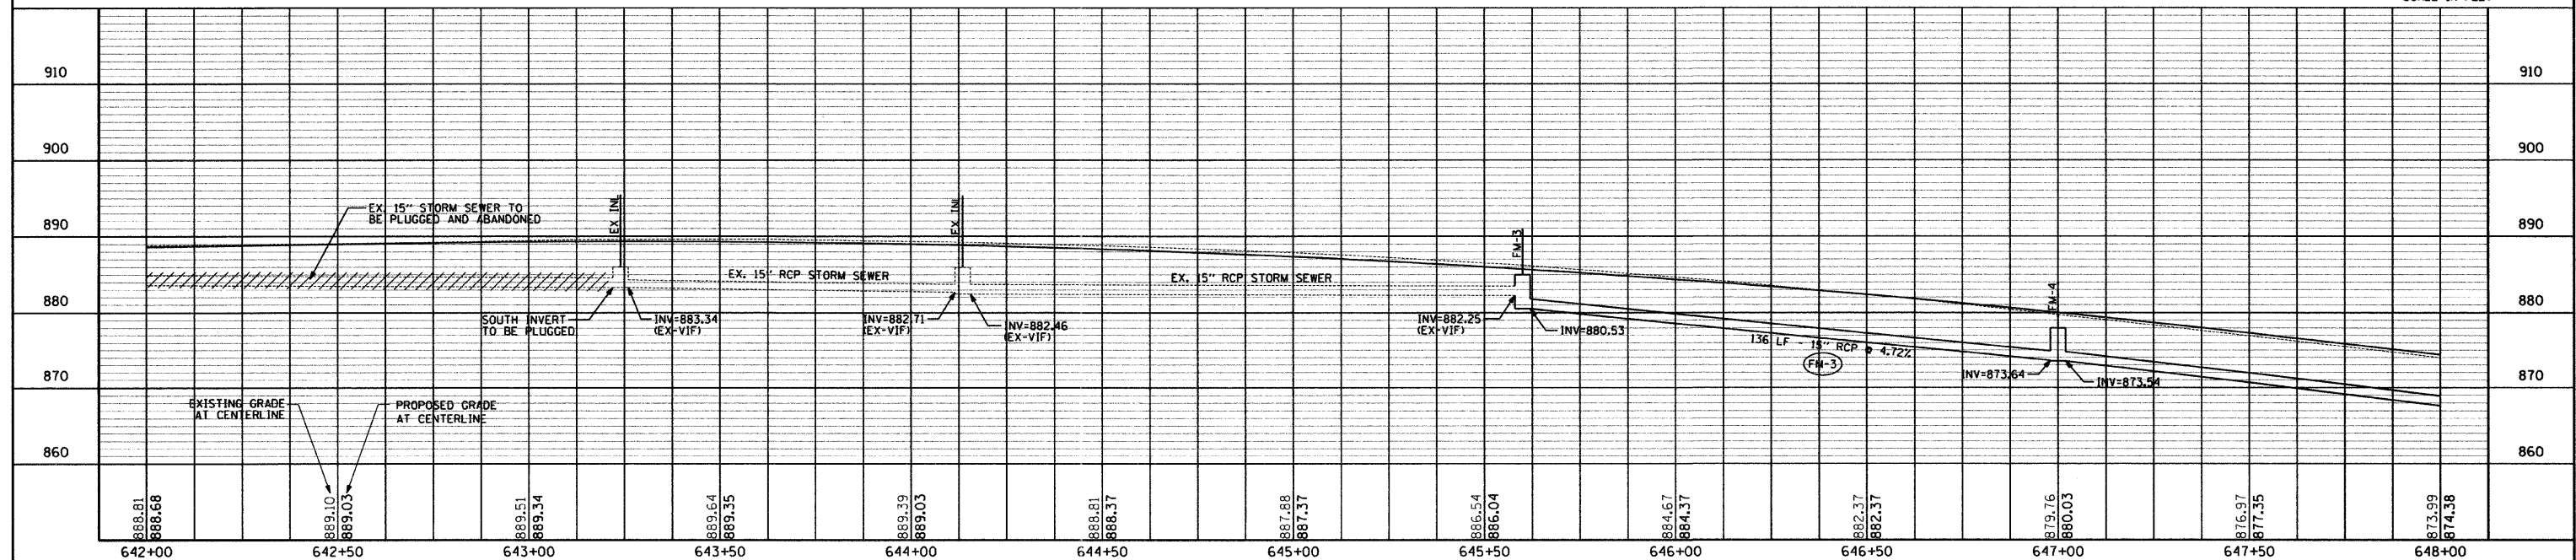

PLAN AND PROFILE

HANSON ROAD STA. 642+00 TO STA. 648+00