




F.A.U. ROUTE NO.	SECTION	COUNTY	TOTAL SHEETS	SHEET NO.
4011	07-00072-00-PV	McHENRY	80	29

ILLINOIS PROJECT
CONTRACT NO. 63137

- NOTES:
- ALL CURB LINE STRUCTURE LOCATIONS & ELEVATIONS ARE INDICATED AT THE EDGE OF PAVEMENT. ALL OTHER STRUCTURES ARE INDICATED AT THEIR CENTER.
 - ALL PIPE LENGTHS ARE INDICATED TO INSIDE WALL OF STRUCTURE.

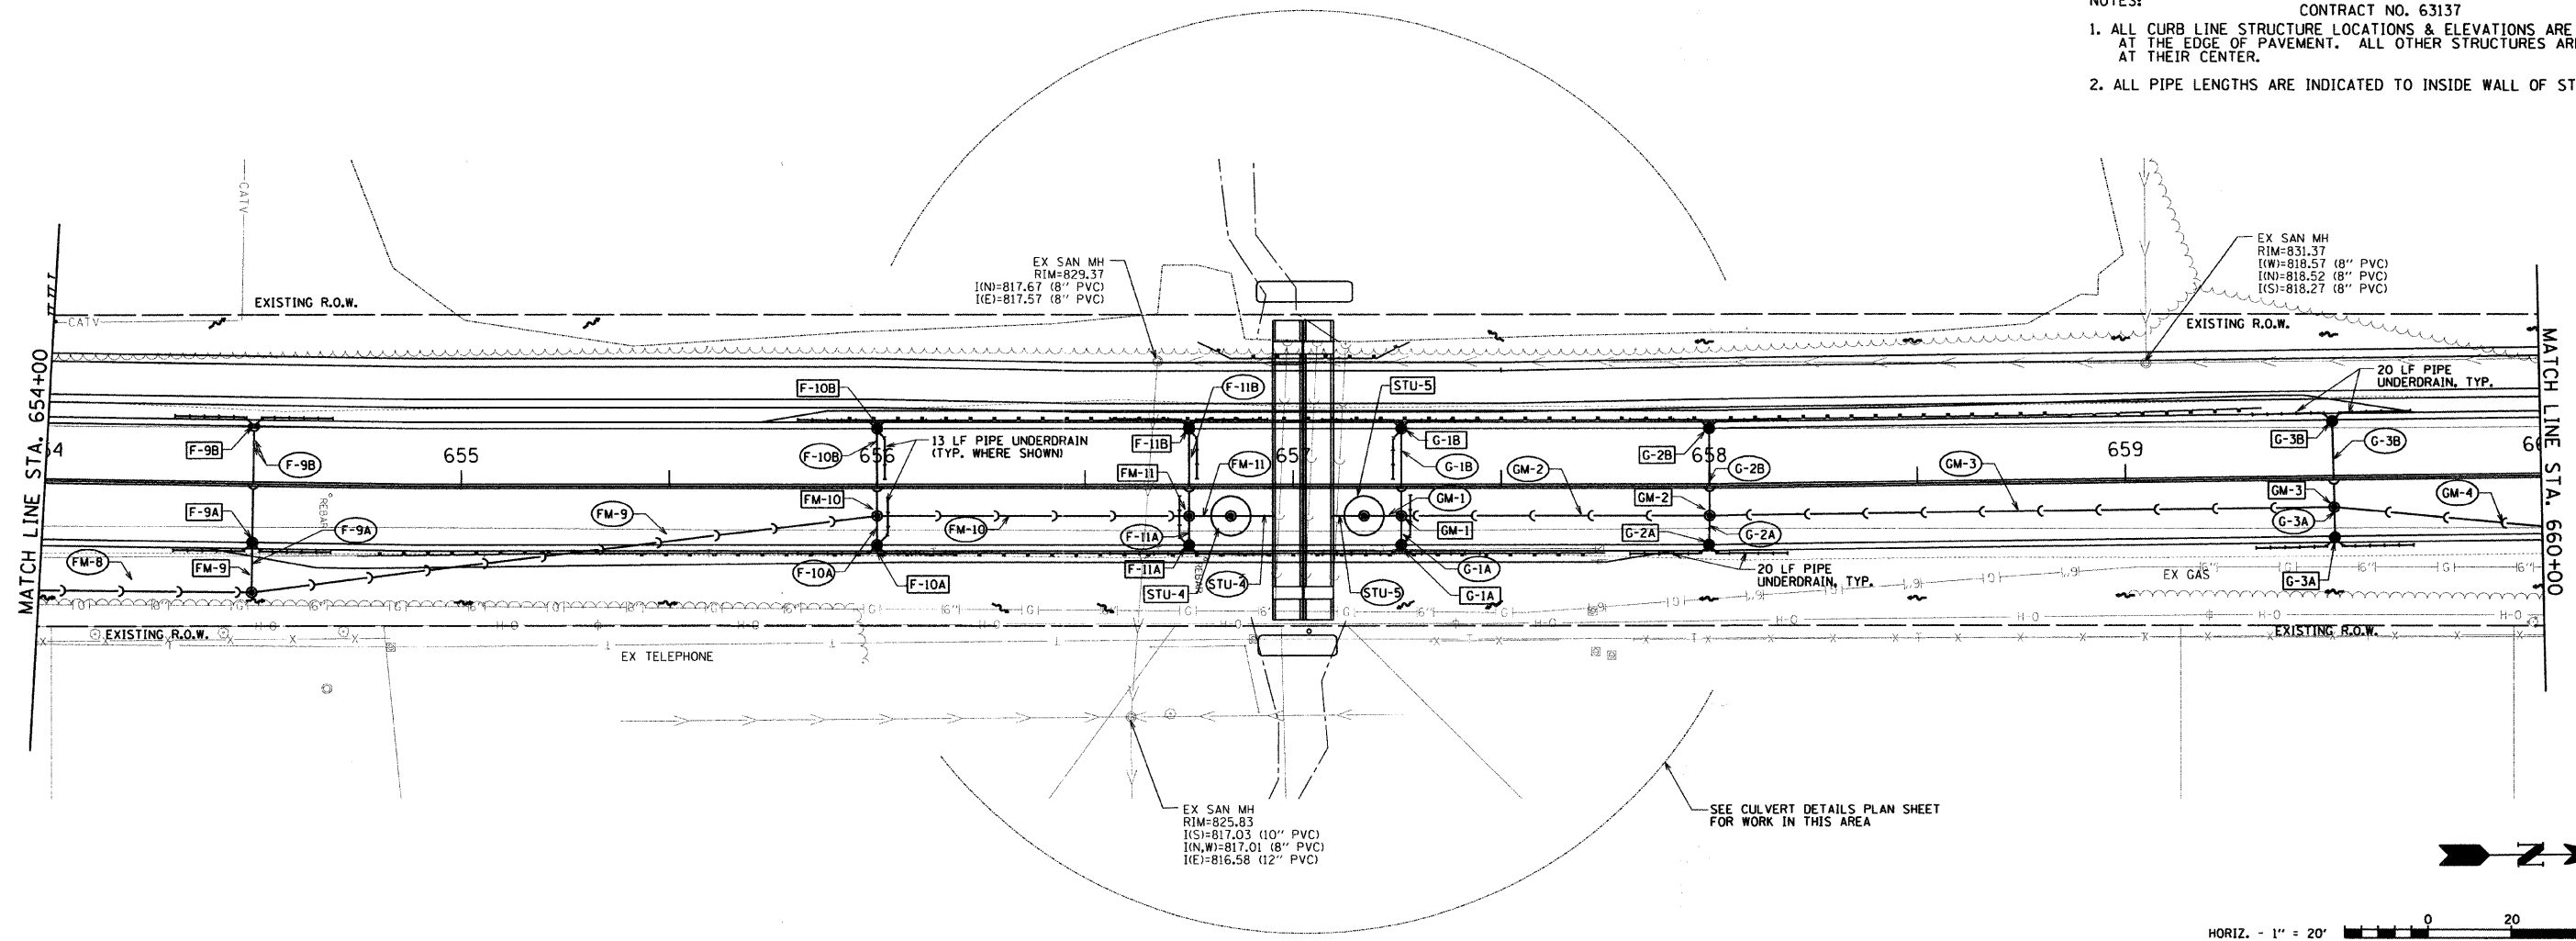

 HANSON ROAD
STORM SEWER PLANS

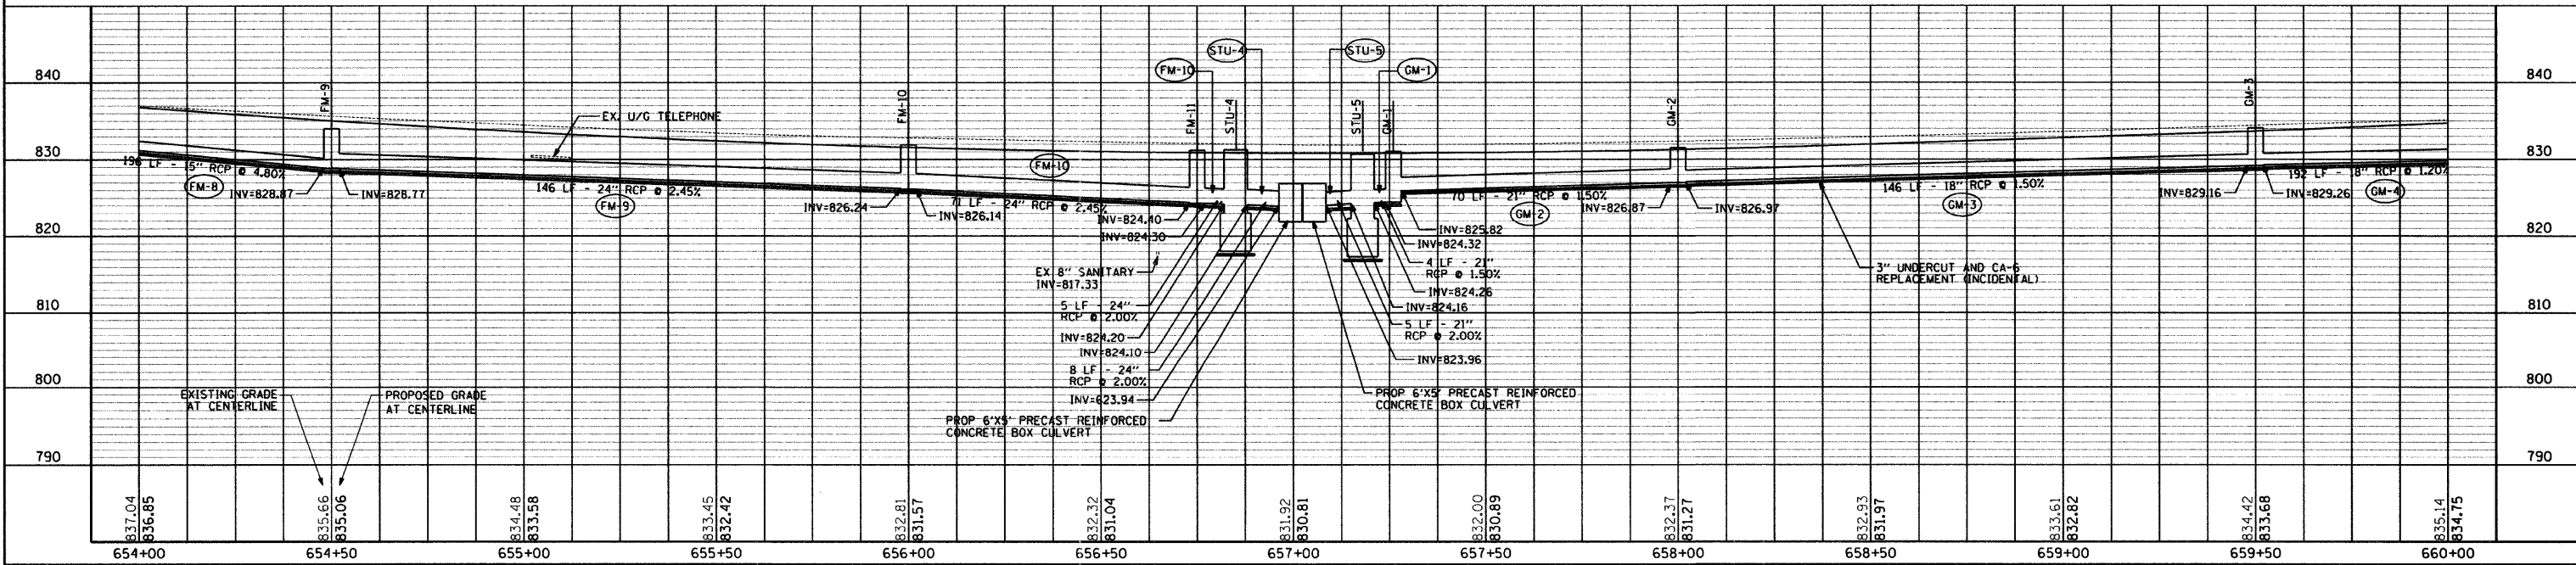

PLAN AND PROFILE

HANSON ROAD STA. 654+00 TO STA. 660+00