
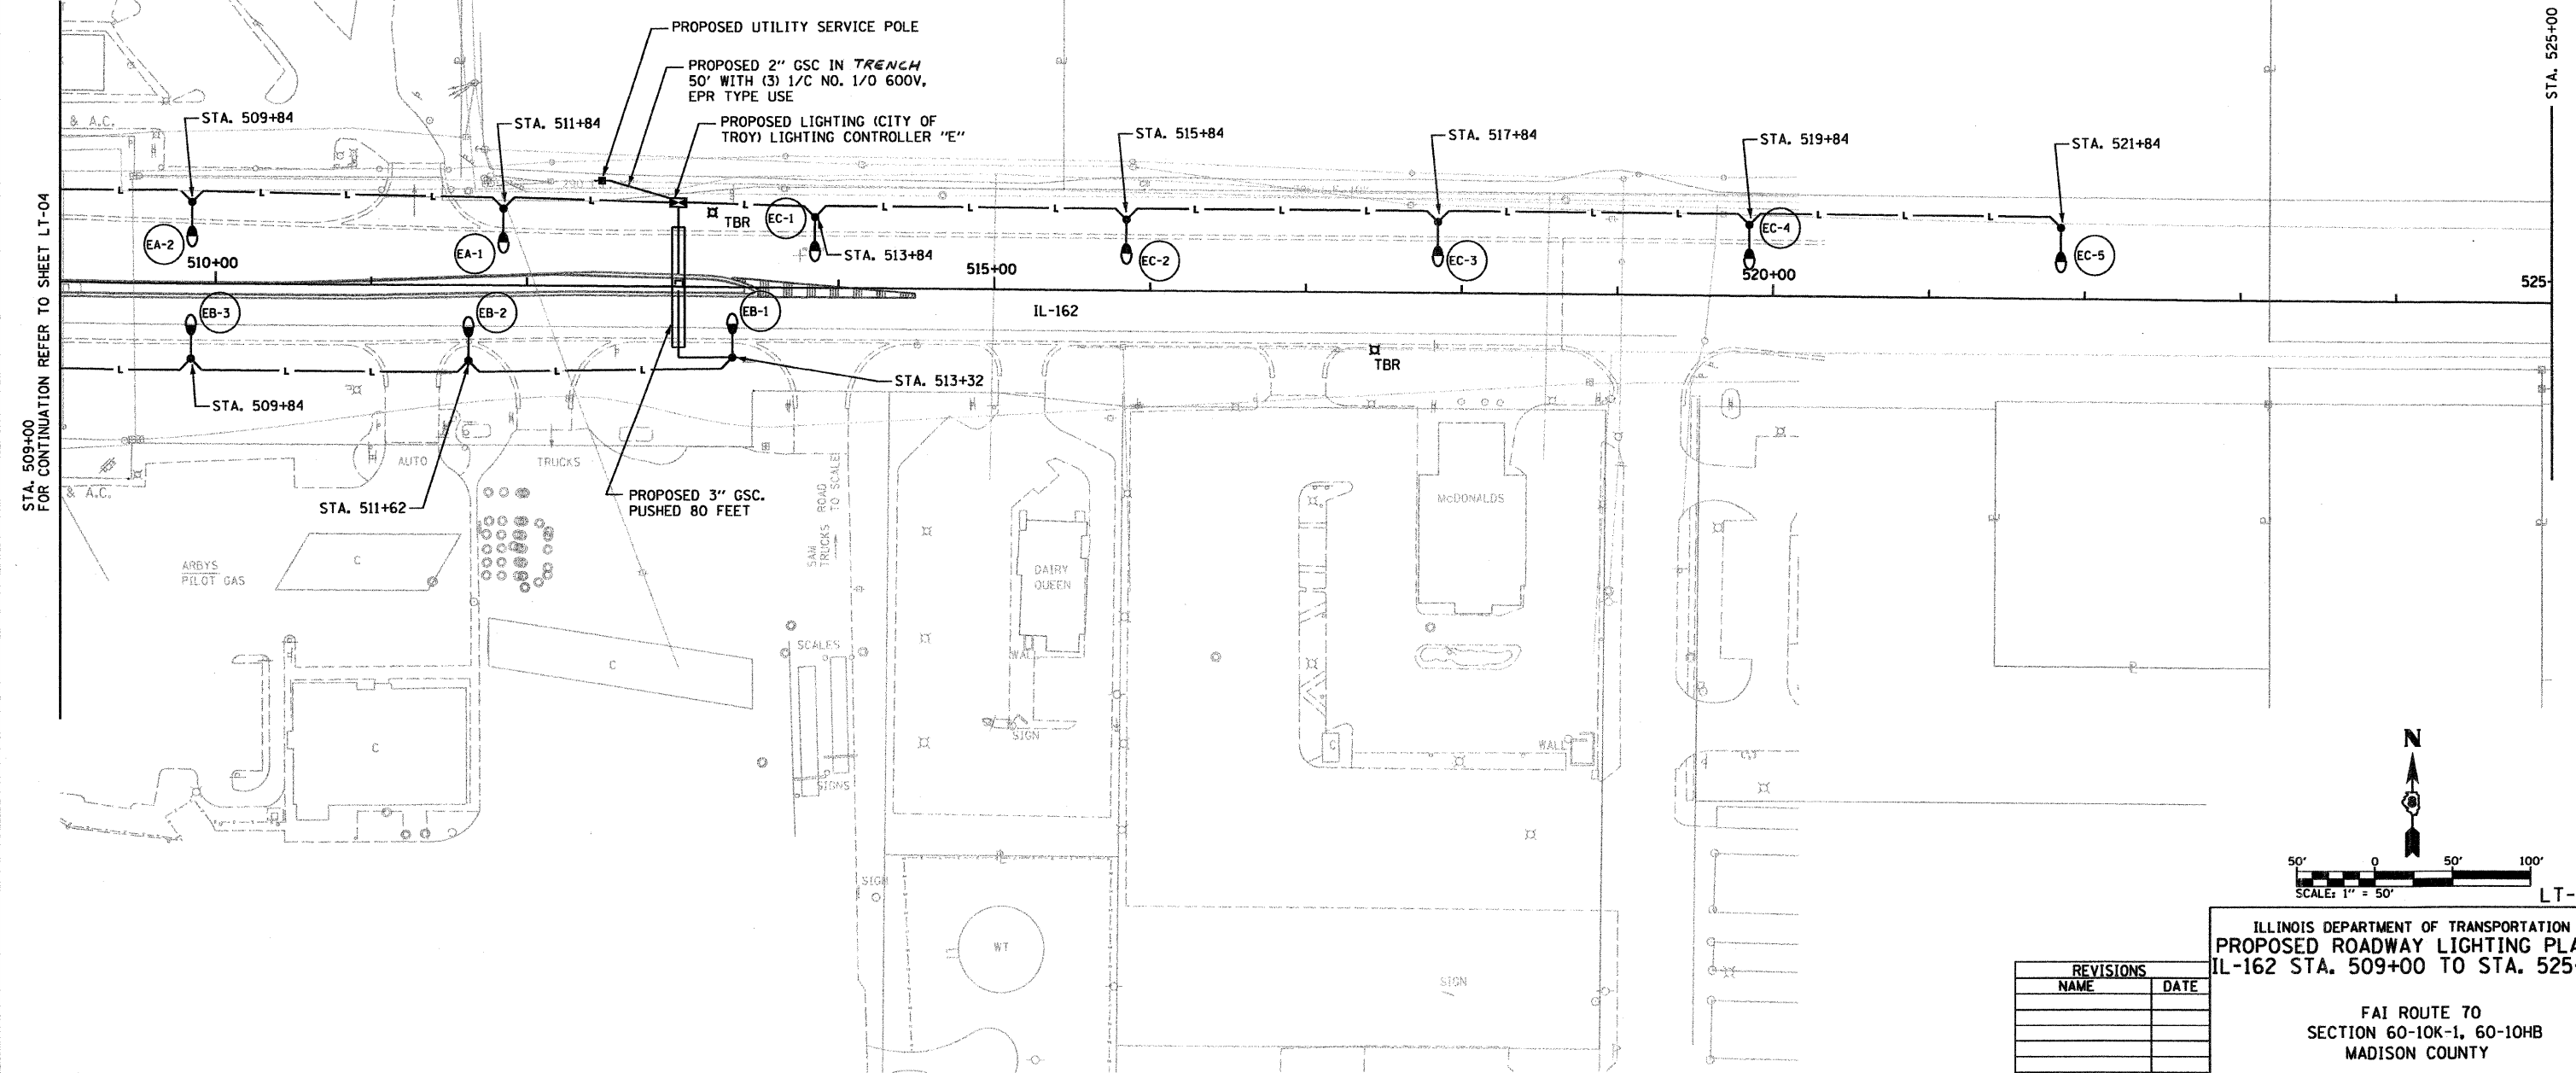


F&P NUMBER	SECTION	COUNTY	TOTAL SHEETS	SHEET NO.
TO	60-10 (K-1,HB)	MADISON	420	182
STA.	TO STA.			
CONTRACT NO.: 76709				

NOTES:
 1. ALL UNIT DUCT ON THIS SHEET SHALL BE 6" (2" * 6 XLP, 1" * 6 XLPG, 1.0P) UNLESS NOTED OTHERWISE.


LEGEND
 TBR - TO BE REMOVED
 REMOVE POLE
 REMOVE AND SALVAGE LUMINAIRE
 REMOVE FOUNDATION

PLAN	DATE
NO.	
BY	
DATE	
BY	
DATE	
BY	
DATE	
BY	
DATE	

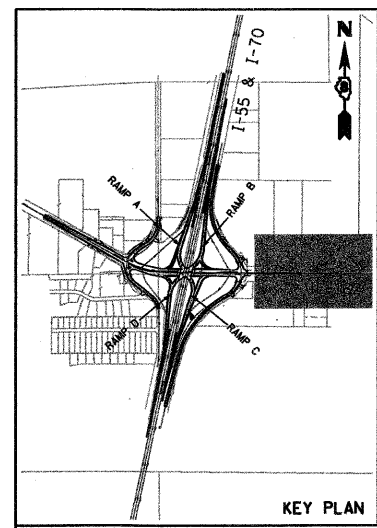

STA. 509+00 FOR CONTINUATION REFER TO SHEET LT-04

STA. 525+00

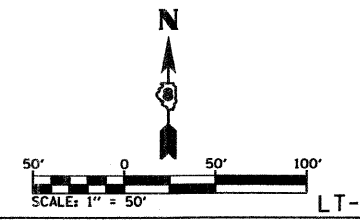

REVISIONS	
NAME	DATE

ILLINOIS DEPARTMENT OF TRANSPORTATION
 PROPOSED ROADWAY LIGHTING PLAN
 IL-162 STA. 509+00 TO STA. 525+00

FAI ROUTE 70
 SECTION 60-10K-1, 60-10HB
 MADISON COUNTY

DRAWN BY: RPJ CHECKED BY: A. OSHANA, P.E.

XXXXXXX - IDOT IL 162 over I-55,70 revisions
 236-LT-05.dgn
 1/28/2009
 1:29:33 PM
 Robert J. Swanson