



| FAP NUMBER | SECTION | COUNTY | TOTAL SHEETS | SHEET NO. |
|---------------------|----------------|---------|--------------|-----------|
| TO | 60-10 (K-1,HB) | MADISON | 420 | 185 |
| STA. | TO STA. | | | |
| CONTRACT NO.: 76709 | | | | |

NOTES:
 1. ALL UNIT DUCT ON THIS SHEET SHALL BE 4 (2 * 4 XLP, 1 * 4 XLPG, 1.OP) UNLESS NOTED OTHERWISE.



LEGEND
 TBR - TO BE REMOVED
 REMOVE POLE
 REMOVE AND SALVAGE LUMINAIRE
 REMOVE FOUNDATION

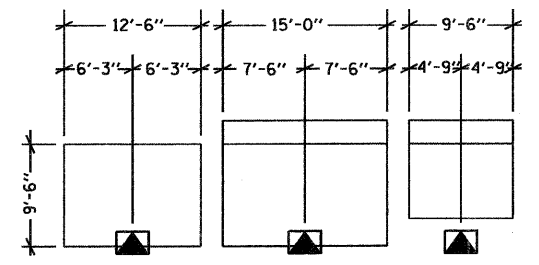

SIGN S-2 - NORTHBOUND I-55/70
 NOT TO SCALE

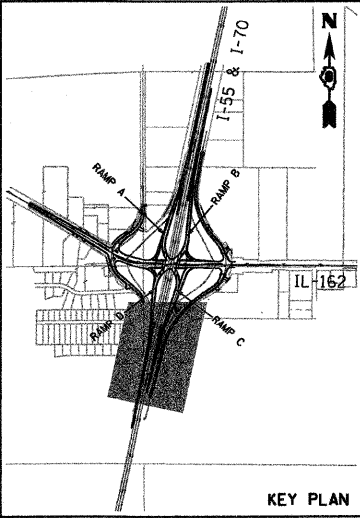

| PLAN | DATE |
|---------|------|
| BY | |
| CHECKED | |
| NO. | |

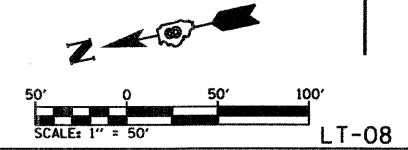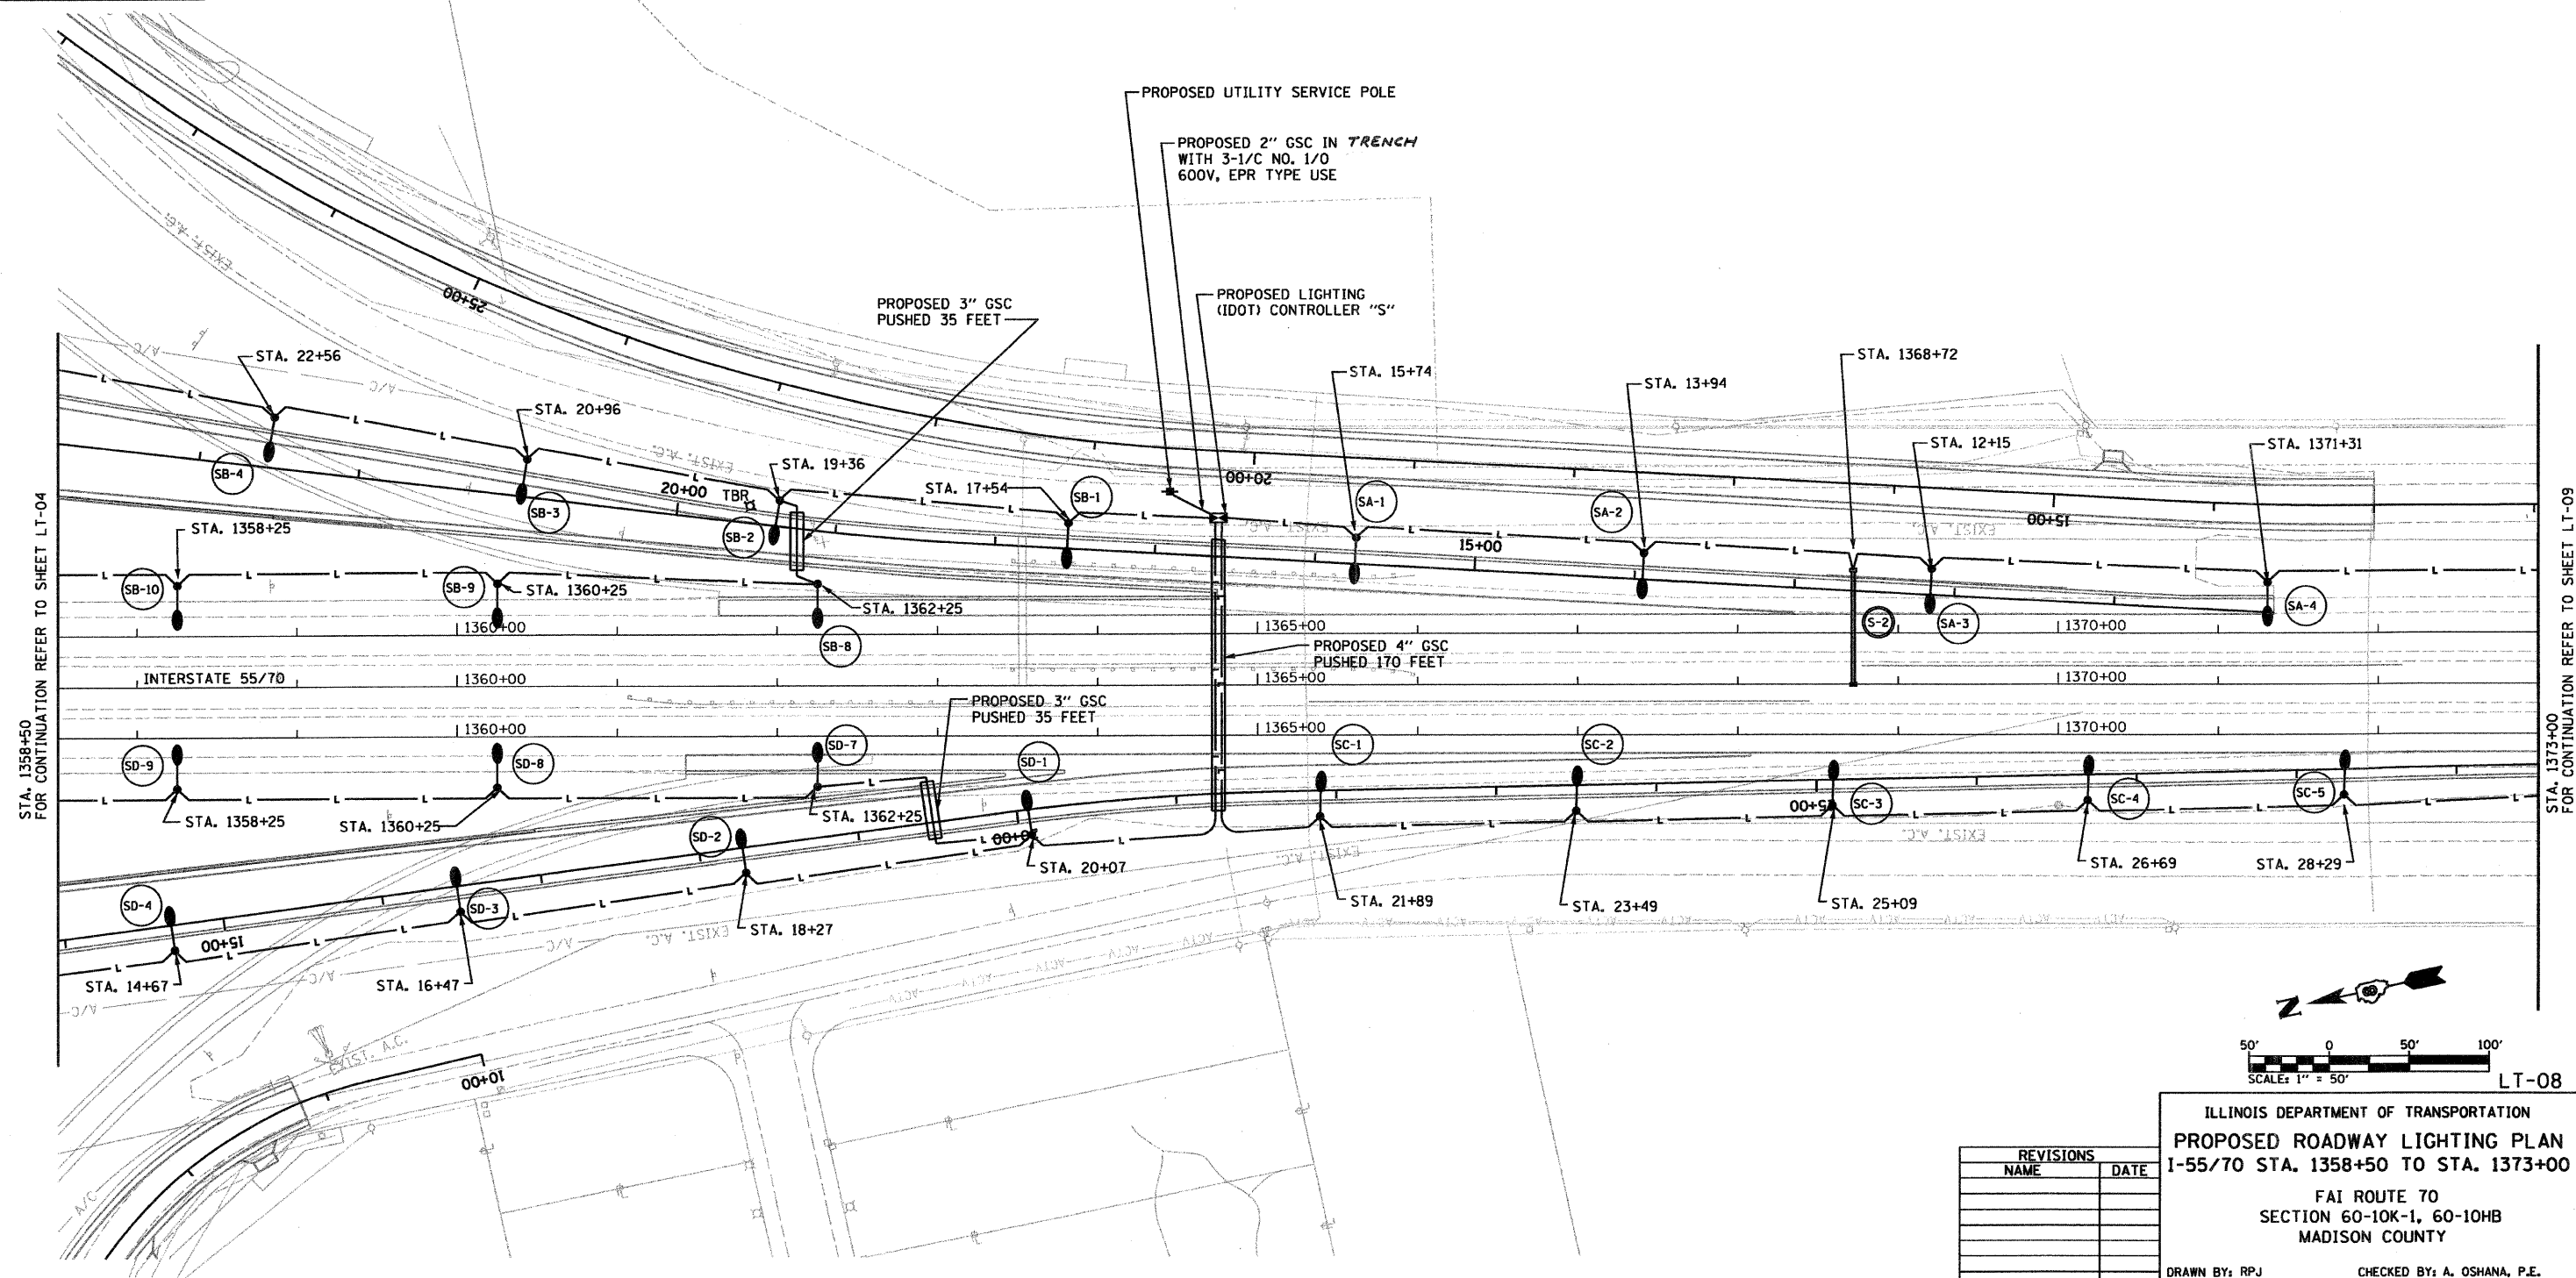

| REVISIONS | |
|-----------|------|
| NAME | DATE |
| | |
| | |
| | |
| | |

ILLINOIS DEPARTMENT OF TRANSPORTATION
PROPOSED ROADWAY LIGHTING PLAN
 I-55/70 STA. 1358+50 TO STA. 1373+00
 FAI ROUTE 70
 SECTION 60-10K-1, 60-10HB
 MADISON COUNTY
 DRAWN BY: RPJ CHECKED BY: A. OSHANA, P.E.

XXXXXX - IDOT IL 162 over I-55.70 revisions
 236-LT-08.dgn
 1/28/2009
 1:49:17 PM
 Robert Swanson