
 
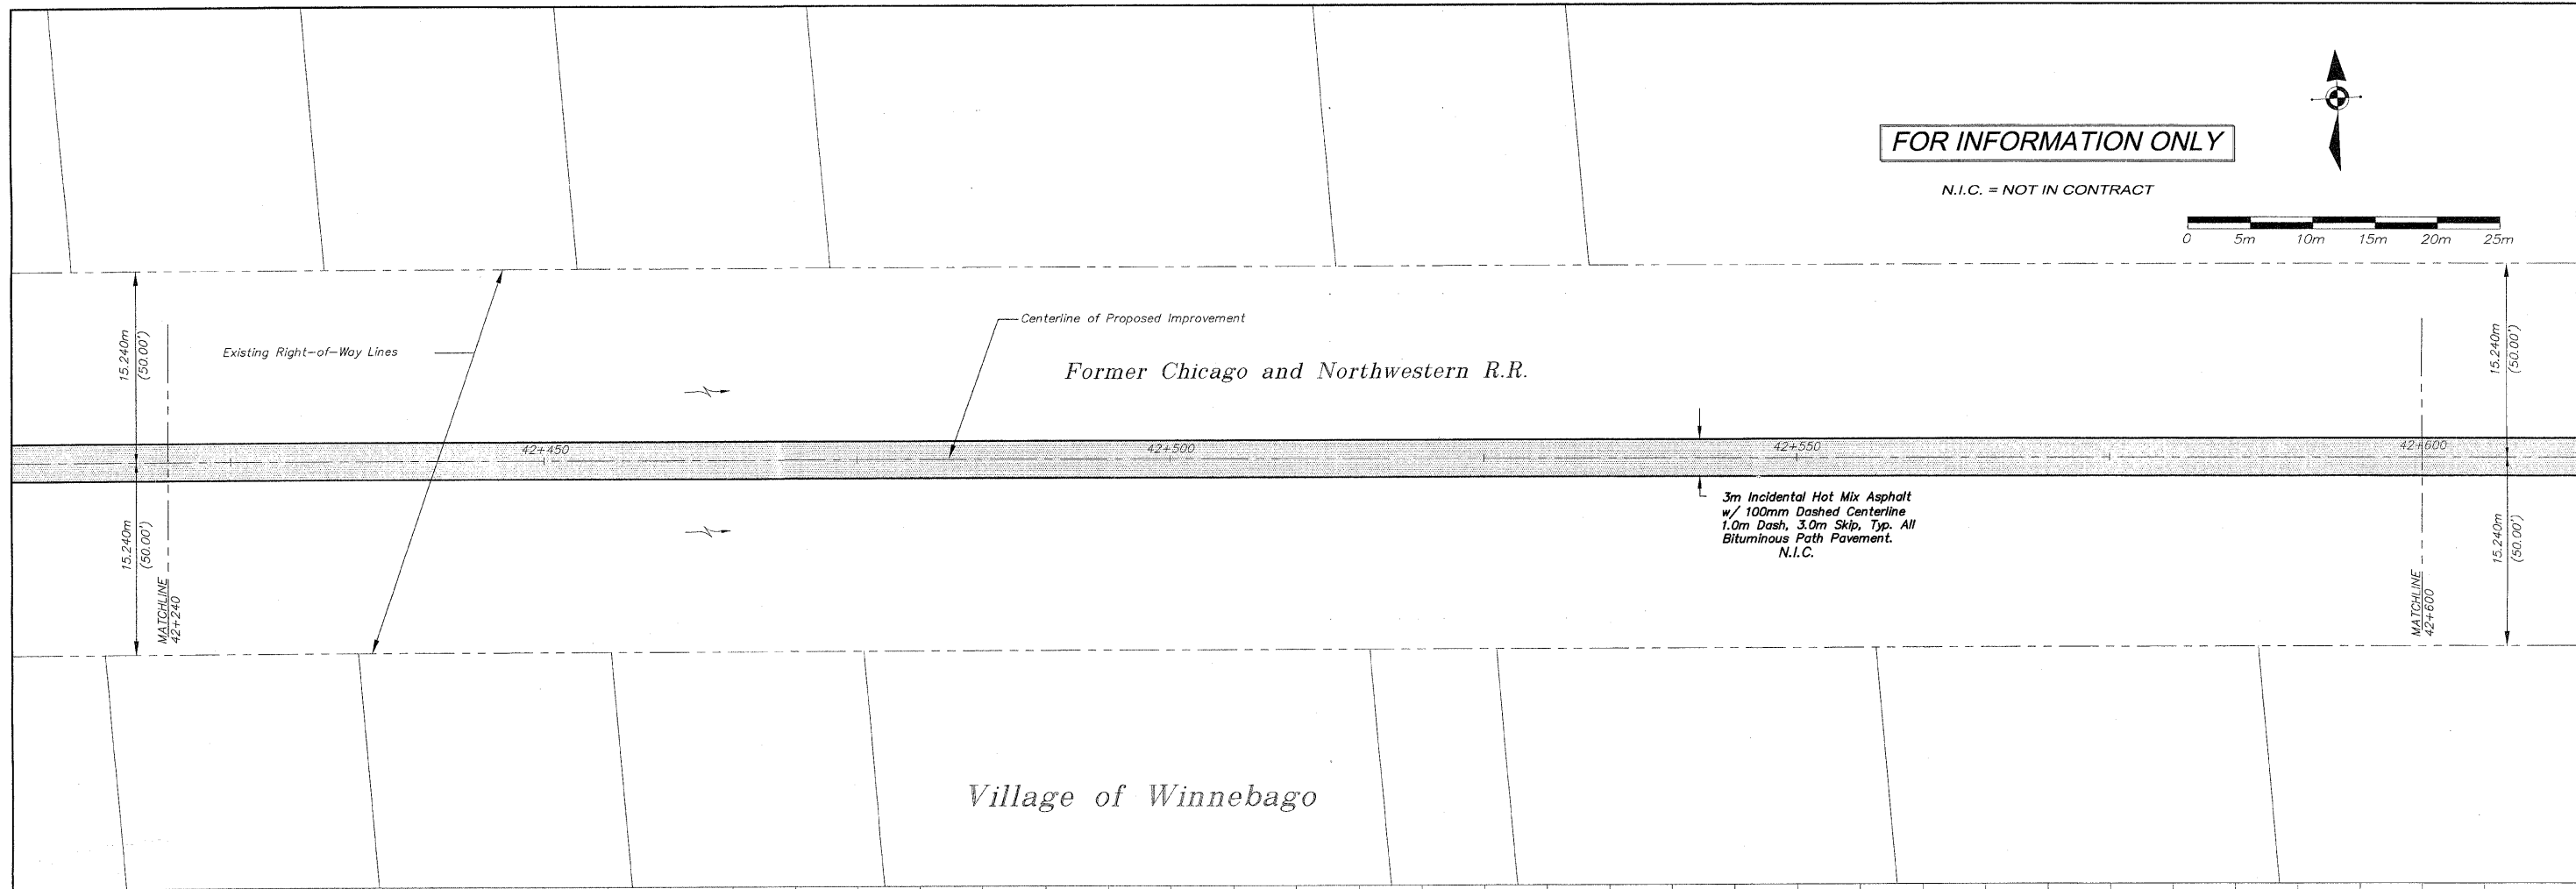


FOR INFORMATION ONLY

N.I.C. = NOT IN CONTRACT



Village of Winnebago

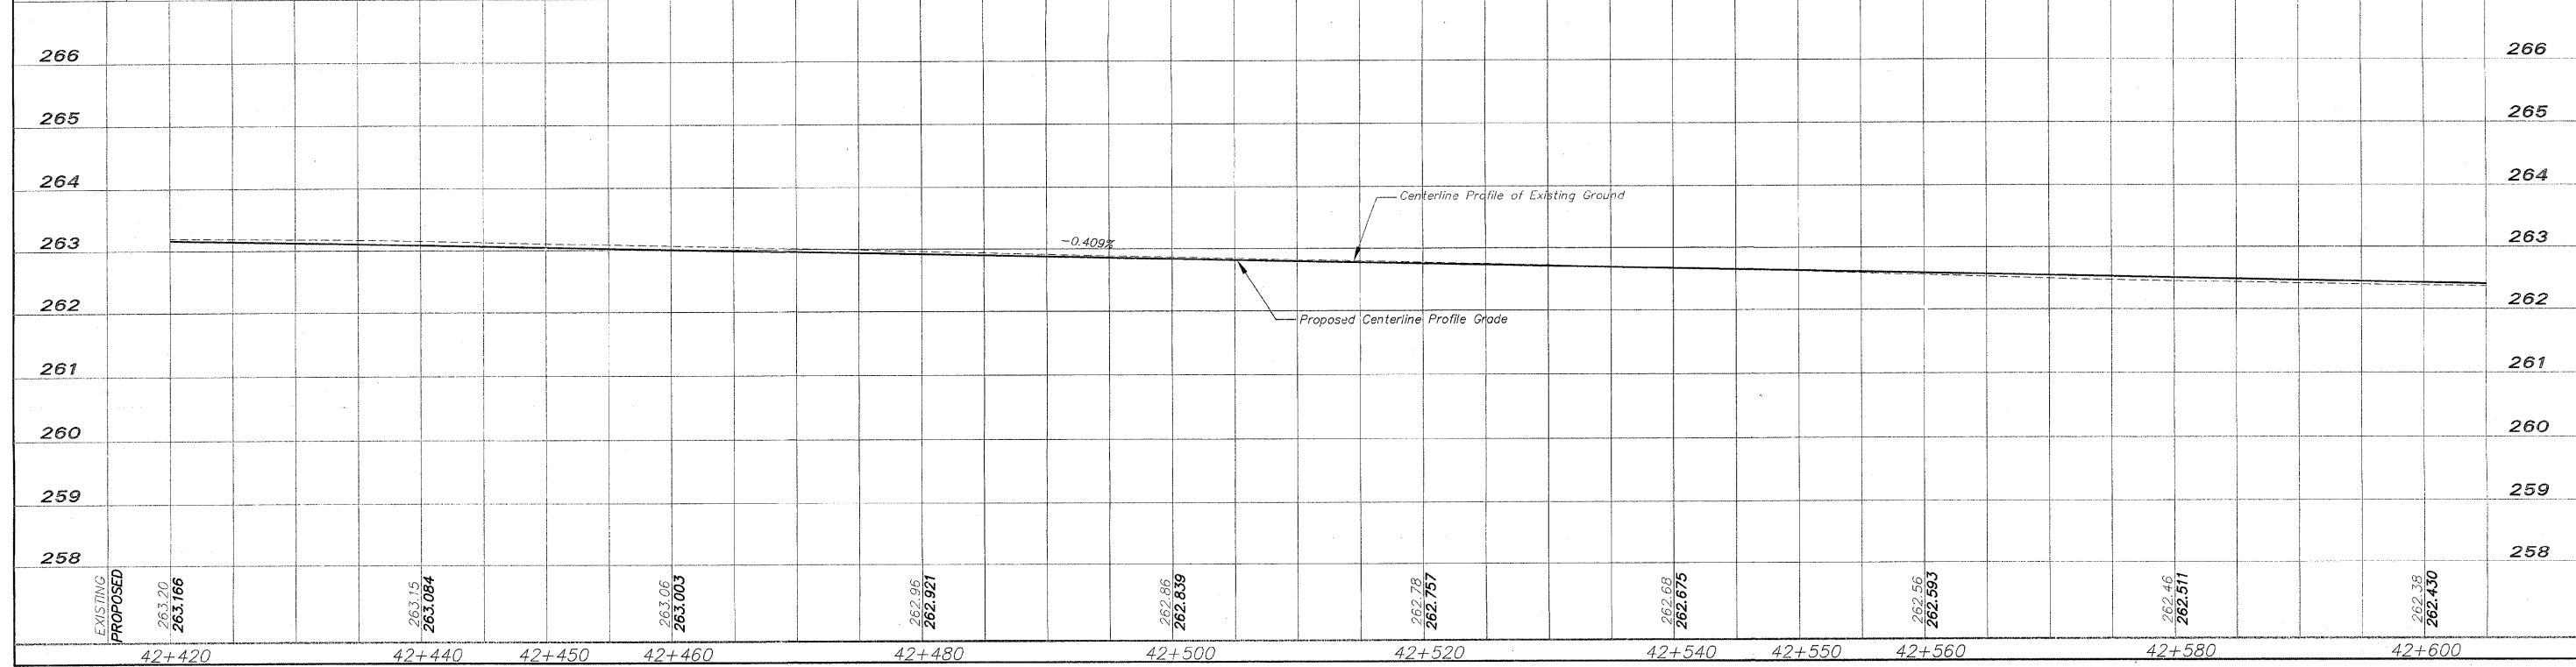

REVISIONS		
NO.	ITEM	DATE
2	REVIEW COMMENTS	1/22/09

PLOTTING SCALE: 1 : 1
 DRAWN BY: REK
 CHECKED BY:
 DATE: DECEMBER, 2008

McClure
 Engineering Associates, Inc.
 7282 Argus Drive
 (815) 398-2332
 Rockford, Illinois 61107-5837
 FAX (815) 398-2496
 Design Firm License: Illinois 184-000816
 Copyright 2006 By McClure Engineering Associates, Inc.

PLAN AND PROFILE 42+420/42+600
 PECATONICA PRAIRIE PATH Contract 85443
 WINNEBAGO COUNTY HIGHWAY DEPARTMENT SECTION 94-00267-00-BT
 FILE NAME: G:\surveys\PECPATH\1ST RELEASE\98-037 pp42+420-42+600.dwg JOB NUMBER: 04-28-98-037

SHEET NO.
23
 OF
98

D:\surveys\PECPATH\1ST RELEASE\98-037 pp42+420-42+600.dwg Layout1, 3/4/2009 11:06:21 AM, 1:1, REK