

STATE OF ILLINOIS
DEPARTMENT OF TRANSPORTATION

PLANS FOR PROPOSED
WARD STREET IMPROVEMENTS

F.A.U. ROUTE 6919

SECTION 06-00139-00-PV

McDONOUGH COUNTY

PROJECT APM5040 (009)

JOB No. C-94-048-07

SCALES

PLAN _____ 1 INCH = 20 FEET
PROFILE HORIZ. _____ 1 INCH = 20 FEET
PROFILE VERT. _____ 1 INCH = 5 FEET
CROSS SECTION HORIZ. _____ 1 INCH = 10 FEET
CROSS SECTION VERT. _____ 1 INCH = 5 FEET

CITY OF MACOMB-WARD STREET
SEC. 06-00139-00-PV F.A.U. 6919
PROJ. M05040 (009)
CO. TRACT No. 89469 SHT 1 OF 59

SHEET NO.
1
of **59**

McClure
Engineering Associates, Inc.
Macomb, Illinois 61455
714 East Jackson Street
13091 833-4594 FAX 13091 837-4909
Design firm License #184-000816 Copyright 2007 by McClure Engineering Associates, Inc.

PLOTTING SCALE: 1" = 1'
DRAWN BY: TAB/AFS
CHECKED BY: zcm
DATE: OCTOBER 2008

NO.	REVISIONS	ITEM	DATE




WARD STREET IMPROVEMENTS
TITLE SHEET
CITY OF MACOMB
SOUTH WARD ST.
FILE NAME: \\MACOMB\WARDST\WARD-57-2007-TYPECDDWG FIELD BOOK No. 2257 JOB NUMBER: 01-28-07002

INDEX OF SHEETS

1. TITLE SHEET
2. GENERAL NOTES, LEGEND AND BENCH MARKS
3. SUMMARY OF QUANTITIES
4. TYPICAL SECTIONS
- 5.-6. SCHEDULE OF QUANTITIES
- 7.-13. ROADWAY PLAN AND PROFILES
- 14.-15. HORIZONTAL CONTROL POINTS
- 16.-18. REMOVAL PLANS
- 19.-24. STORM SEWER PLAN AND PROFILE
25. WATER MAIN ADJUSTMENT PLAN, MATERIALS AND NOTES
- 26.-27. PAVEMENT MARKING PLANS
- 28.-32. CONSTRUCTION STAGING PLANS
- 33.-34. INTERSECTION DETAILS
- 35.-36. TYPICAL CONSTRUCTION DETAILS
37. TYPICAL WATER MAIN DETAILS
- 38.-39. STORM WATER POLLUTION PREVENTION PLANS
- 40.-59. CROSS SECTIONS

HIGHWAY STANDARDS

000001-05	602301-02	701311-03
280001-04	602306-02	701501-05
420001-07	602401-02	701801-04
420101-04	602601-02	701901-01
420106-04	602701-02	720001-01
420111-02	604001-03	720006-02
424001-05	604006-04	720011-01
542301-02	604011-04	729001-01
542306-02	604036-02	780001-02
602101-02	606001-04	BLR 21-8
602411-01	701006-03	BLR 22-6
	701301-03	

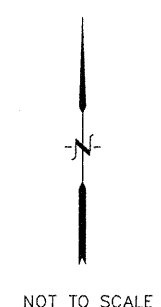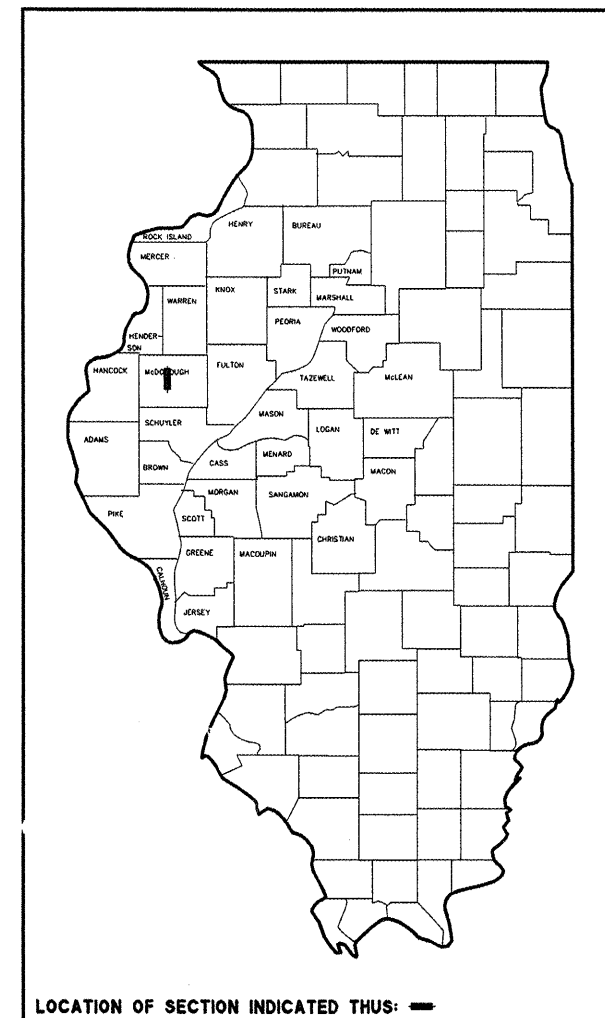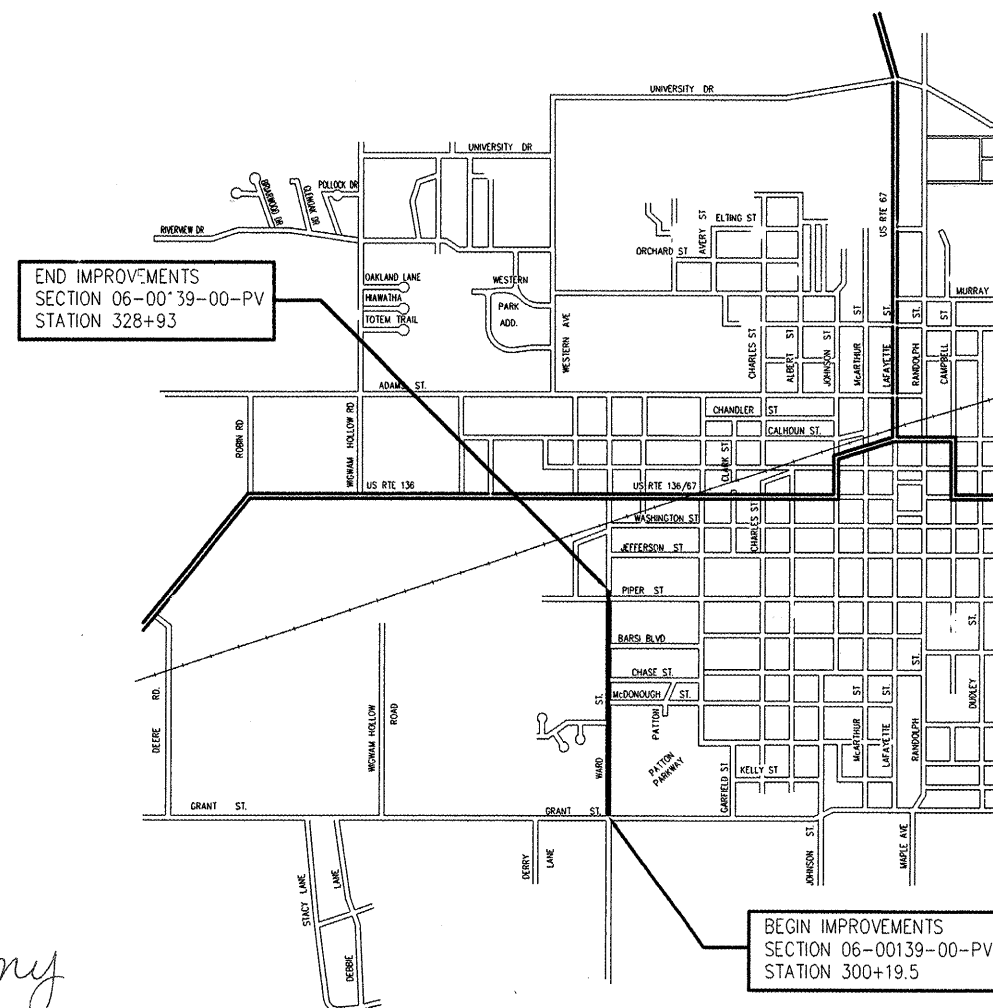

APPROVED 1-13 20 09
Mark Winkler
LOCAL AGENCY / CITY OF MACOMB (MAYOR)

PASSED 1-30 20 09
Daryl C. Paie
DISTRICT ENGINEER OF LOCAL ROADS & STREETS

RELEASING FOR BID
BASED ON LIMITED
REVIEW JAN 30 20 09
[Signature]
DEPUTY DIRECTOR OF HIGHWAYS, REGION 3 ENGINEER

STATE OF ILLINOIS
DEPARTMENT OF TRANSPORTATION



Jessica A. Remy
1/13/09
Expires 11/30/09



CALL J.U.L.I.E. BEFORE YOU DIG
1-800-892-0123
TOLL FREE

CONTRACT No. 89469

LENGTH OF PROJECT = 2873.5 FEET = 0.544 MILES
NET LENGTH OF IMPROVEMENT = 2873.5 FEET = 0.544 MILES
DESIGN CLASS: COLLECTOR - ADT = 4200
DESIGN SPEED: 30 MPH
DESIGN GUIDELINES: URBAN (BLRS MANUAL CHAPTER 32)