
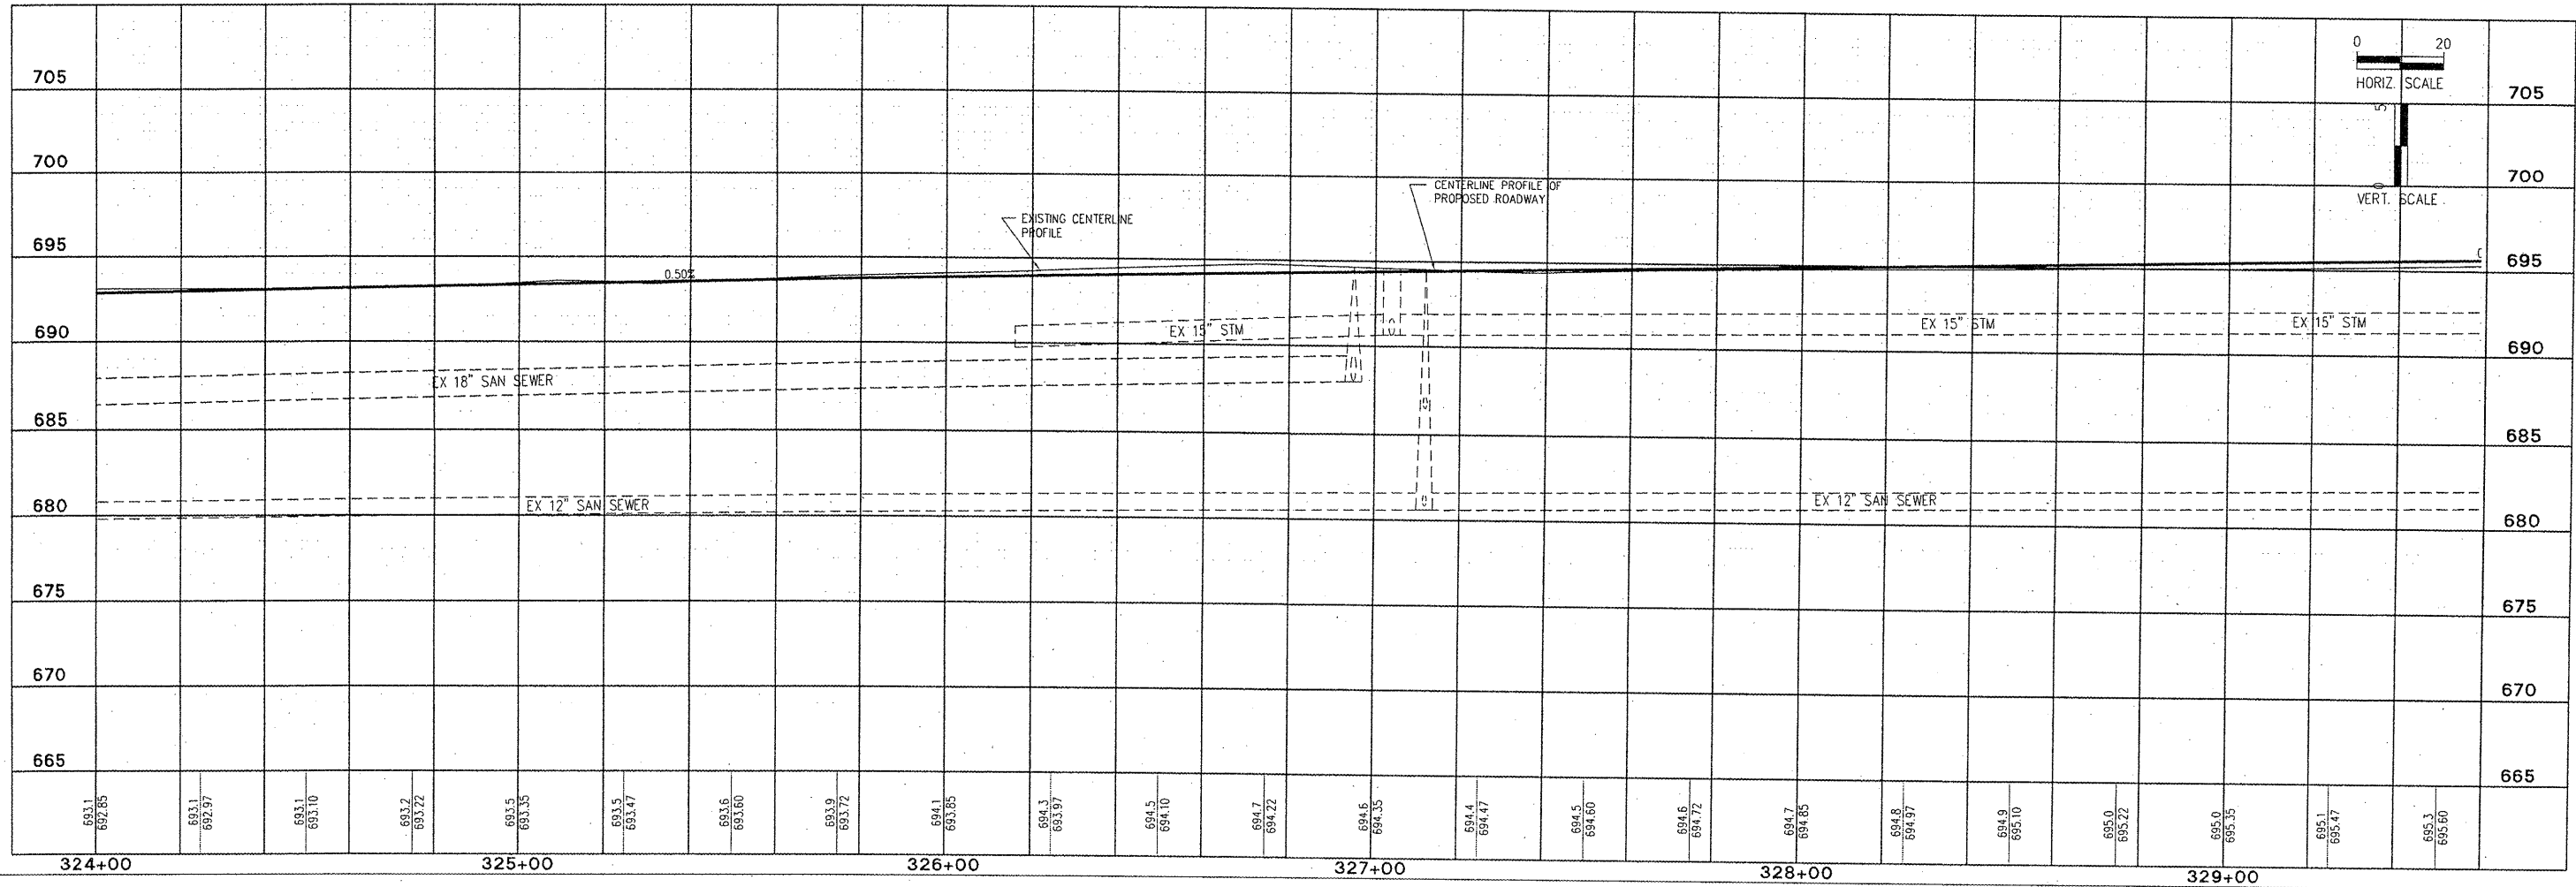


McClure
 Engineering Associates, Inc.
 Macomb, Illinois 61455
 714 East Jackson Street
 (309) 837-8909
 Design Firm License #184-000816 Copyright 2008 by McClure Engineering Associates, Inc.

MATCHLINE STA. 324+00

MATCHLINE STA. 5+75

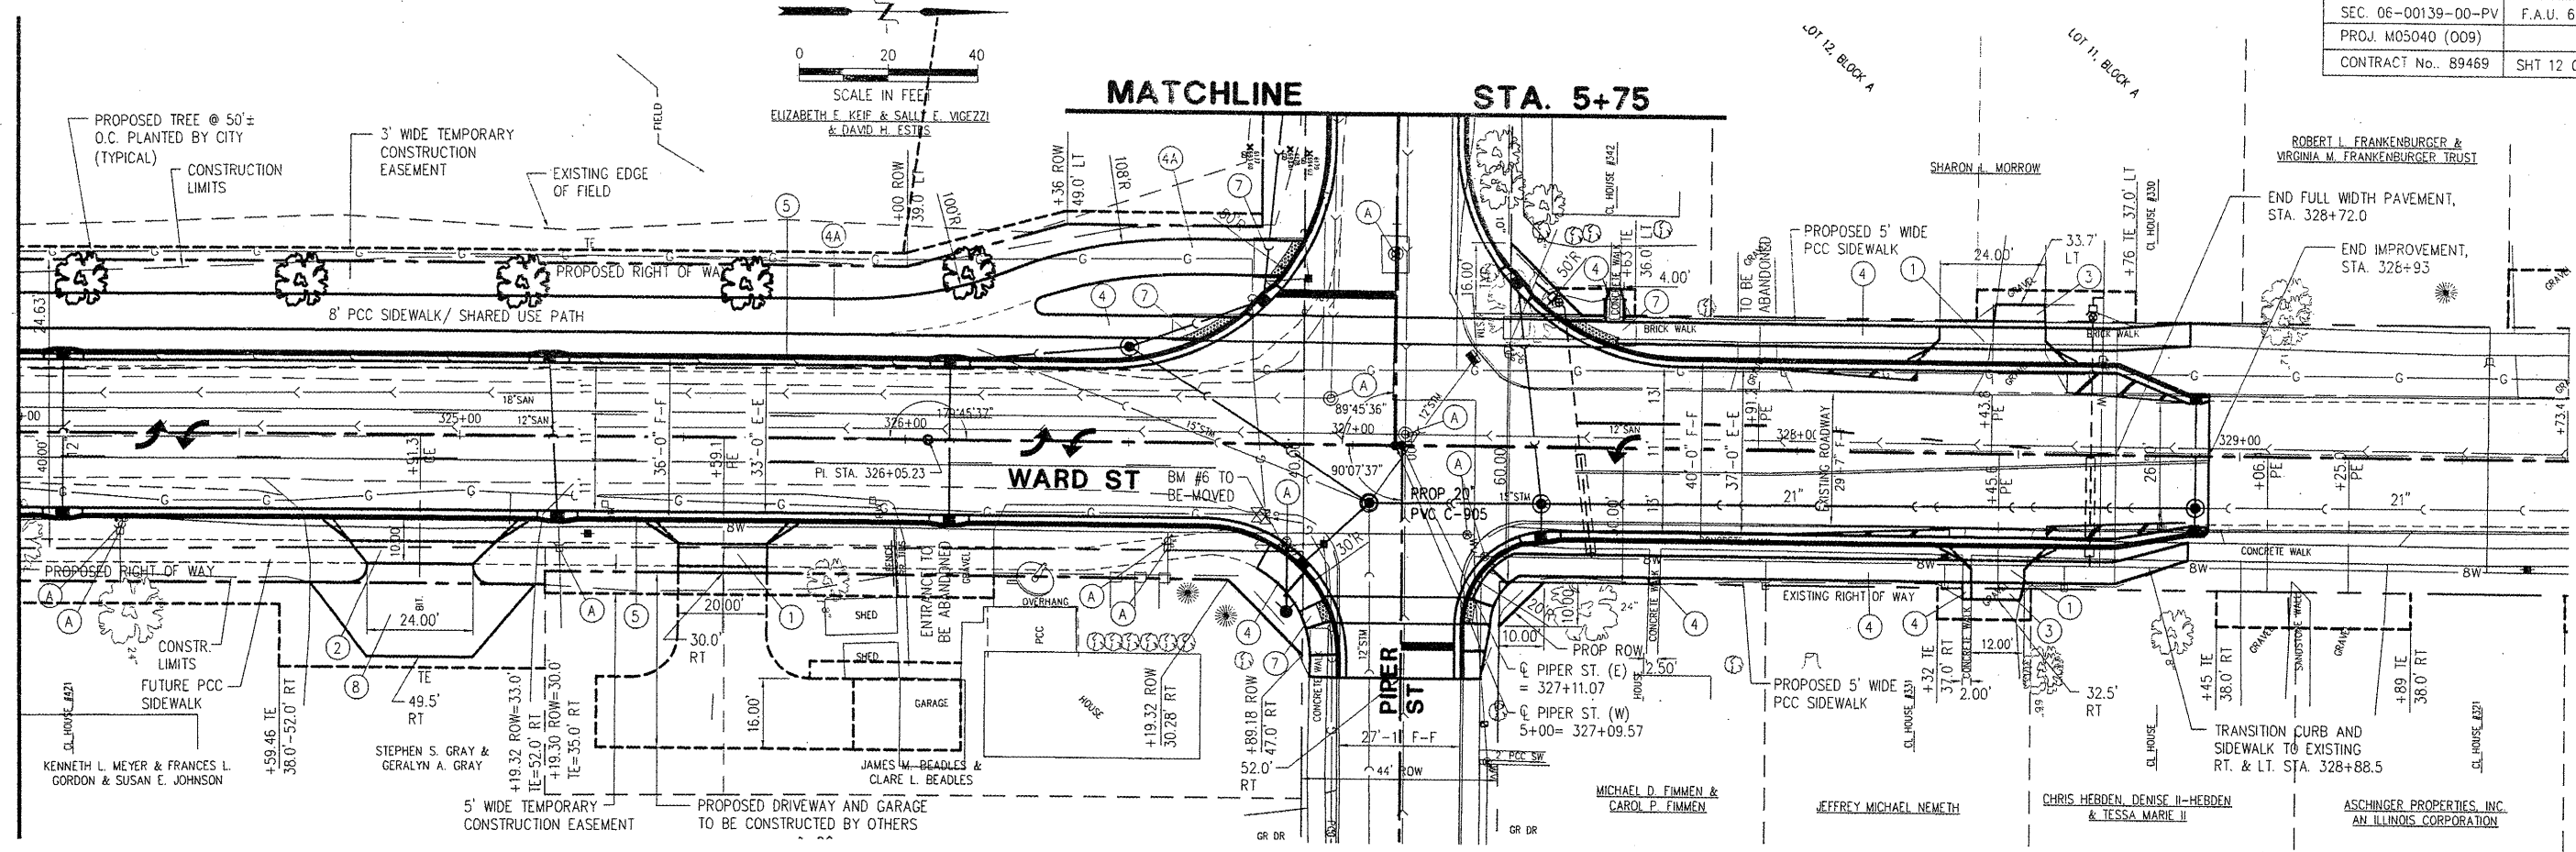

PLOTTING SCALE: 1" = 20'
 DRAWN BY: TAB/APS
 CHECKED BY: ECM
 DATE: OCTOBER 2008

NO.	REVISIONS	DATE

WARD STREET IMPROVEMENTS
PLAN AND PROFILE - STA. 324+00 TO 329+00
 CITY OF MACOMB
 SOUTH WARD ST.
 FILE NAME: W:\DRAWINGS\MACOMB\WARDST\WARD-ST-2007
 FIELD BOOK No. 2257 JOB NUMBER: 01-28-0809
 MACOMB, ILLINOIS