


McClure
Engineering Associates, Inc.
714 East Jackson Street
Macomb, Illinois 61455
13091 833-4594 FAX 13091 837-4909
Design Firm License #194-000816 Copyright 2008 by McClure Engineering Associates, Inc.

PLOTTING SCALE:	1" = 20'
DRAWN BY:	TAB/APS
CHECKED BY:	ECM
DATE:	OCTOBER 2008

NO.	REVISIONS	DATE

WARD STREET IMPROVEMENTS
PLAN AND PROFILE - PIPER STREET WEST
CITY OF MACOMB
SOUTH WARD ST.
FILE NAME: W:\DRAWINGS\MACOMB\WARD-ST-2007 FIELD BOOK No. 2257 JOB NUMBER: 03-28-08098

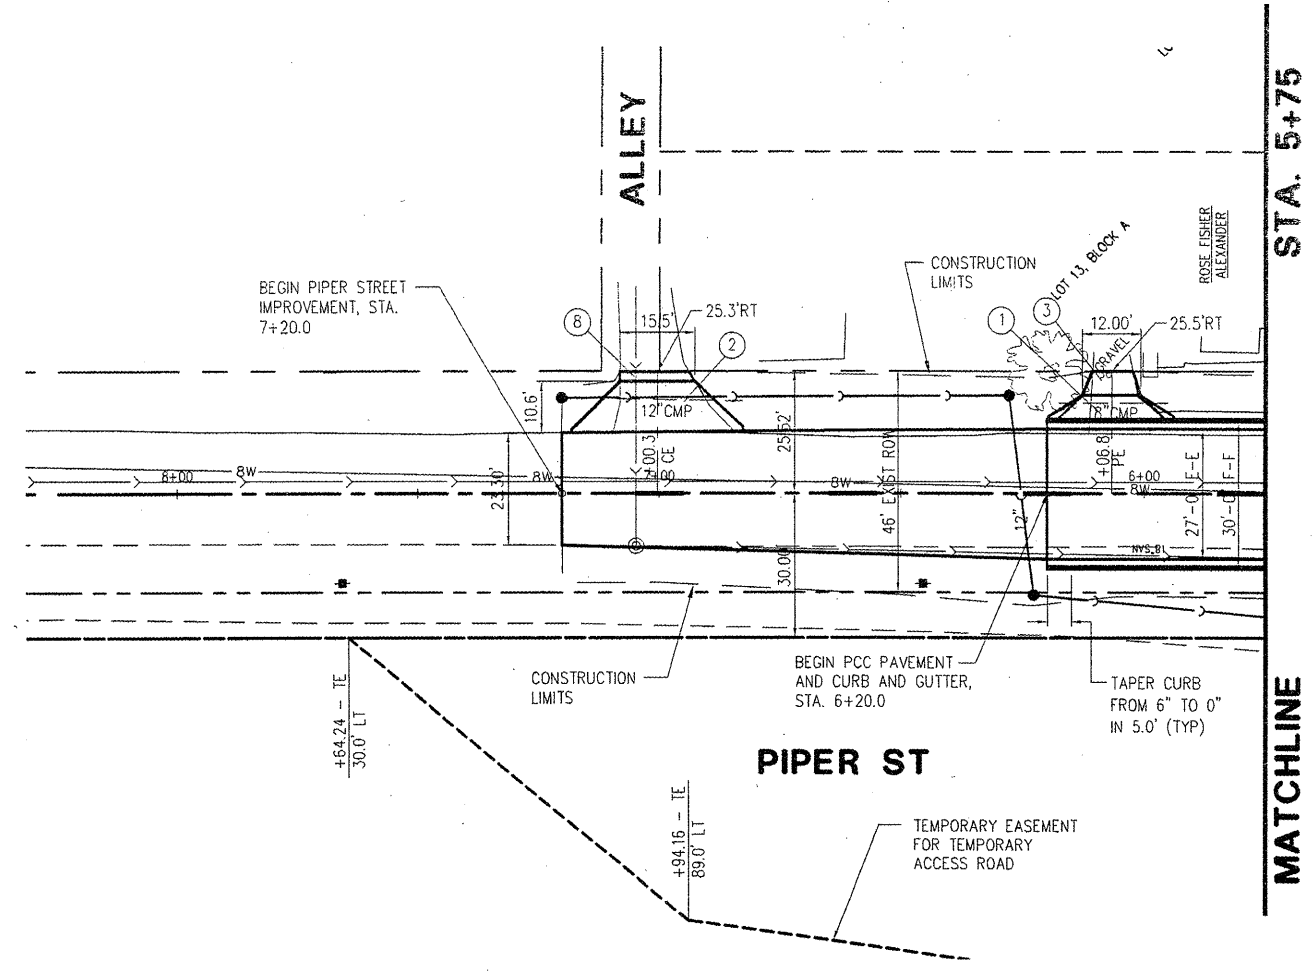

- ITEM LEGEND**
- ① PCC DRIVEWAY PAVEMENT, 6"
 - ② PCC DRIVEWAY PAVEMENT, 7"
 - ③ AGGREGATE SURFACE COURSE, TYPE A, 6"
 - ④ PCC SIDEWALK, 4"
 - ④A PCC SIDEWALK 5"
 - ⑤ COMB. CONC. CURB & GUTTER, TYPE B6.18
 - ⑥ CONCRETE CURB, TYPE B, 6"
 - ⑦ SIDEWALK RAMP W/ DETECTABLE WARNING
 - ⑧ AGGREGATE SURFACE COURSE, TYPE A, 8"
 - Ⓐ MANHOLE, VALVE BOX, WATER SERVICE BOX OR METER VAULT TO BE ADJUSTED

