


STORM INL-63 INLET SPECIAL No. 1 STA. 304+30, 17.75' LT EP=676.39 IE=673.12(E) IE=672.21(N)	STORM INL-62 INLET TY B 2", SALV FR&GR STA. 305+11.75, 23.7' LT EP=675.77 IE=671.80(S) IE=671.70(N)	STORM INL-60 INLET TY B, 3", TY 3 FR&GR STA. 305+72.2, 24.2' LT EP=675.53 IE=671.39(S) IE=671.14(N) IE=672.86(W)	STORM INL-58 INLET SPECIAL No. 2 STA. 305+97, 17.75' LT EP=675.56 IE=672.54(N)	STORM MH-N MH TY A, 7", TY 1 FR&OL STA. 306+33, 25' LT RIM=676.06 IE=672.39(NE,SE) IE=669.90(S) IE=667.60(N) IE=667.50(E)	STORM INL-56 INLET SPECIAL No. 1 STA. 306+50, 17.75' LT EP=675.65 IE=672.63(S)	STORM INL-54 INLET SPECIAL No. 1 STA. 307+50, 17.75' LT EP=676.25 IE=673.59(E) IE=672.00(W)	STORM MH-M MH TY A, 5", TY 1 FR&OL STA. 307+50, 25' LT RIM=676.77 IE=671.97(E) IE=670.98(N) IE=668.51(S)	STORM MH-L MH TY A, 5", TY 1 FR&OL STA. 308+70, 25' LT RIM=676.20 IE=673.61(E) IE=672.25(N) IE=672.00(S)	STORM INL-52 INLET SPECIAL No. 1 STA. 308+70, 17.75' LT EP=677.54 IE=674.65(E) IE=673.64(W)
---	---	---	---	---	---	---	---	---	---


CITY OF MACOMB-WARD STREET	
SEC. 06-00139-00-PV	F.A.U. 6919
PROJ. M05040 (009)	
CONTRACT No. 89469	SHT 19 OF 59

SHEET NO.
19
of **59**

McClure Engineering Associates, Inc.
Macomb, Illinois 61455
714 East Jackson Street
(309) 833-4994
FAX (309) 637-4909
Design firm License #184-000816 Copyright 2008 by McClure Engineering Associates, Inc.

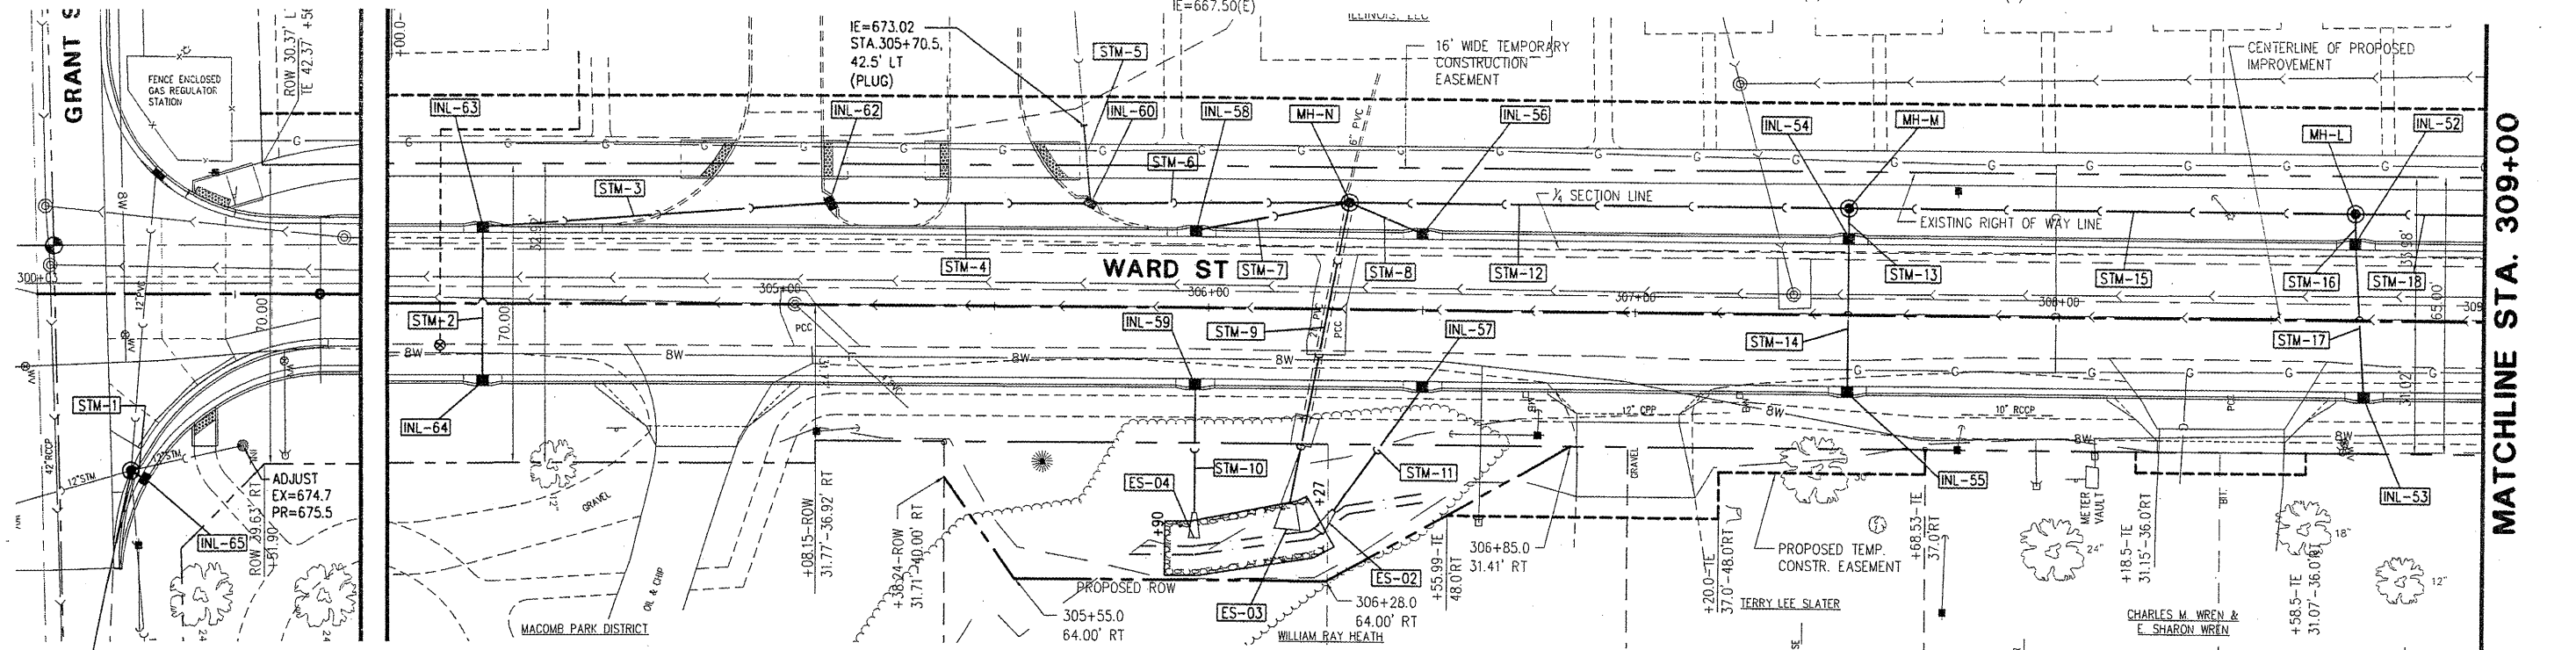

MANHOLE ADJUST WITH NEW TY 1 FR&OL	STORM INL-65 INLET TY A 2" TY 3V FR&GR STA. 300+28.8, 43.1' RT EP=675.96 IE=672.40(SW)	STORM INL-64 INLET SPECIAL No. 1 STA. 304+30, 17.75' RT EP=676.39 IE=673.30(W)	STORM INL-59 INLET SPECIAL No. 2 STA. 305+97, 17.75' RT EP=675.56 IE=671.54(NE)	STORM ES-04 PRC CONC FLAR END SEC. 12" STA. 305+97, 54' RT IE=667.70	STORM ES-03 PRC CONC FLAR END SEC. ELLIP EQRS 30" STA. 306+19, 52' RT IE=667.13	STORM ES-02 PRC CONC FLAR END SEC. 12" STA. 306+26, 52' RT IE=669.50	STORM INL-57 INLET SPECIAL No. 1 STA. 306+50, 17.75' RT EP=675.65 IE=671.93(SE)	STORM INL-55 INLET SPECIAL No. 1 STA. 307+25, 17.75' RT EP=676.25 IE=673.75(W)	STORM INL-53 INLET SPECIAL No. 1 STA. 308+72, 17.75' RT EP=677.57 IE=674.81(W)
---	---	---	--	--	--	--	--	---	---

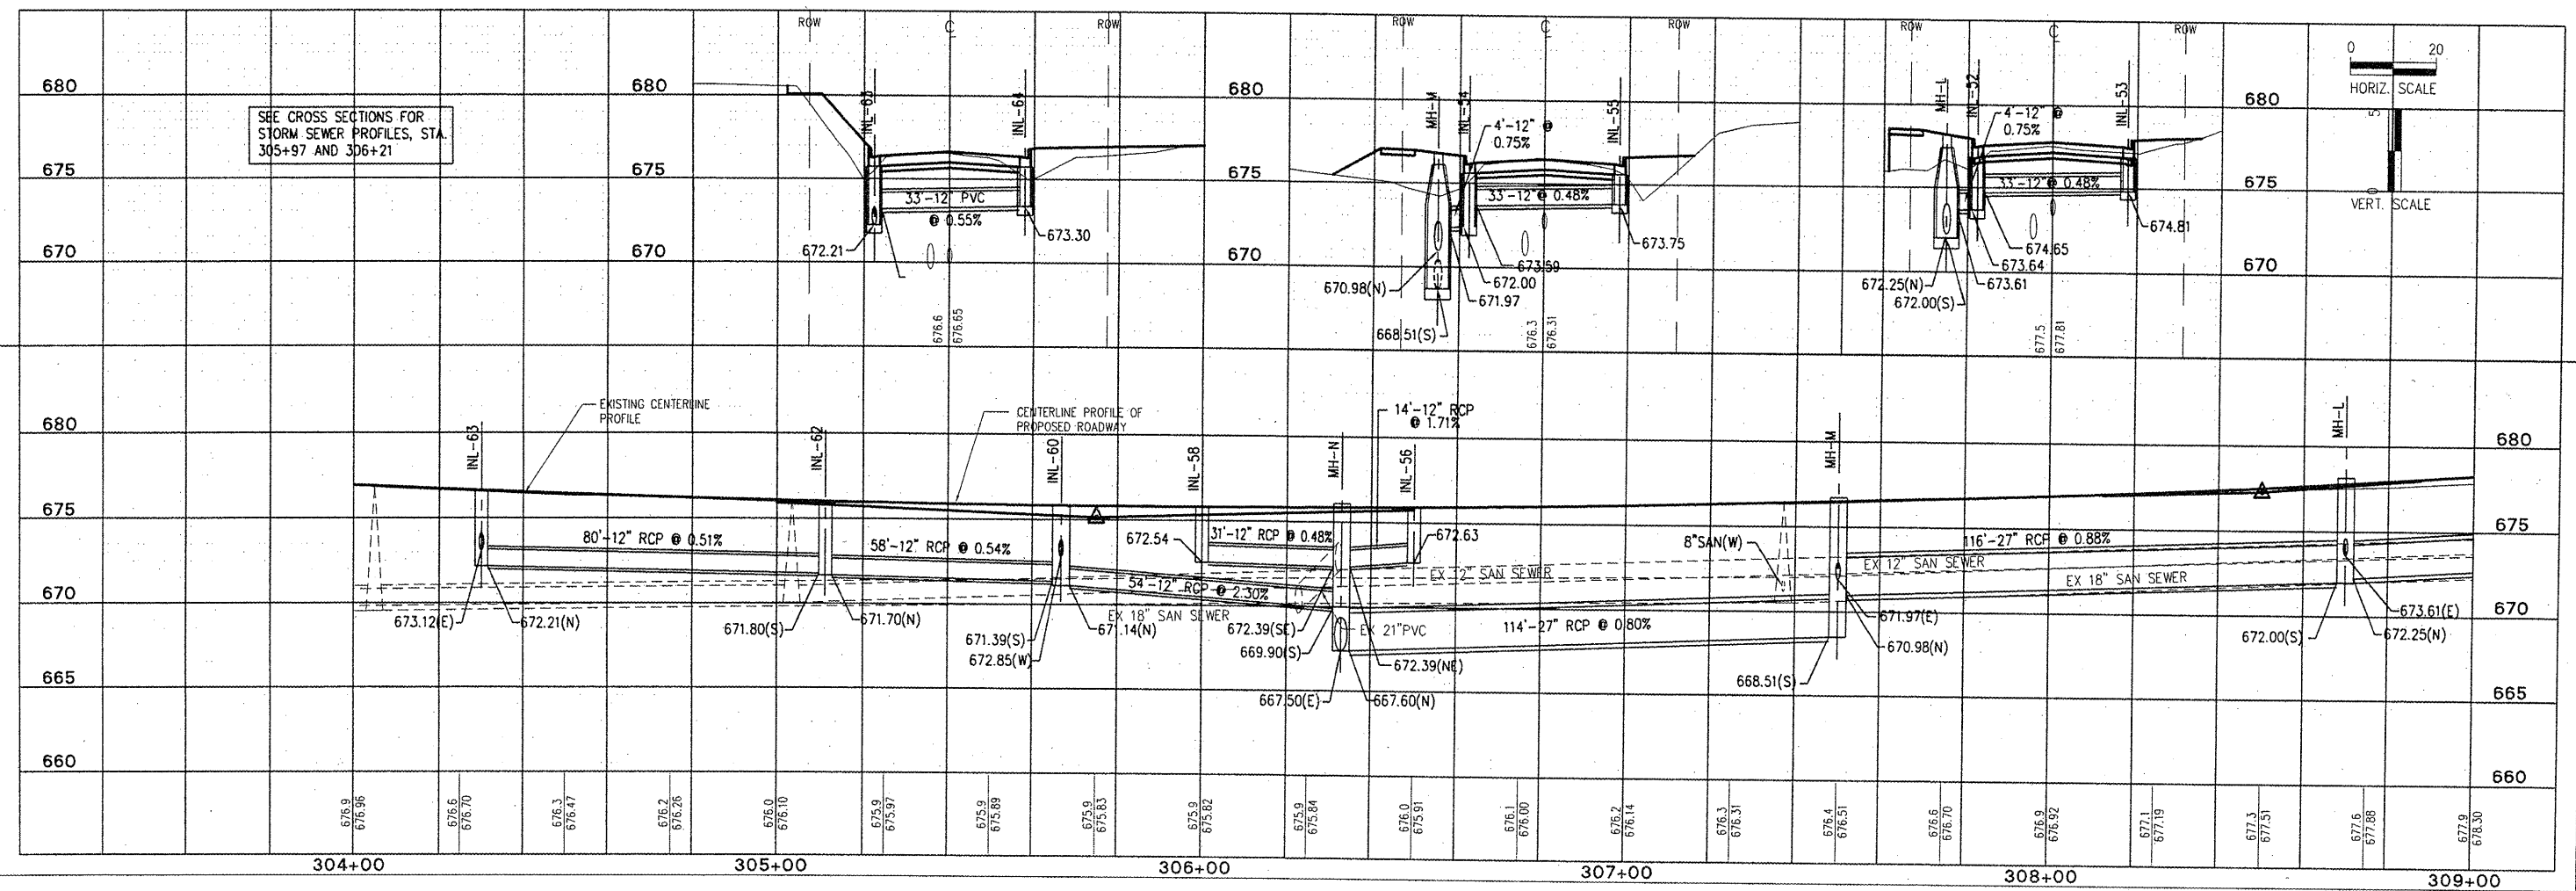

PLOTTING SCALE: 1" = 20'
DRAWN BY: TAG
CHECKED BY: ECM
DATE: OCTOBER 2008

NO.	REVISIONS	DATE

WARD STREET IMPROVEMENTS
STORM SEWER PLAN AND PROFILE - STA. 304+00 TO 309+00
CITY OF MACOMB
SOUTH WARD ST.
FILE NAME: W:\DRAWINGS\MACOMB\WARDST\WARD-ST-2007 FIELD BOOK No. 2257 JOB NUMBER: 01-26-0809B
MACOMB, ILLINOIS