

MATCHLINE STA. 309+00

MATCHLINE STA. 314+00

STORM ES-01
 PRC CONC FLAR END SEC, 15"
 STA. 309+83, 49.5' LT
 IE=676.50

STORM MH-K
 MH TY A, 5', TY 1 FR&OL
 STA. 309+83, 25' LT
 RIM=680.15
 IE=675.71(W)
 IE=675.62(NE)
 IE=674.34(N)
 IE=673.94(S)



STORM INL-50
 INLET SPECIAL No. 1
 STA. 309+90, 17.75' LT
 EP=679.80
 IE=675.77(E)
 IE=675.67(SW)

STORM INL-48
 MANHOLE SPECIAL TYPE 1
 STA. 312+30, 18.5' LT
 RIM=684.19
 IE=680.31(E)
 IE=677.91(N)
 IE=677.06(S)

STORM INL-45
 INLET TY A 2' TY 3 FR&GR
 STA. 313+27.1, 44.0' LT
 EP=684.45
 IE=681.15(E)

| | |
|------------------------------|--------------|
| CITY OF MACOMB - WARD STREET | |
| SEC. 06-00139-00-PV | F.A.U. 6919 |
| PROJ. M05040 (009) | |
| CONTRACT No. 89469 | SHT 20 OF 59 |


SHEET NO.
20
 of **59**

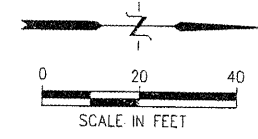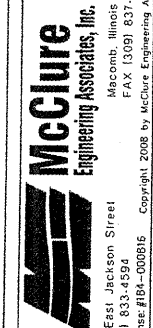

STORM INL-46
 MH TY A, 5', FR&GR No. 1
 STA. 313+33.3, 22.35' LT
 EP=685.11
 IE=678.95(S)
 IE=679.05(N)
 IE=681.05(W)



STORM INL-43
 MANHOLE SPECIAL TYPE 1
 STA. 313+90, 18.5' LT
 EP=685.77
 IE=681.88(E)
 IE=679.59(S)
 IE=679.69(N)

STORM INL-44
 INLET SPECIAL No. 1
 STA. 313+90, 17.75' RT
 EP=685.77
 IE=682.04(W)

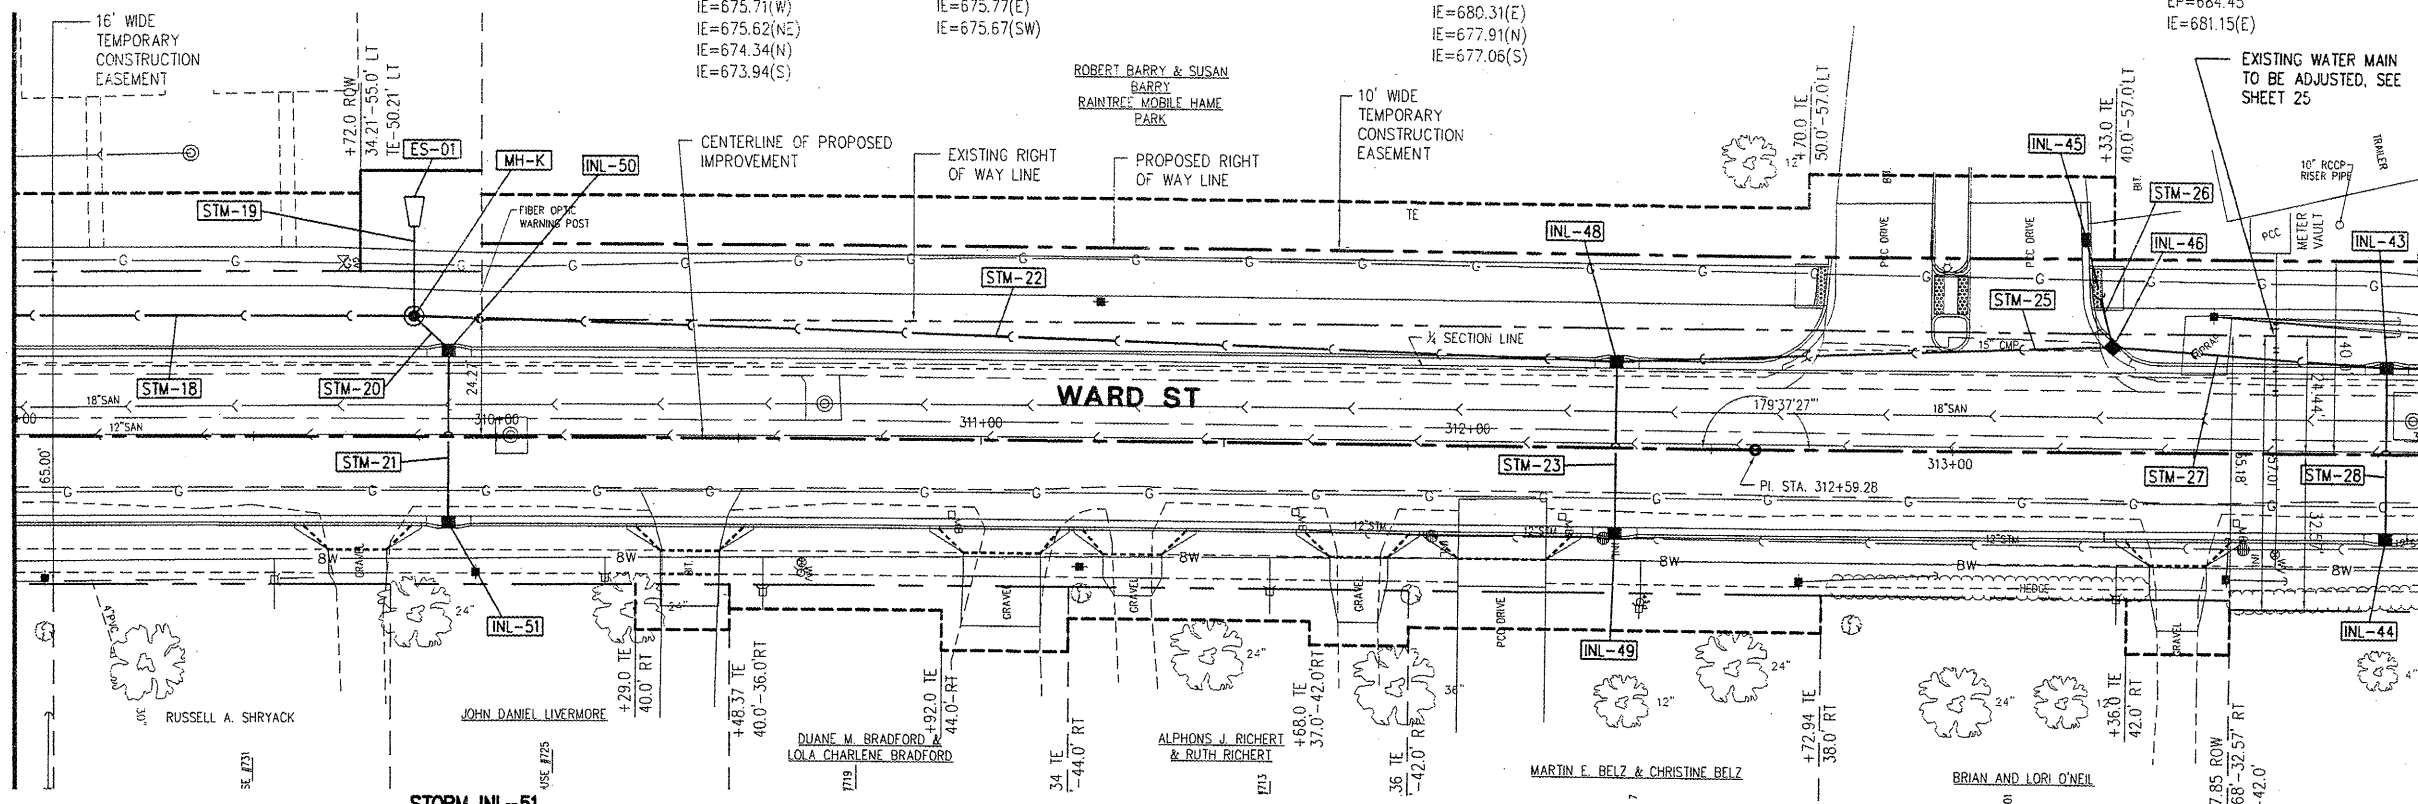

STORM INL-51
 INLET SPECIAL No. 1
 STA. 309+90, 17.75' RT
 EP=679.80
 IE=675.94(W)

STORM INL-49
 INLET SPECIAL No. 1
 STA. 312+30, 17.75' RT
 EP=684.19
 IE=680.47(W)

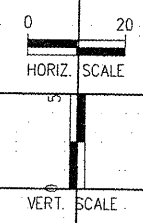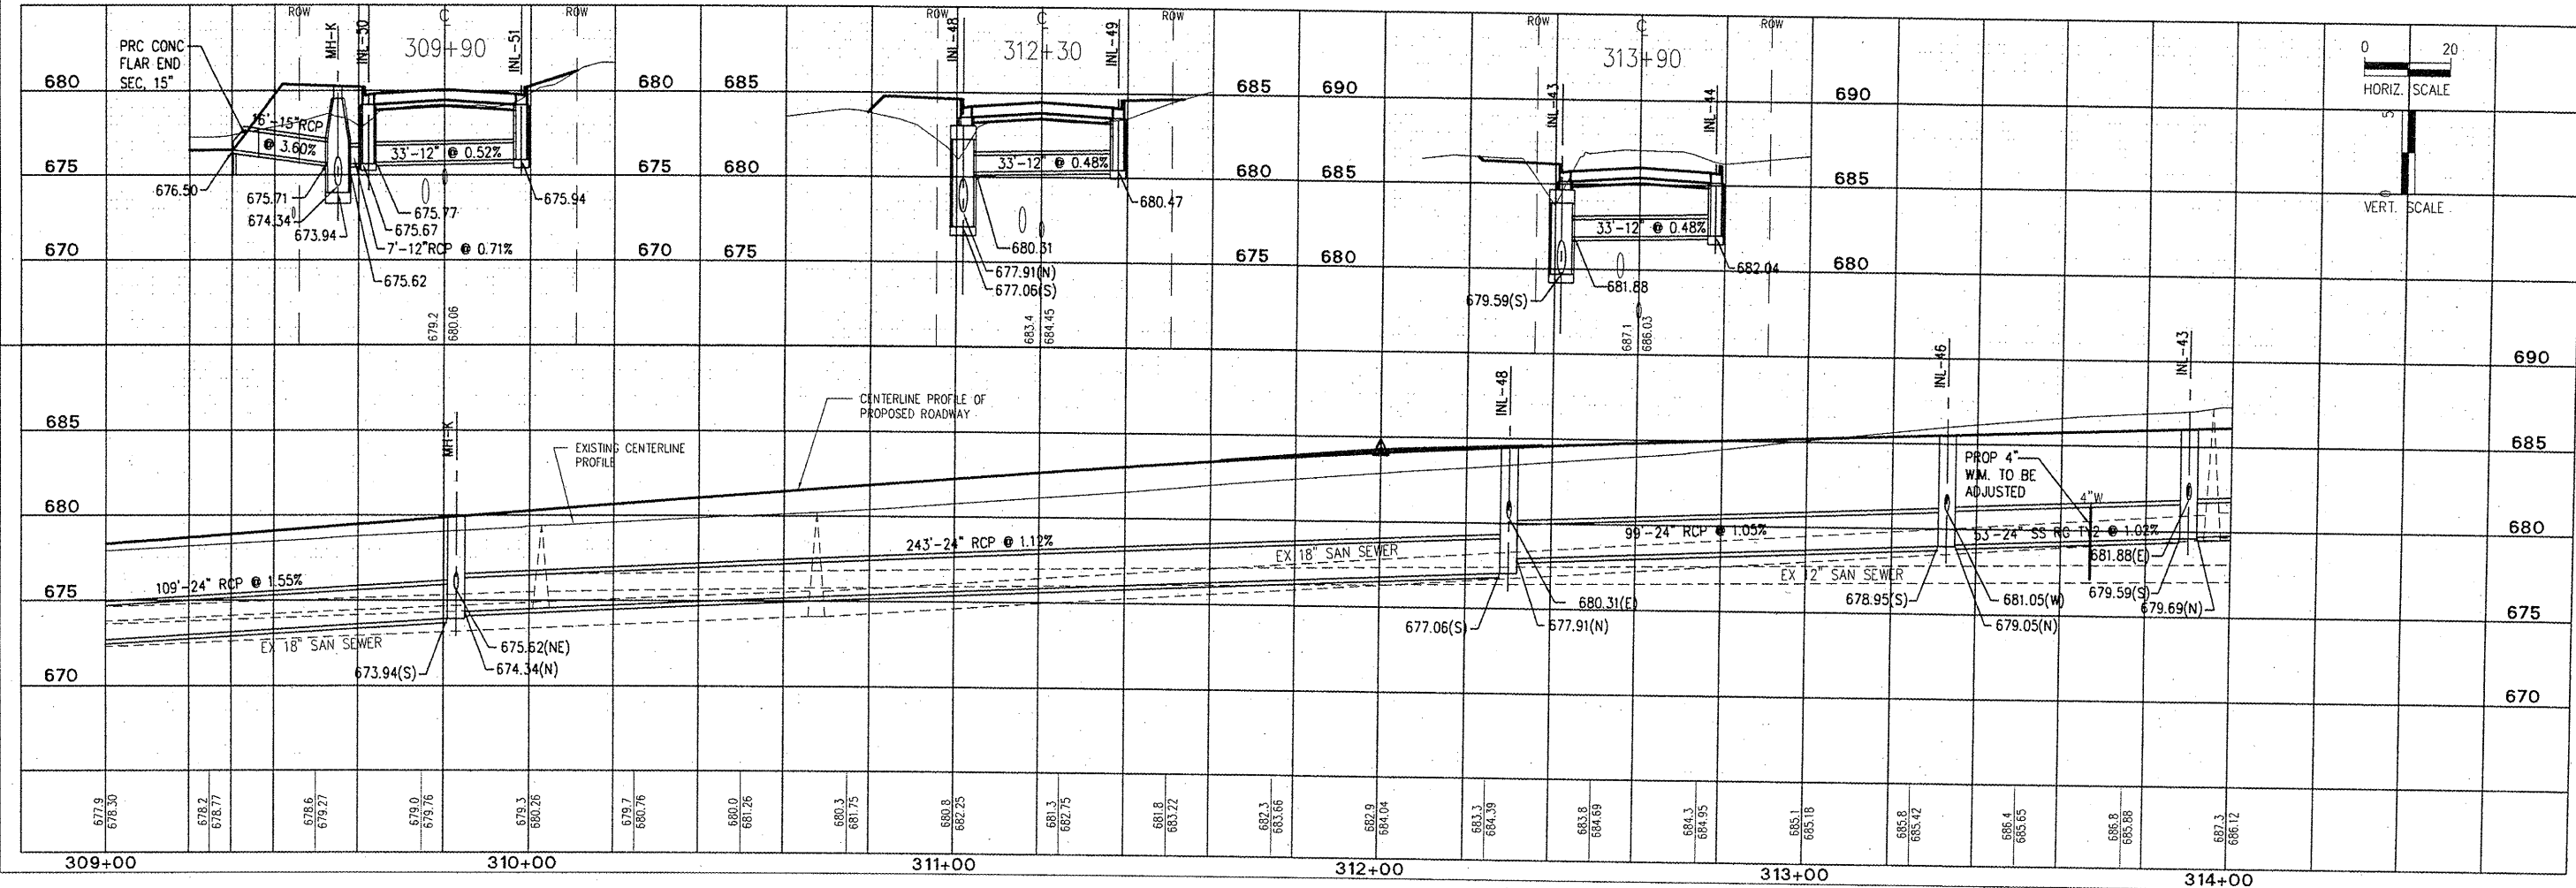

| NO. | REVISIONS | DATE |
|-----|-----------|------|
| | | |
| | | |
| | | |

WARD STREET IMPROVEMENTS
STORM SEWER PLAN AND PROFILE - STA. 309+00 TO 314+00
 CITY OF MACOMB
 SOUTH WARD ST.
 FILE NAME: W:\DRAWINGS\MACOMB\WARDST\WARD-ST-2007
 FIELD BOOK No. 2257 JOB NUMBER: 03-28-08098
 MACOMB, ILLINOIS

| | |
|-----------------|--------------------|
| DRAWN BY: TAB | DATE: OCTOBER 2008 |
| CHECKED BY: ECV | |
| DATE: | |