
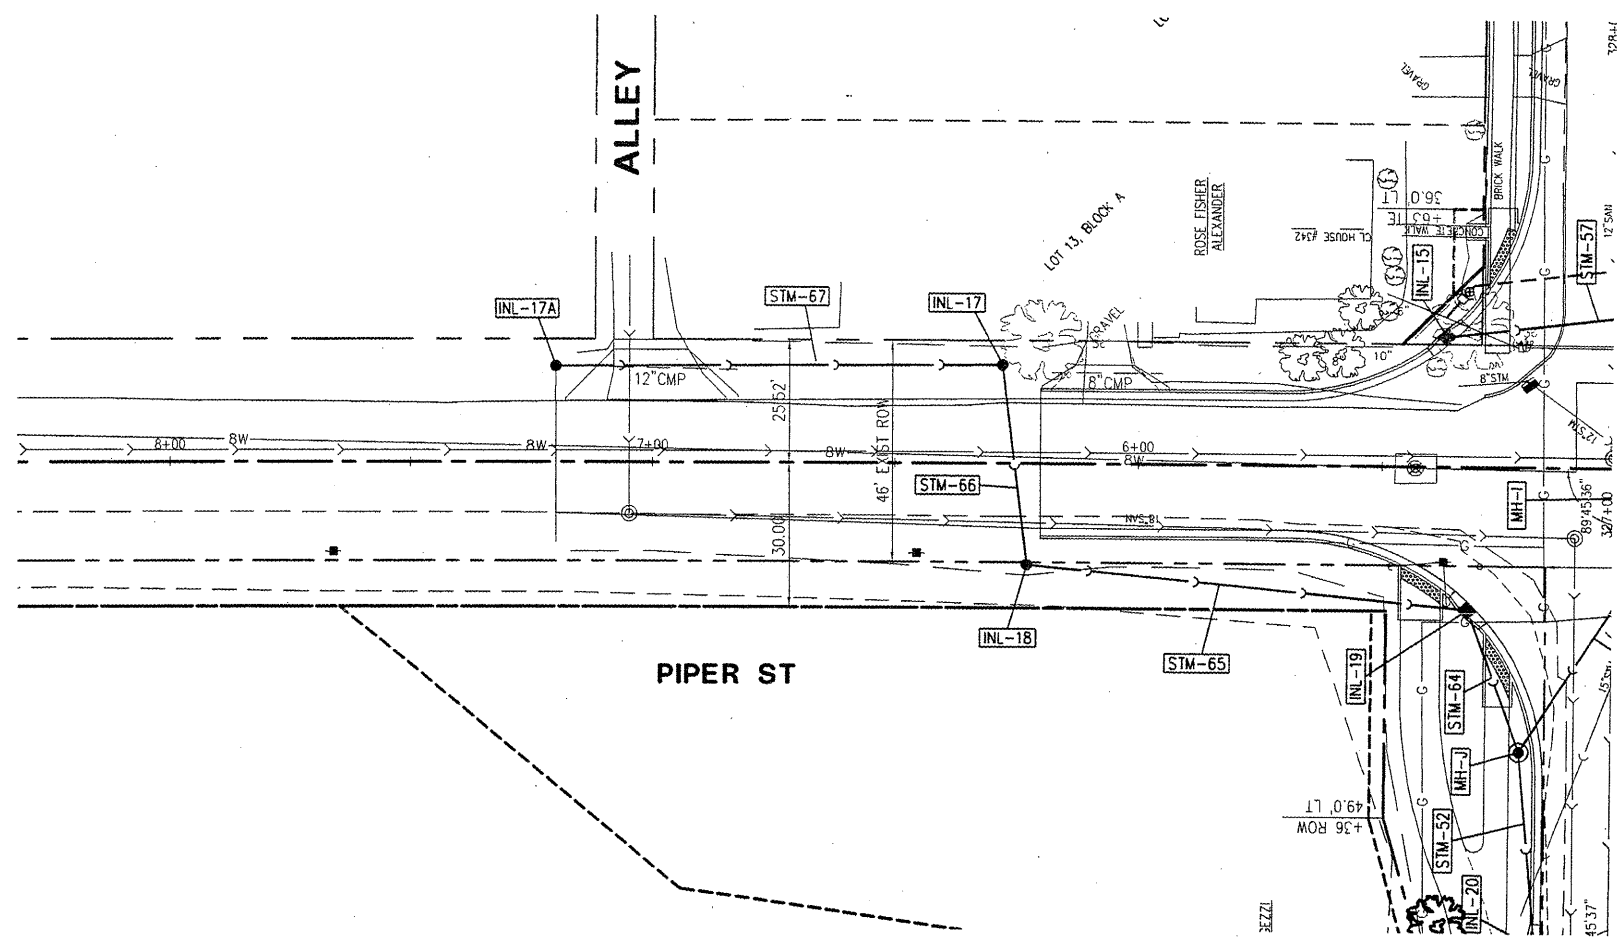


McClure
Engineering Associates, Inc.
Macomb, Illinois 61455
714 East Jackson Street
(309) 833-4594 FAX (309) 837-4909
Design firm License #181-000816 Copyright 2008 by McClure Engineering Associates, Inc.

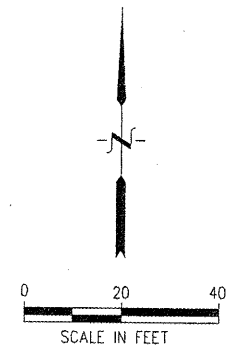



STORM INL-17A
INLET TY A 2' TY 8 GR
STA. 7+20, 20.0' RT
RIM=694.10
IE=691.27(E)

STORM INL-19
INLET SPECIAL No. 1
STA. 326+79.7, 32.5' LT
STA. 5+32.6, 29.7' LT (PIPER)
EP=693.97
IE=690.06(W)
IE=689.96(SE)

STORM INL-17
INLET TY A 2' TY 8 GR
STA. 6+28, 20.5' RT
RIM=693.60
IE=690.87(W)
IE=690.77(S)

STORM MH-J
MH TY A, 7', TY 1 FR&OL
STA. 326+50, 21.5' LT
STA. 5+21.75, 59.45' LT (PIPER)
RIM=694.27
IE=690.09(NE)
IE=689.87(NW)
IE=689.77(S)

STORM INL-18
INLET TY B TY 1 FR&OL
STA. 6+23, 21.0' LT
RIM=693.80
IE=690.59(N)
IE=690.34(E)

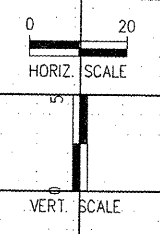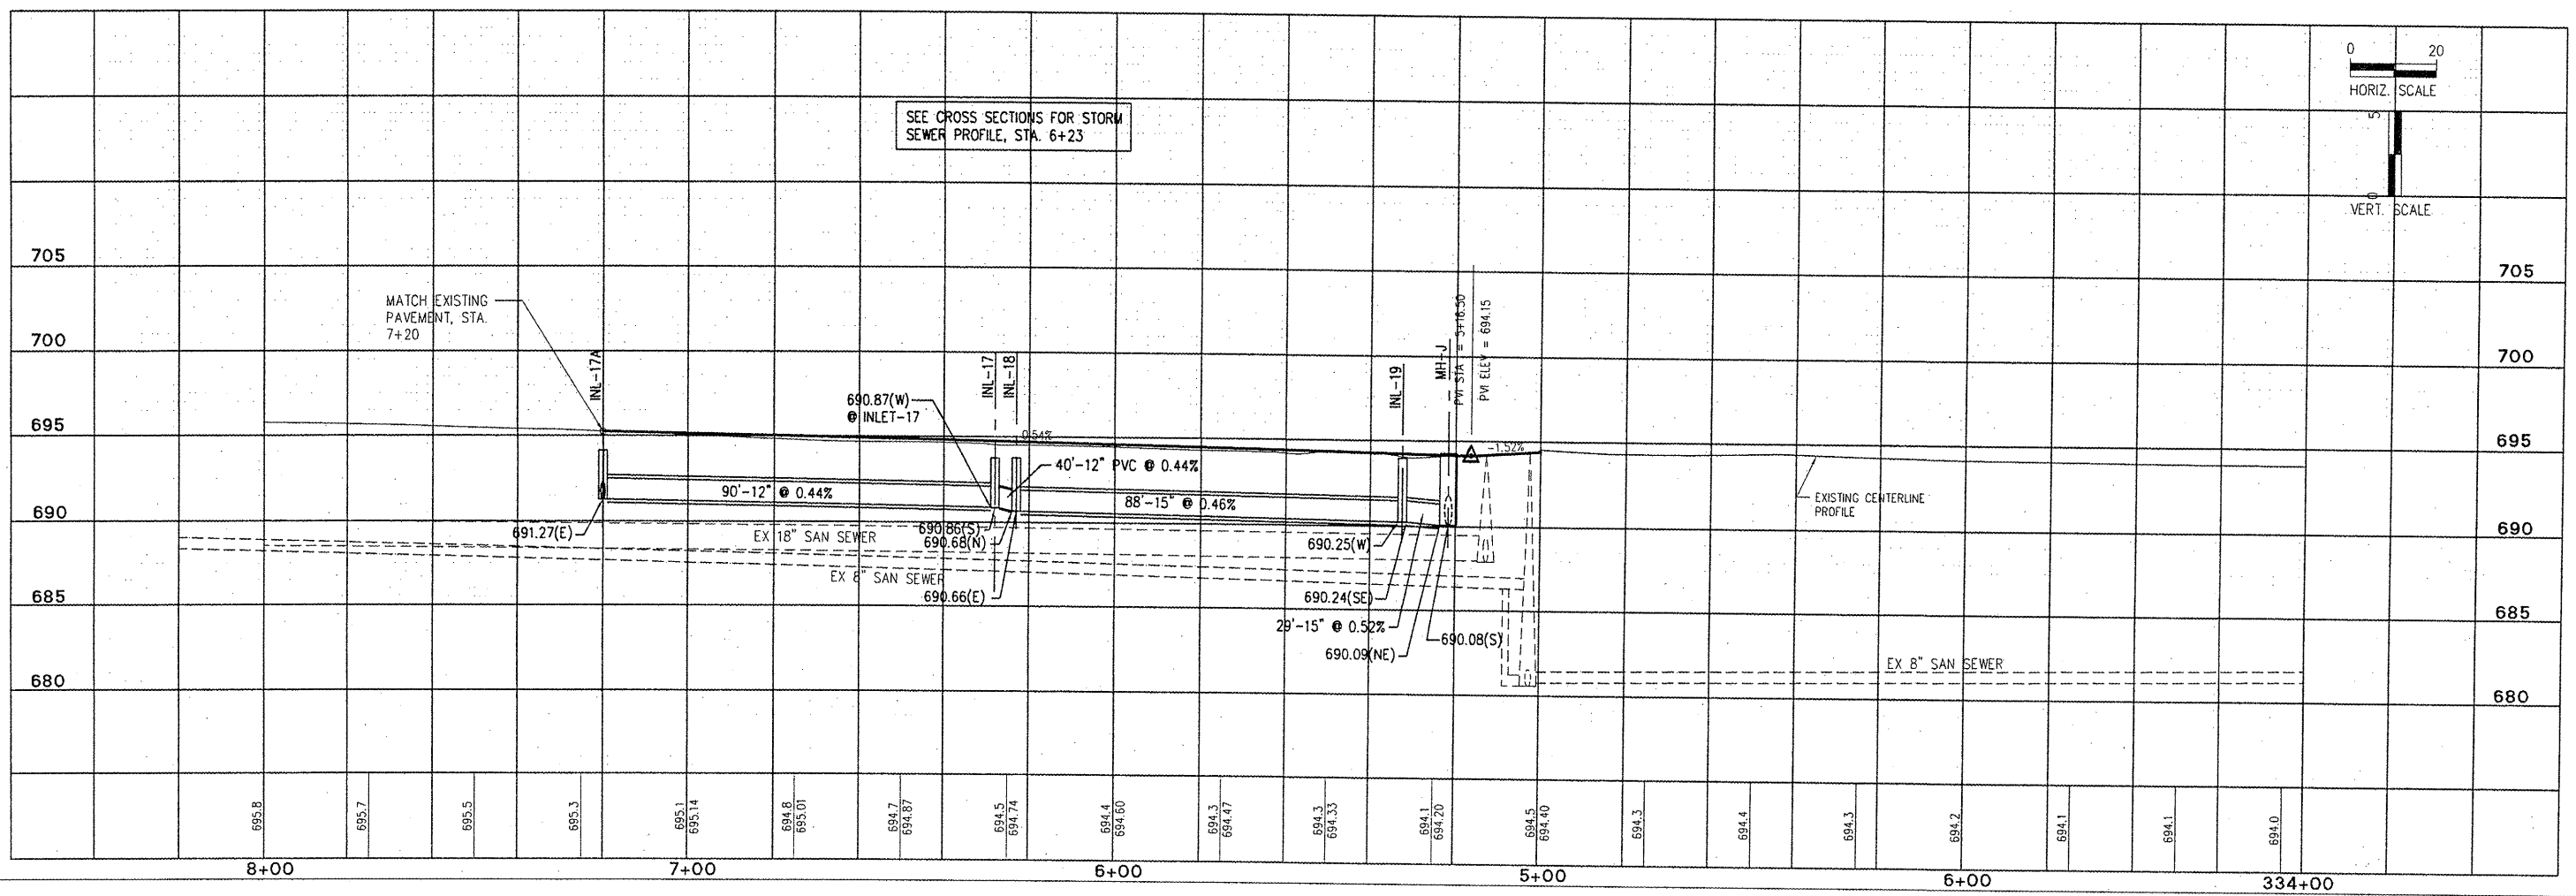

PLOTTING SCALE:	1" = 20'
DRAWN BY:	TAB
CHECKED BY:	JAP
DATE:	OCTOBER 2008

NO.	REVISIONS	ITEM	DATE

WARD STREET IMPROVEMENTS
STORM SEWER PLAN AND PROFILE - PIPER STREET WEST
CITY OF MACOMB
SOUTH WARD ST.
FILE NAME: W:\DRAWINGS\MACOMB\WARDST\WARD-ST-2007 FIELD BOOK No. 2257 JOB NUMBER: 03-26-07002
MACOMB, ILLINOIS