

F.A.U. RTE.	SECTION	COUNTY	TOTAL SHEETS	SHEET NO.
9024	07-00187-02-RP	MADISON	111	41
FED. ROAD DIST. NO.	ILLINOIS	FED. AID PROJECT		
CONTRACT NO. 97376				





BY	DATE
SURVEYED	
PLOTTED	
NOTE BOOK	
TEMPLATE	
AREAS CHECKED	
NO.	

BY	DATE
SURVEYED	
PLOTTED	
NOTE BOOK	
TEMPLATE	
AREAS CHECKED	
NO.	

MATCH LINE STA. 125+60.00

MATCH LINE STA. 131+20.00

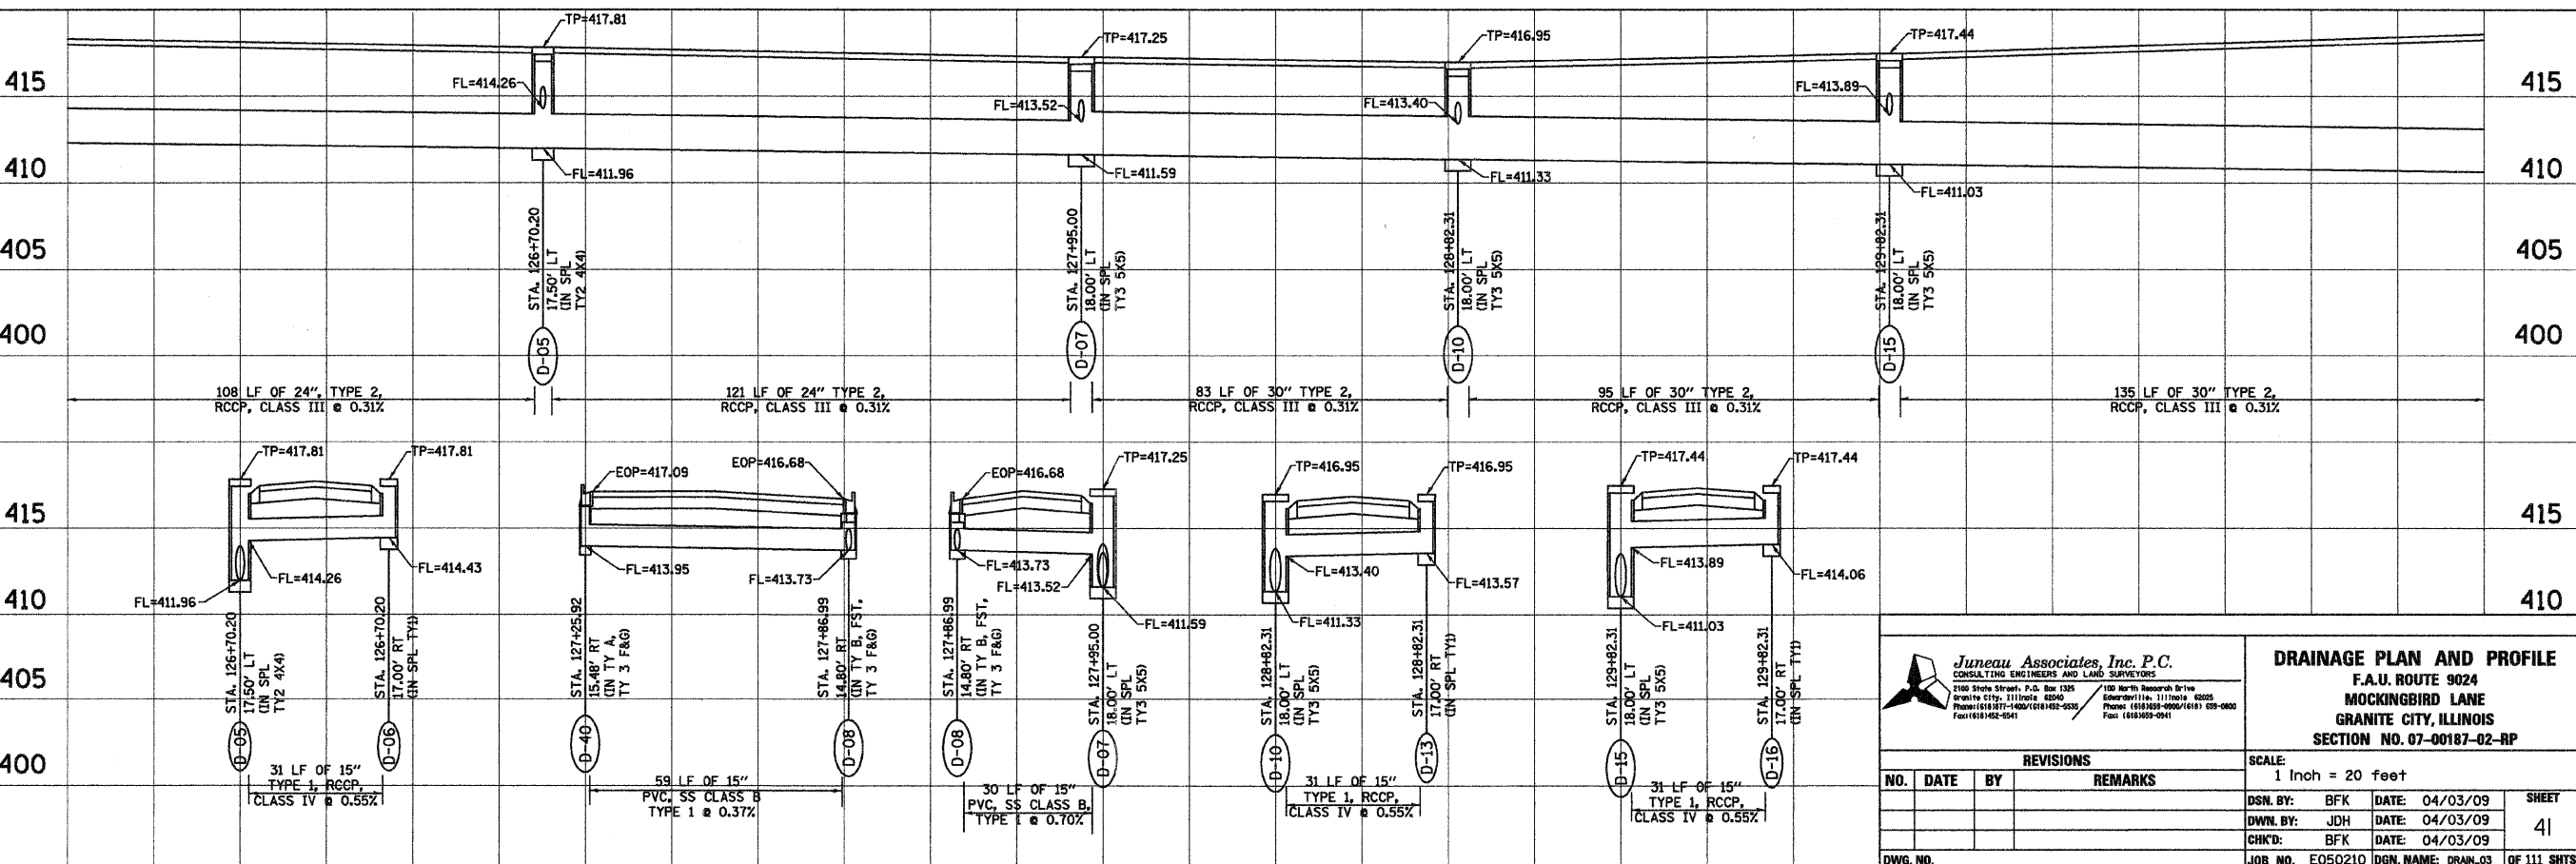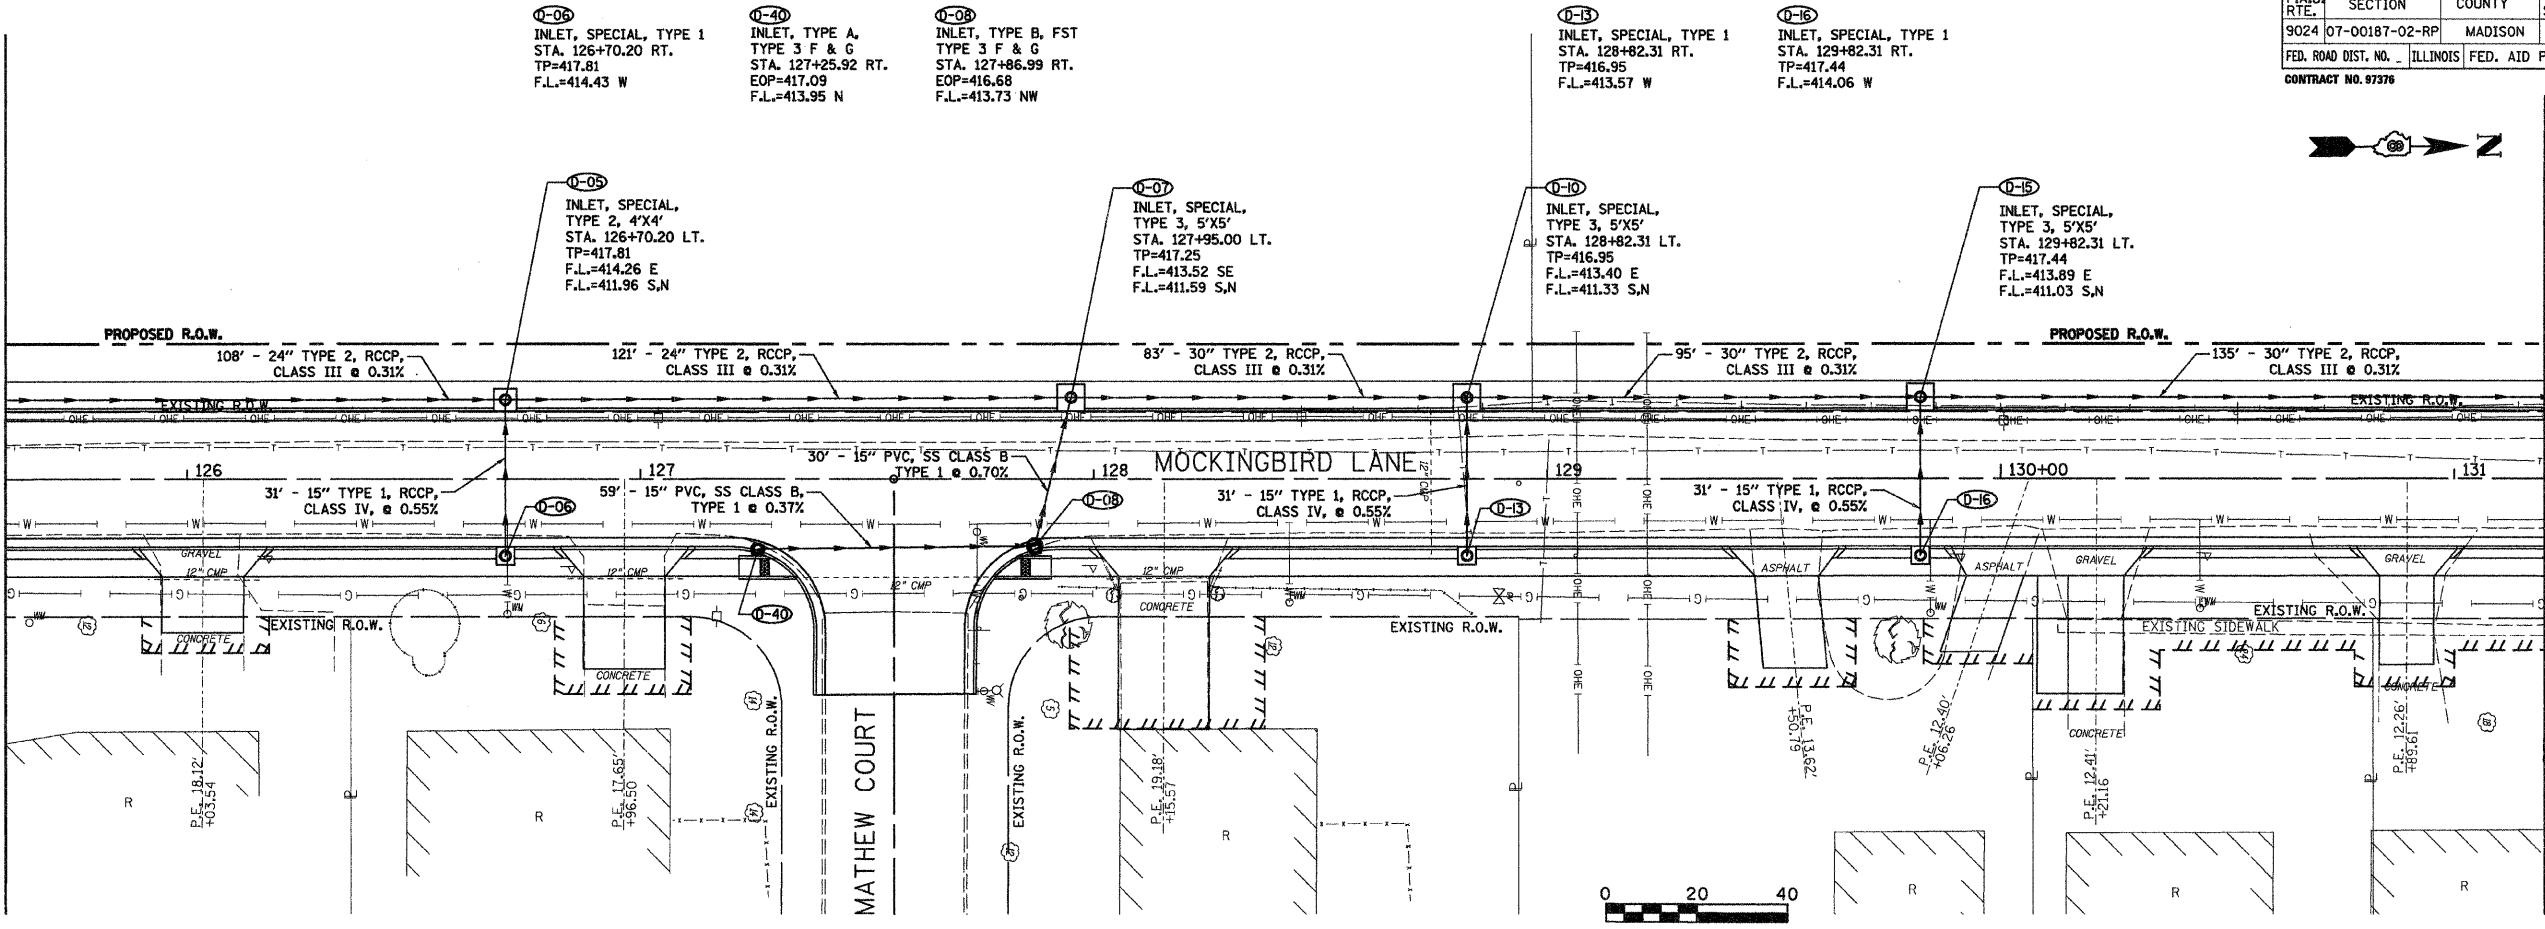

Juneau Associates, Inc. P.C.
 CONSULTING ENGINEERS AND LAND SURVEYORS
 2318 Stone Street, P.O. Box 1225
 Granite City, Illinois 62040
 Phone: (618) 877-1400 / (618) 492-9550
 Fax: (618) 492-2941

DRAINAGE PLAN AND PROFILE
 F.A.U. ROUTE 9024
 MOCKINGBIRD LANE
 GRANITE CITY, ILLINOIS
 SECTION NO. 07-00187-02-RP

REVISIONS			
NO.	DATE	BY	REMARKS

SCALE: 1 Inch = 20 feet			
DSN. BY:	BFK	DATE:	04/03/09
DWN. BY:	JDH	DATE:	04/03/09
CHK'D:	BFK	DATE:	04/03/09
DWG. NO.	JOB NO. E050210 DGN. NAME: DRAM_03 OF 111 SHTS		