


DATE	
BY	
FINAL SURVEYED	
SURVEY PLOTTED	
NOTE BOOK TEMPLATE	
AREAS CHECKED	
NO.	

DATE	
BY	
ORIGINAL SURVEYED	
SURVEY PLOTTED	
NOTE BOOK TEMPLATE	
AREAS CHECKED	
NO.	

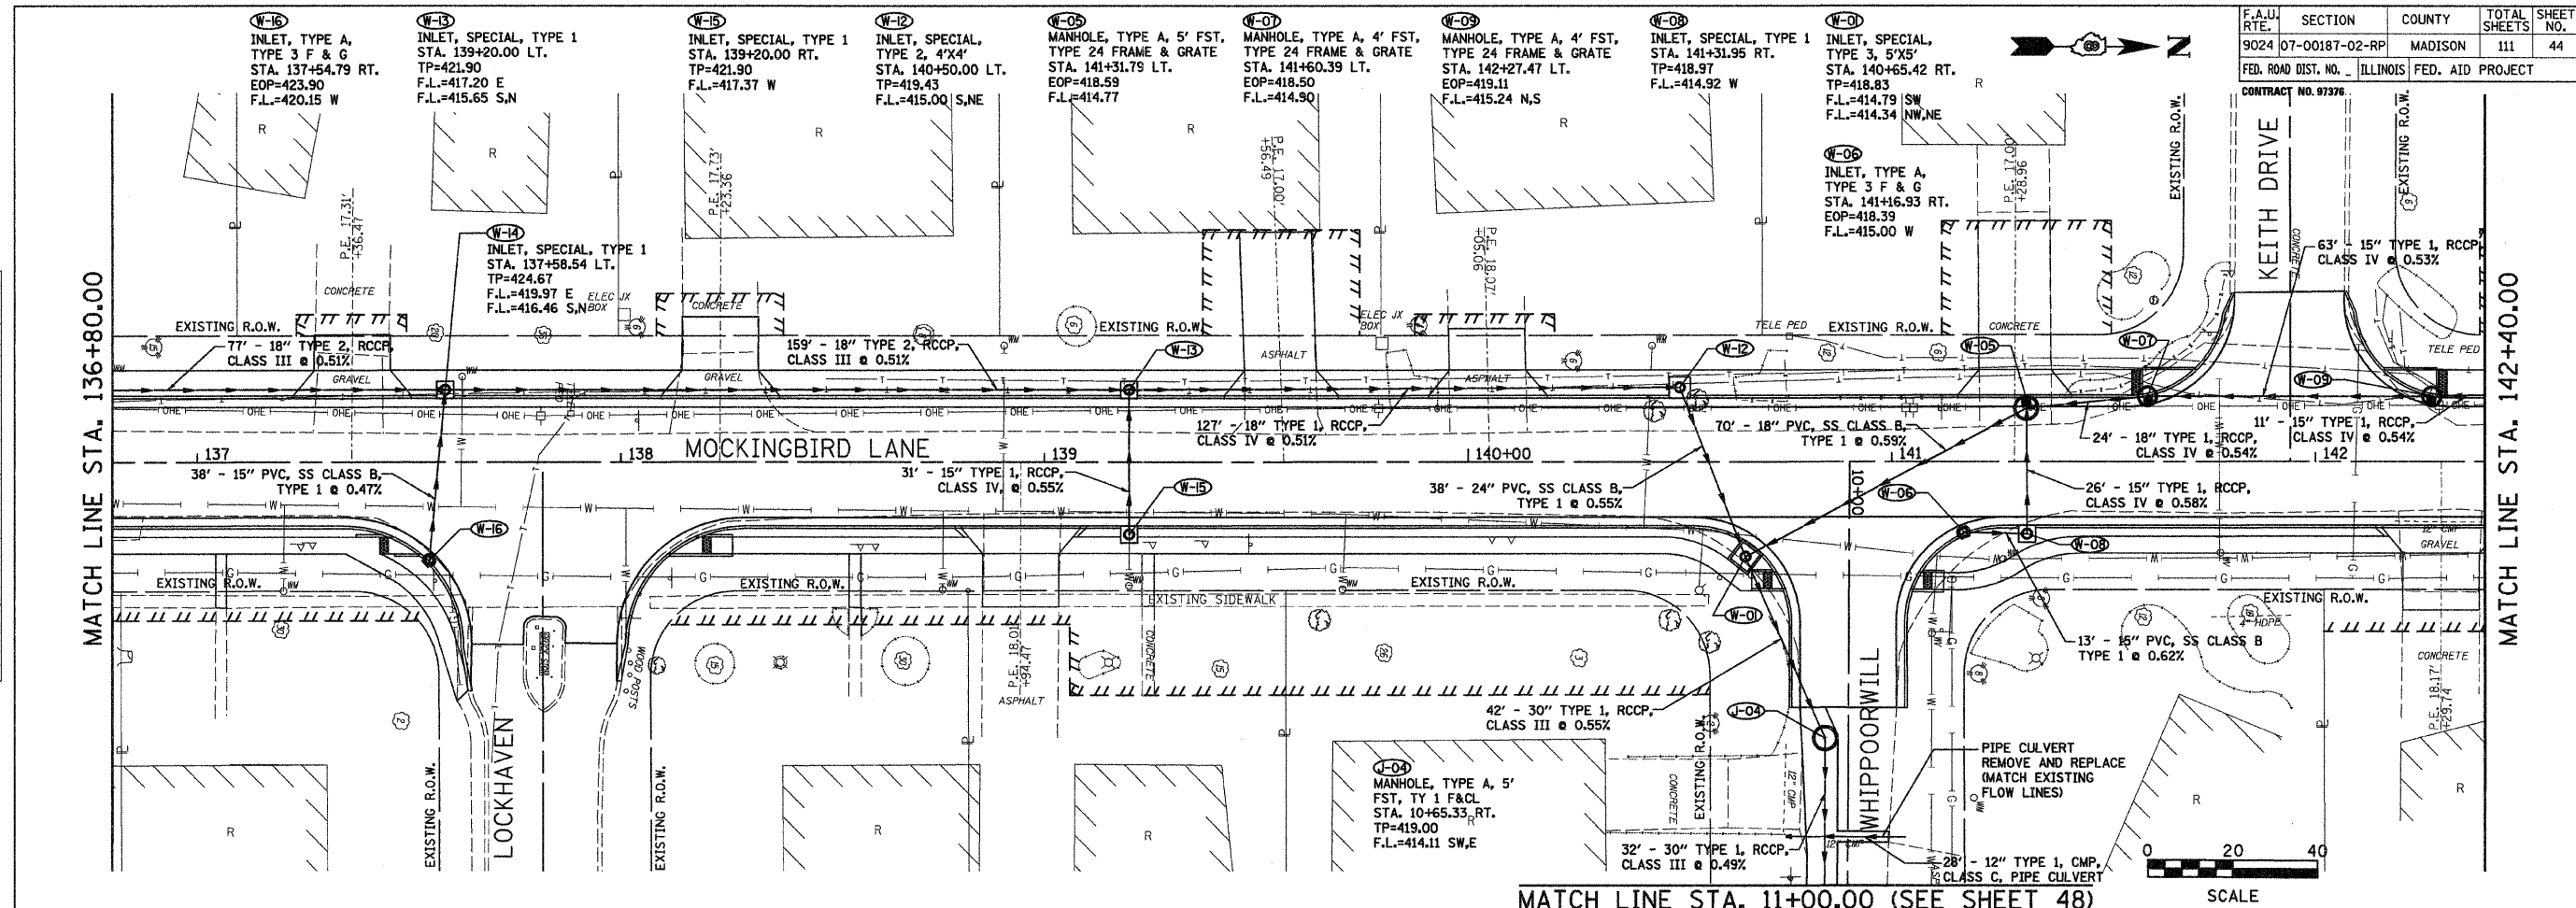

F.A.U. RTE.	SECTION	COUNTY	TOTAL SHEETS	SHEET NO.
9024	07-00187-02-RP	MADISON	111	44
FED. ROAD DIST. NO.	ILLINOIS	FED. AID PROJECT		

MATCH LINE STA. 11+00.00 (SEE SHEET 48) SCALE 0 20 40

Junear Associates, Inc. P.C.
CONSULTING ENGINEERS AND LAND SURVEYORS
2100 Stone Street, P.O. Box 1320 Granite City, Illinois 62040
Phone: (618) 387-1400 / (618) 387-0500 Fax: (618) 387-0541

DRAINAGE PLAN
F.A.U. ROUTE 9024
MOCKINGBIRD LANE
GRANITE CITY, ILLINOIS
SECTION NO. 07-00187-02-RP

REVISIONS			
NO.	DATE	BY	REMARKS

SCALE: 1 Inch = 20 feet	
DSN. BY: BFK	DATE: 04/03/09
DWN. BY: JDH	DATE: 04/03/09
CHK'D: BFK	DATE: 04/03/09
DWG. NO.	JOB NO. E050210 DGN. NAME: DRANK_05 OF 111 SHTS