

 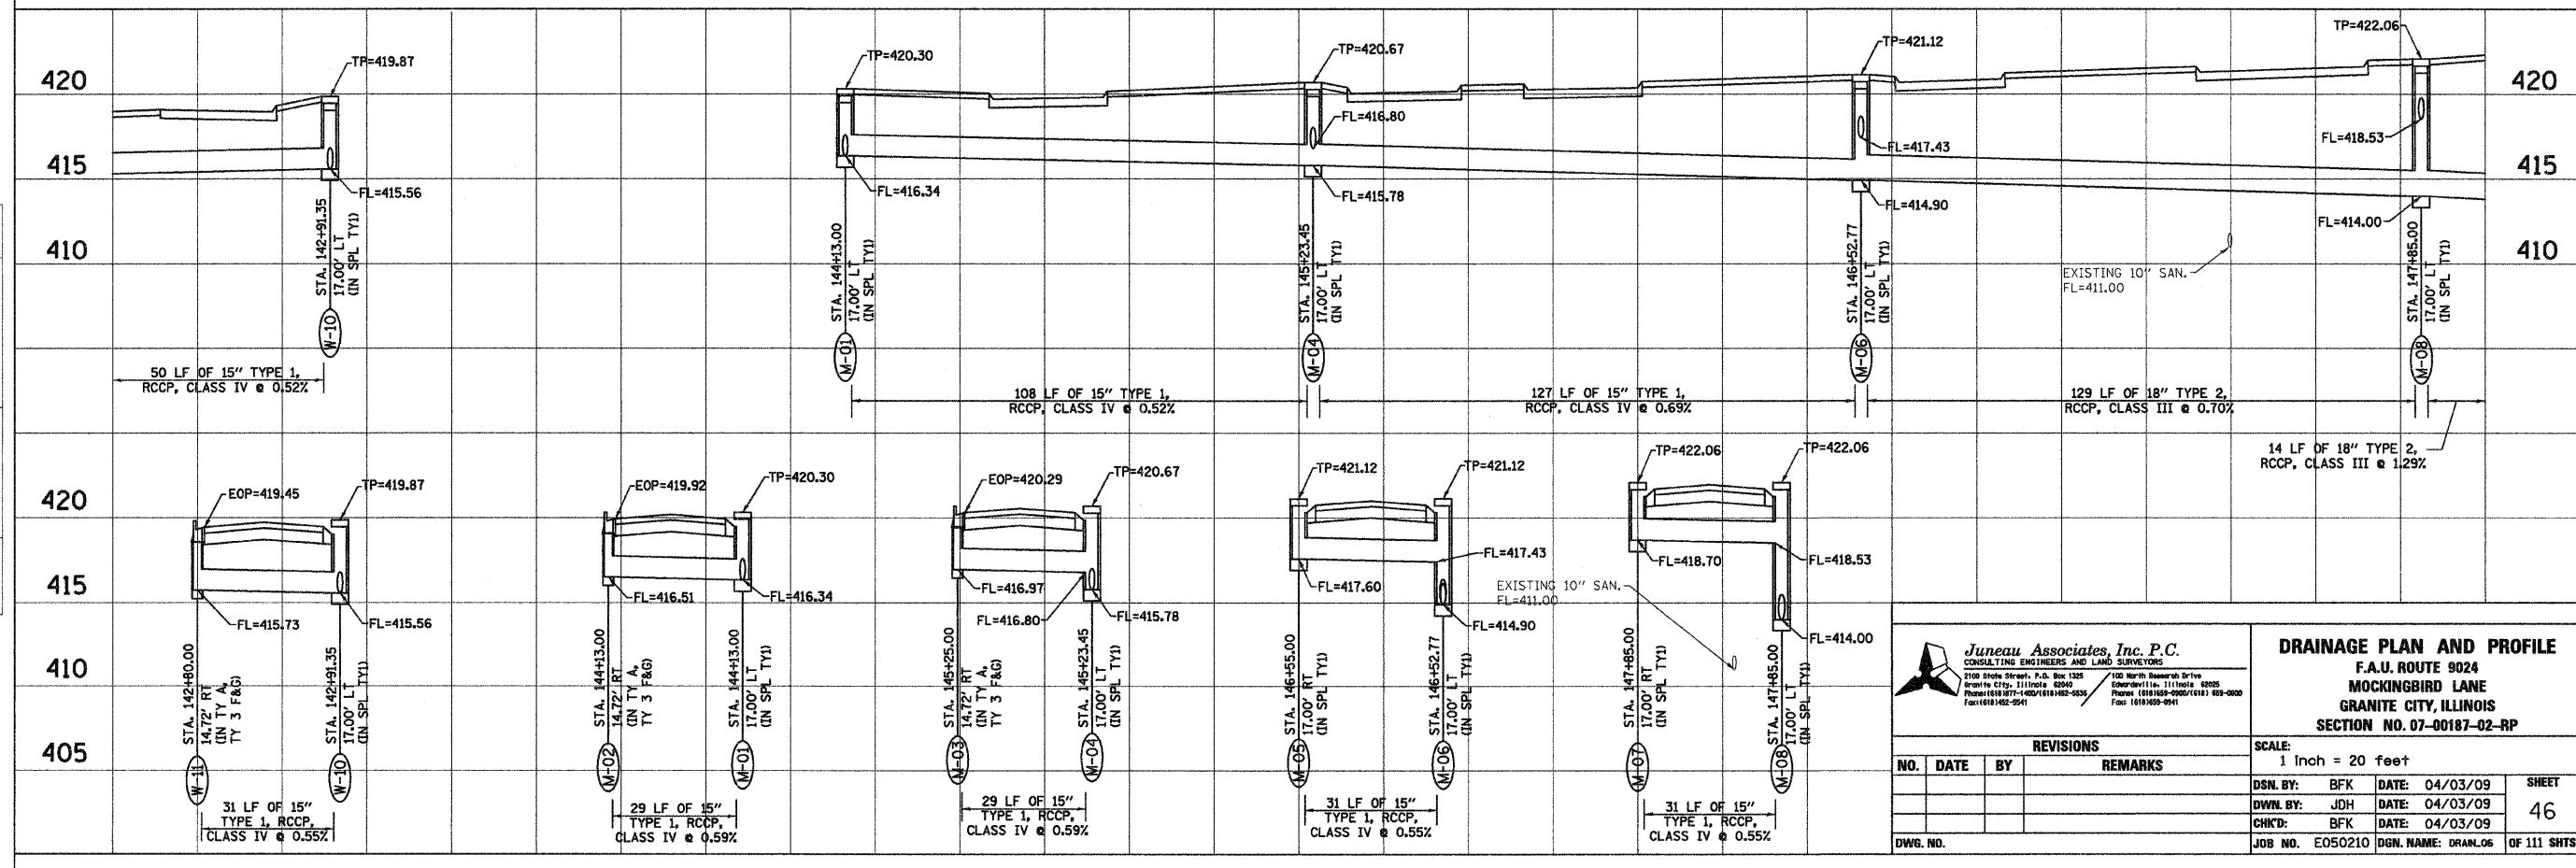


BY	DATE
SURVEYED	
PLOTTED	
NOTE BOOK	
TEMPLATE	
AREAS	
CHECKED	
NO.	

BY	DATE
ORIGINAL	
SURVEY	
PLOTTED	
NOTE BOOK	
TEMPLATE	
AREAS	
CHECKED	
NO.	

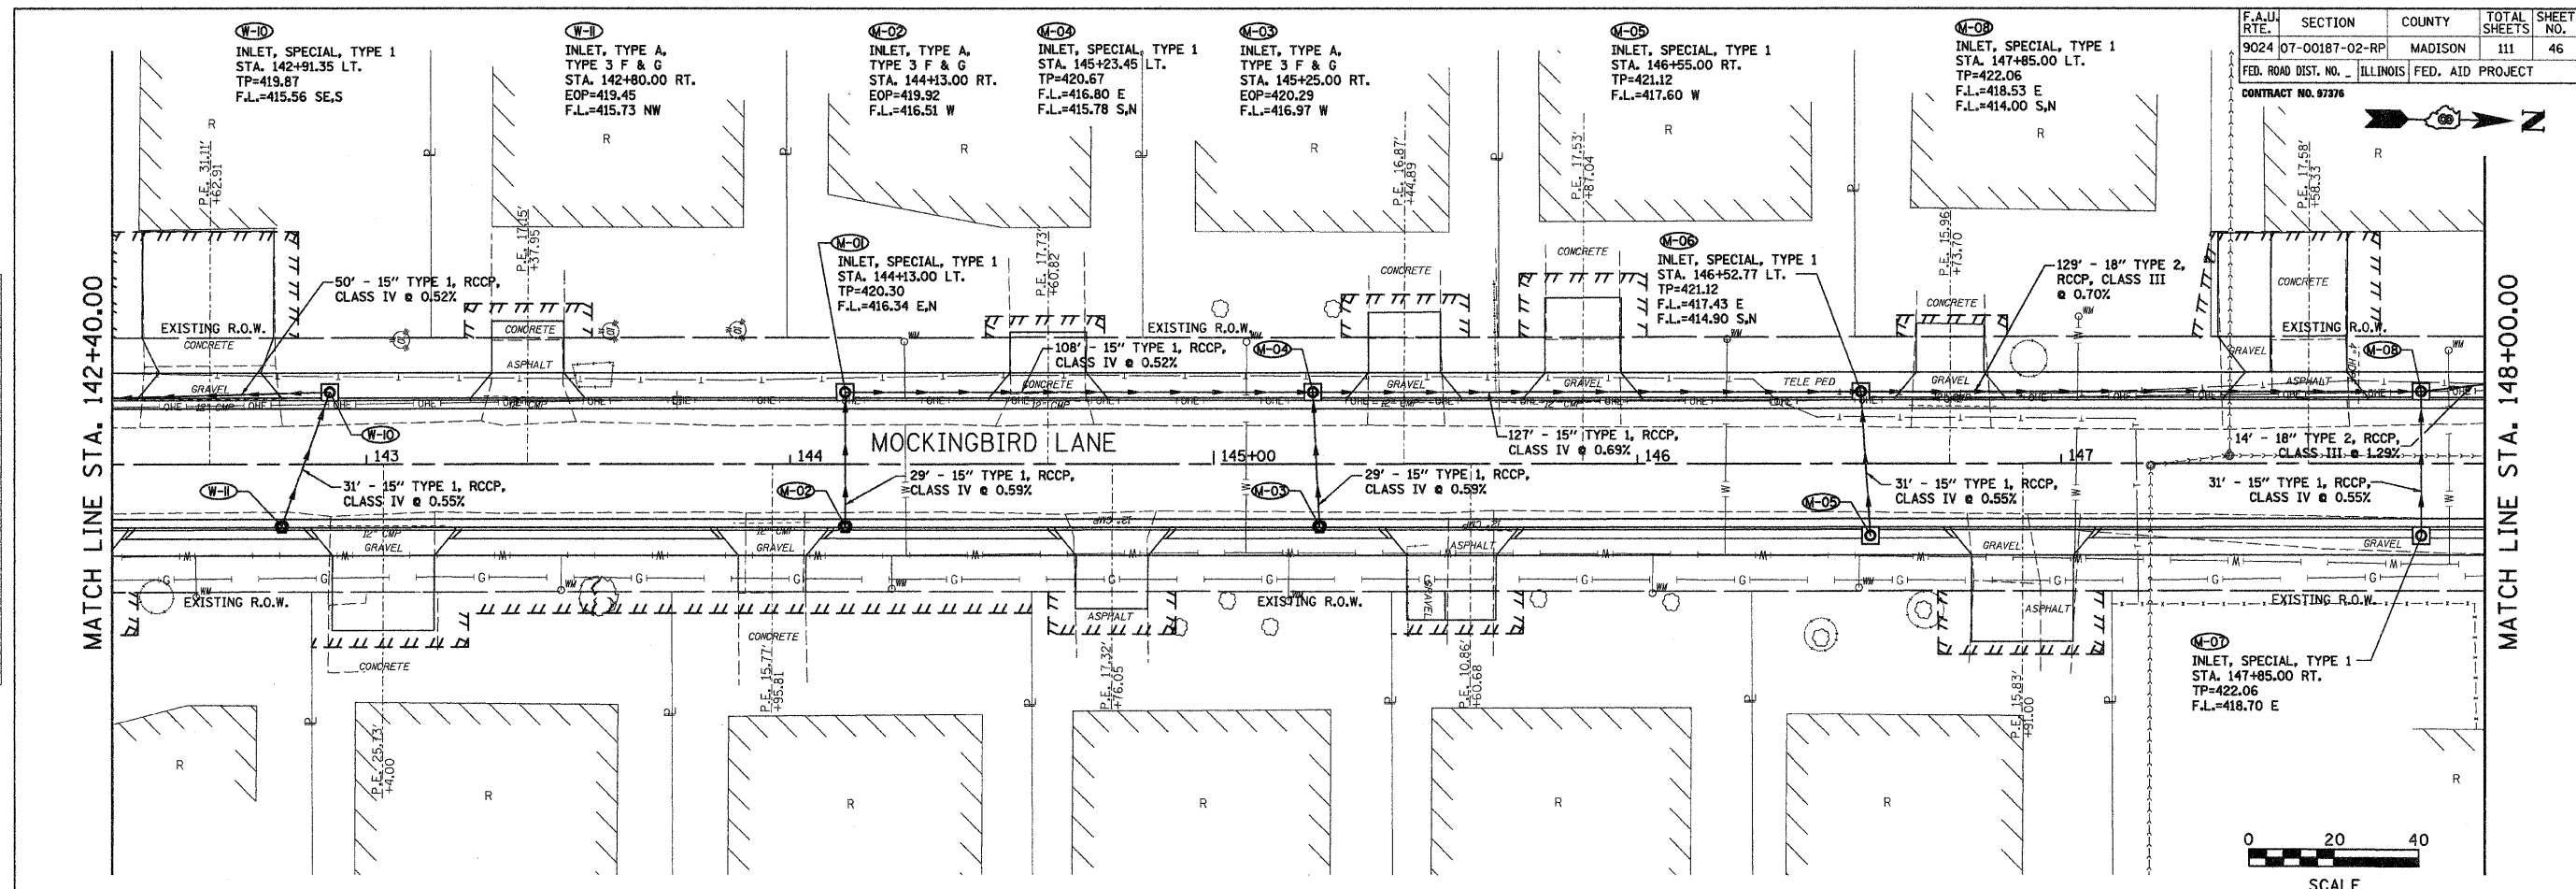

F.A.U. RTE.	SECTION	COUNTY	TOTAL SHEETS	SHEET NO.
9024	07-00187-02-RP	MADISON	111	46
FED. ROAD DIST. NO.	ILLINOIS	FED. AID PROJECT		
CONTRACT NO. 07276				



Juneau Associates, Inc. P.C.
 CONSULTING ENGINEERS AND LAND SURVEYORS
 2102 State Street, P.O. Box 1322
 Granite City, Illinois 62040
 Phone: (618) 937-4600 / (618) 937-9500
 Fax: (618) 937-9541

DRAINAGE PLAN AND PROFILE
 F.A.U. ROUTE 9024
 MOCKINGBIRD LANE
 GRANITE CITY, ILLINOIS
 SECTION NO. 07-00187-02-RP

REVISIONS			
NO.	DATE	BY	REMARKS

SCALE: 1 Inch = 20 feet			
DSN. BY:	BFK	DATE:	04/03/09
DWN. BY:	JDH	DATE:	04/03/09
CHK'D:	BFK	DATE:	04/03/09
DWG. NO.	E050210	DGN. NAME:	DRAN_06
		OF 111	SHTS