
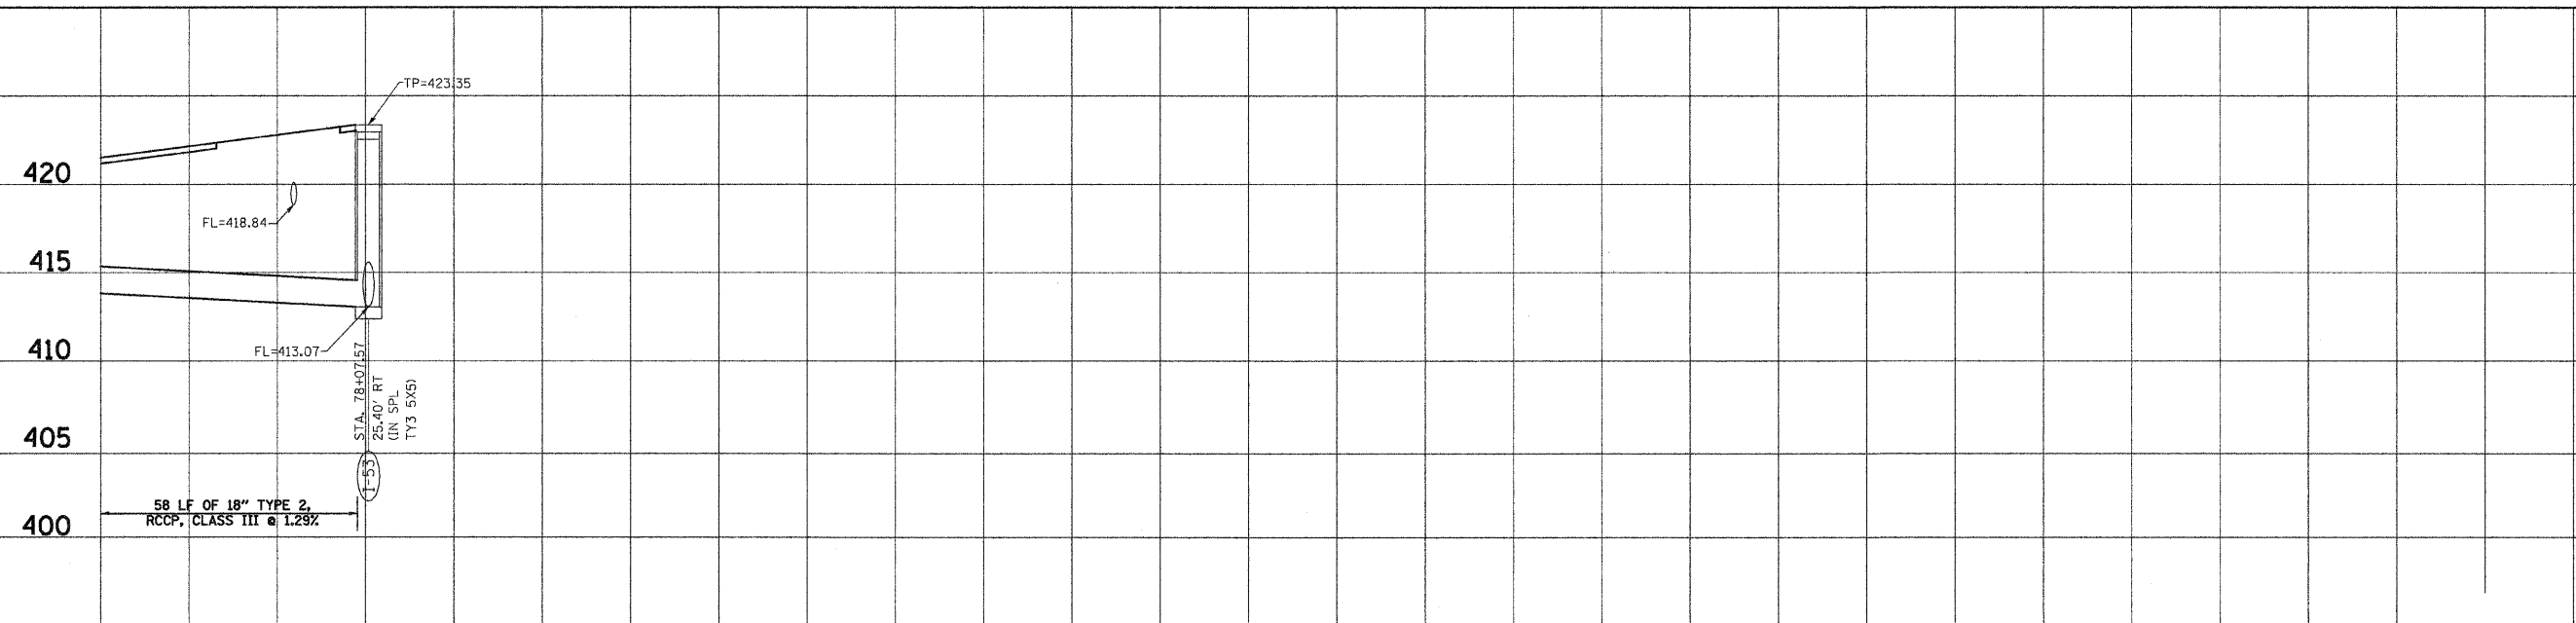


BY	DATE
FINAL SURVEYED	
SURVEY PLOTTED	
NOTE BOOK TEMPLATE	
AREAS CHECKED	
NO.	

BY	DATE
ORIGINAL SURVEYED	
SURVEY PLOTTED	
NOTE BOOK TEMPLATE	
AREAS CHECKED	
NO.	

F.A.U. RTE.	SECTION	COUNTY	TOTAL SHEETS	SHEET NO.
9024	07-00187-02-RP	MADISON	111	47
FED. ROAD DIST. NO. ILLINOIS		FED. AID PROJECT		
CONTRACT NO. 97376				

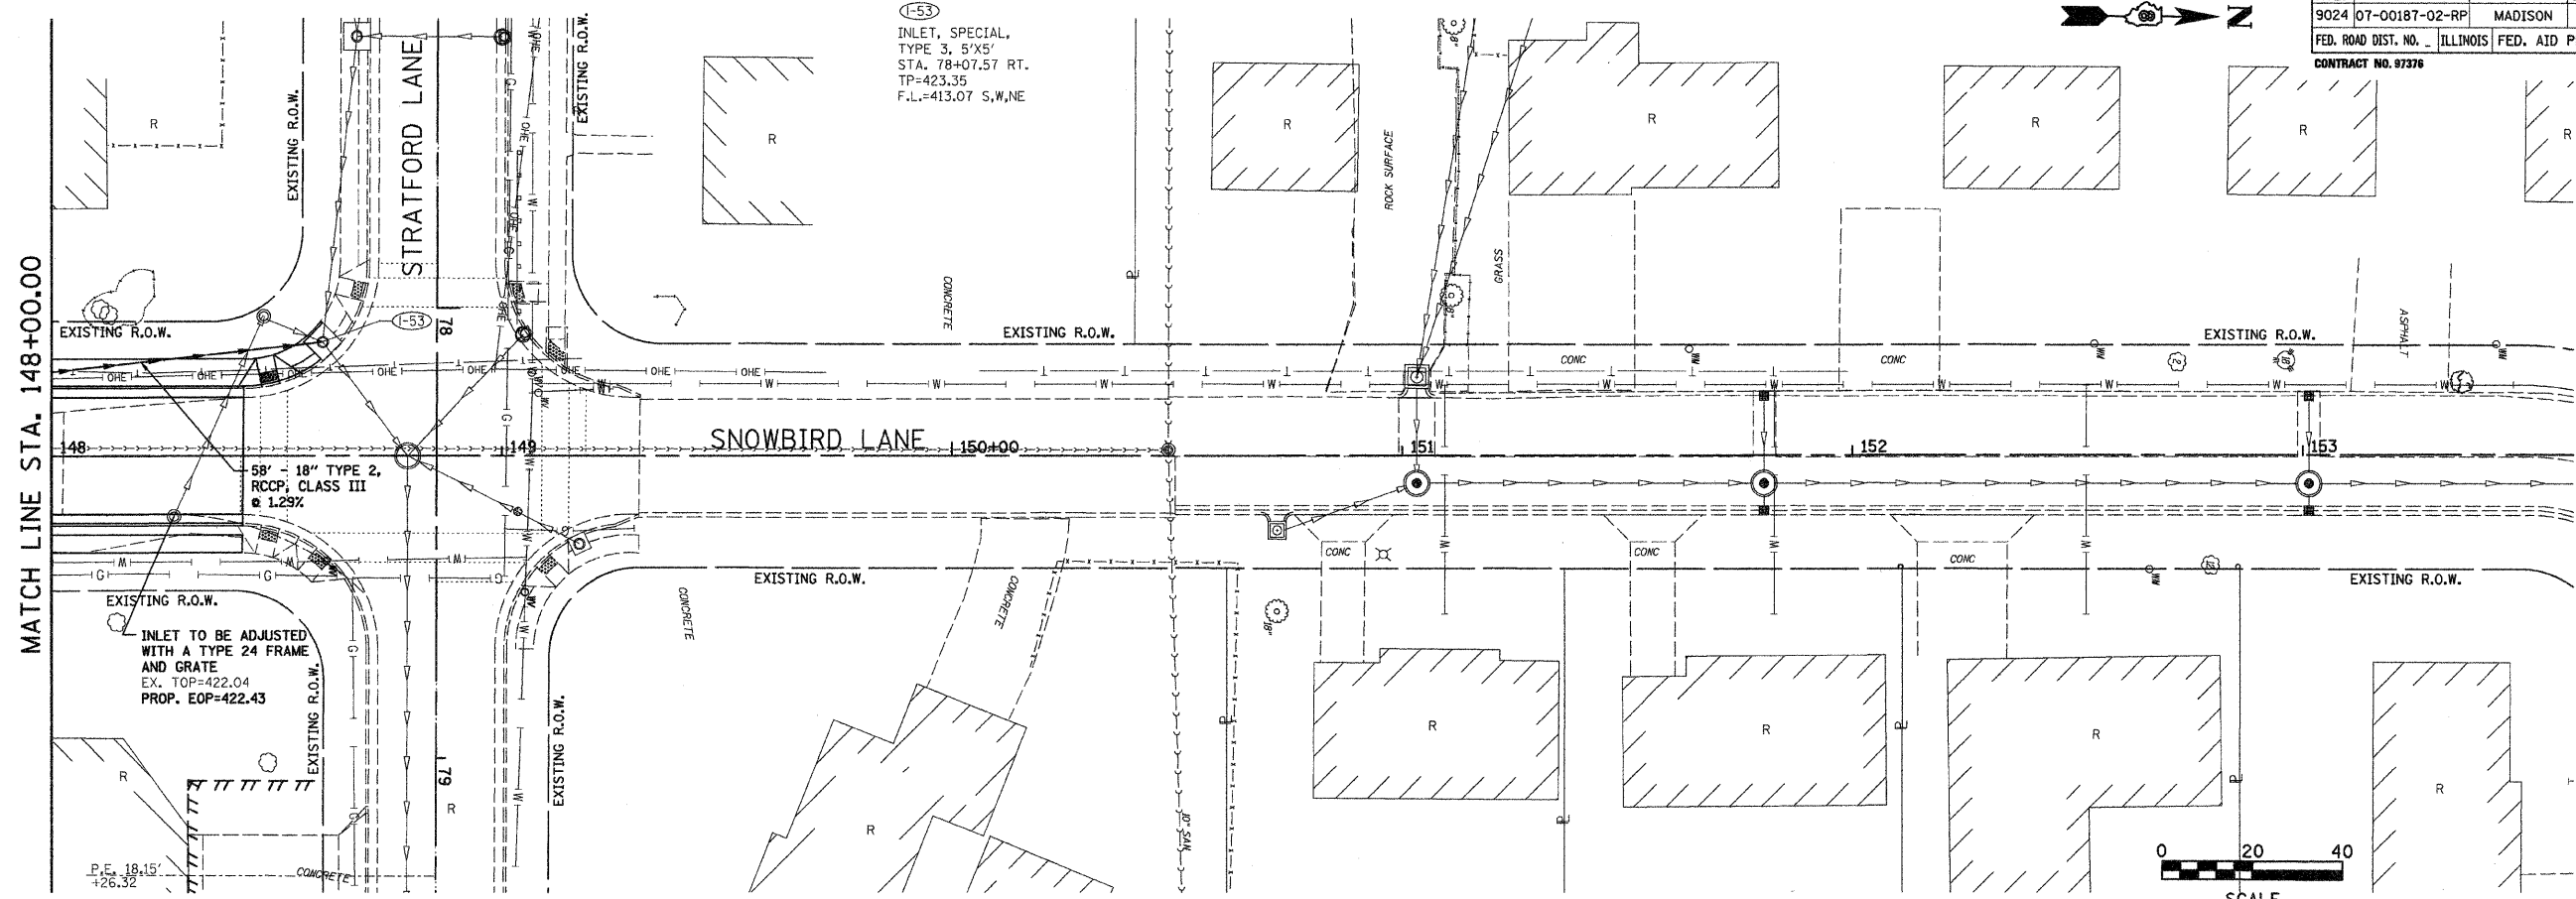

Juneau Associates, Inc. P.C.
CONSULTING ENGINEERS AND LAND SURVEYORS
2300 State Street, P.O. Box 1370 Granite City, Illinois 62040
Phone: (618) 387-4400 / (618) 382-5534 Fax: (618) 452-0541

DRAINAGE PLAN AND PROFILE
F.A.U. ROUTE 9024
MOCKINGBIRD LANE
GRANITE CITY, ILLINOIS
SECTION NO. 07-00187-02-RP

REVISIONS			
NO.	DATE	BY	REMARKS

SCALE: 1 Inch = 20 feet			
DSN. BY:	BFK	DATE:	04/03/09
DWN. BY:	JDH	DATE:	04/03/09
CHK'D:	BFK	DATE:	04/03/09
DWG. NO.	JOB NO. E050210 DGN. NAME: DRAIN_07 OF 111 SHTS		