



F.A.U. RTE.	SECTION	COUNTY	TOTAL SHEETS	SHEET NO.
9024	07-00187-02-RP	MADISON	111	49
FED. ROAD DIST. NO. ILLINOIS		FED. AID PROJECT		
CONTRACT NO. 97376				

BY	DATE
SURVEYED	
PLOTTED	
NOTE BOOK TEMPLATE	
AREAS CHECKED	
NO.	

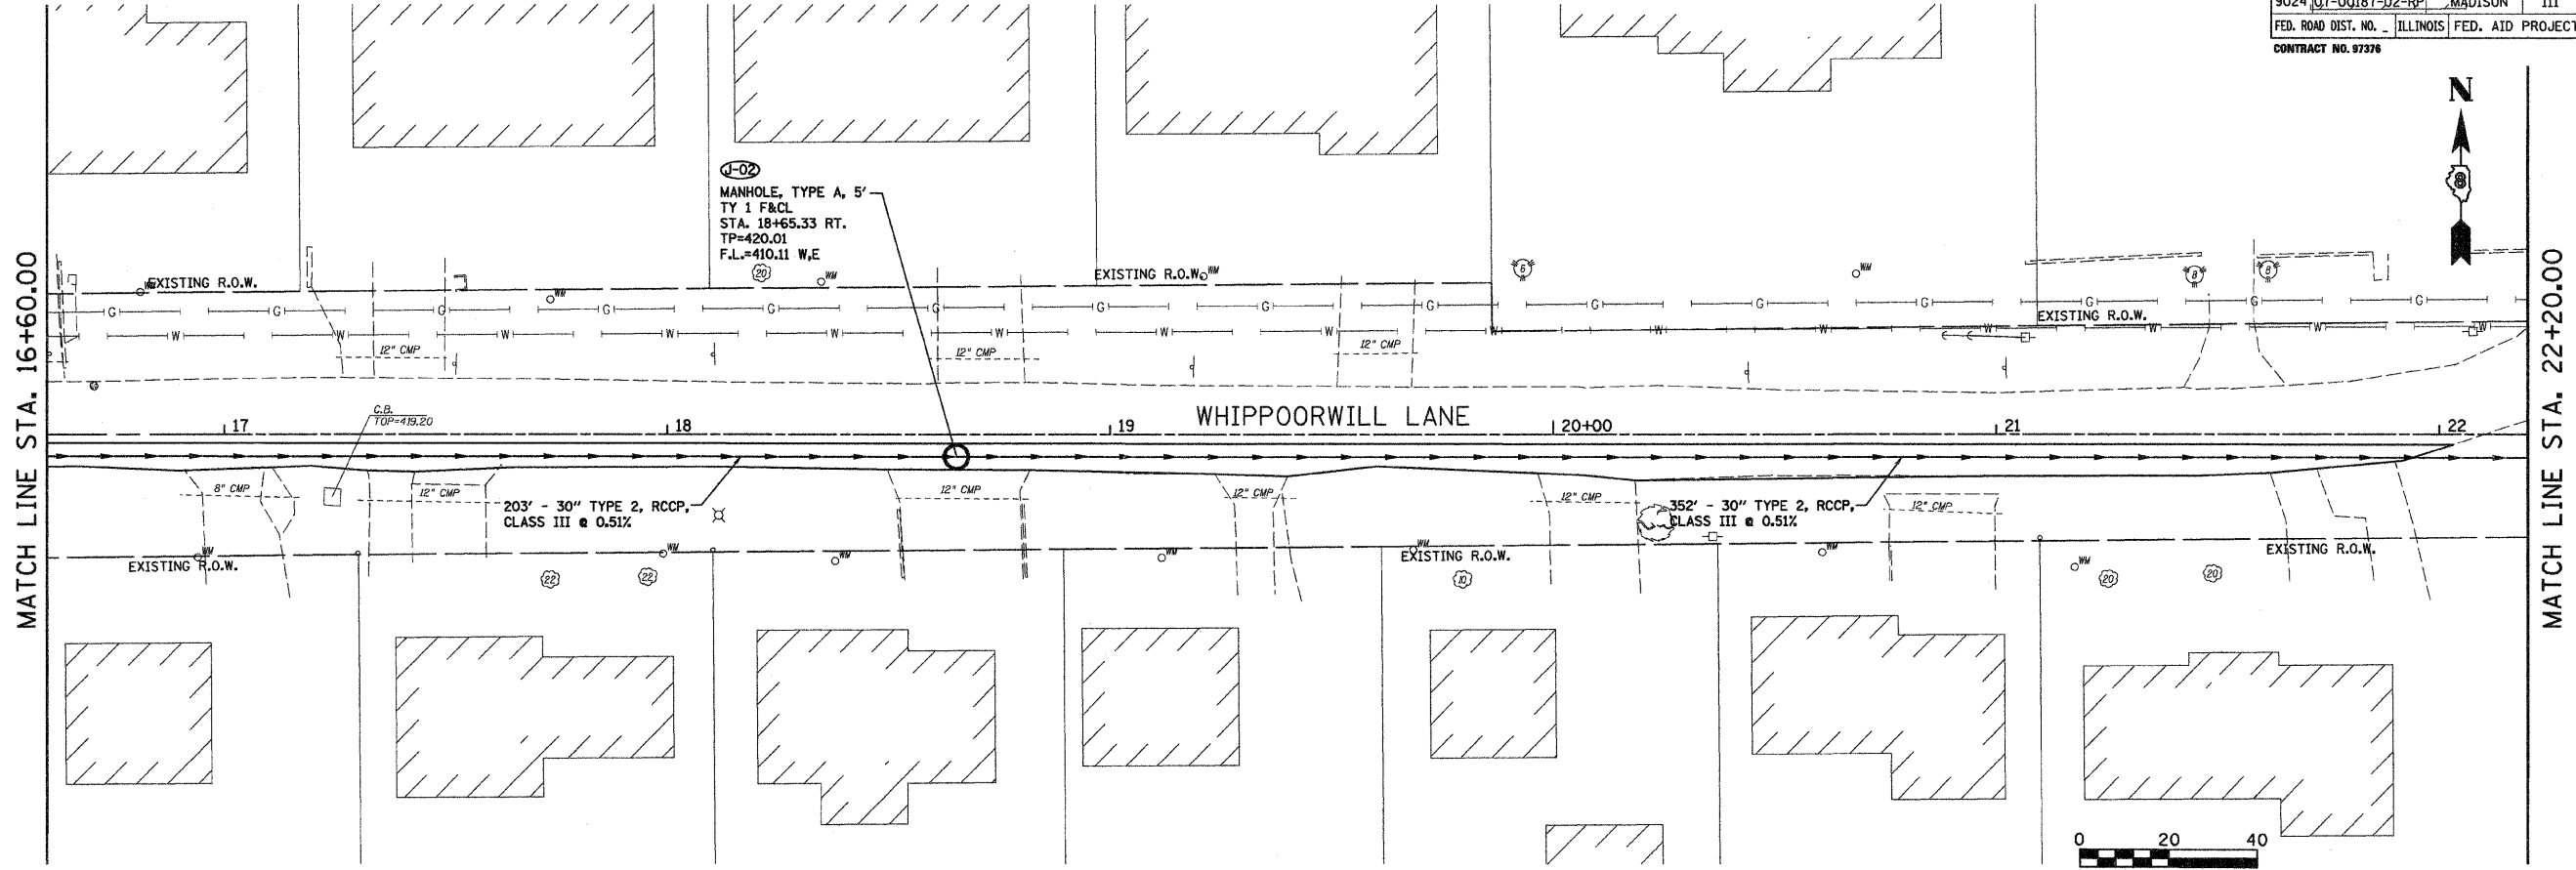

BY	DATE
ORIGINAL SURVEYED	
PLOTTED	
NOTE BOOK TEMPLATE	
AREAS CHECKED	
NO.	

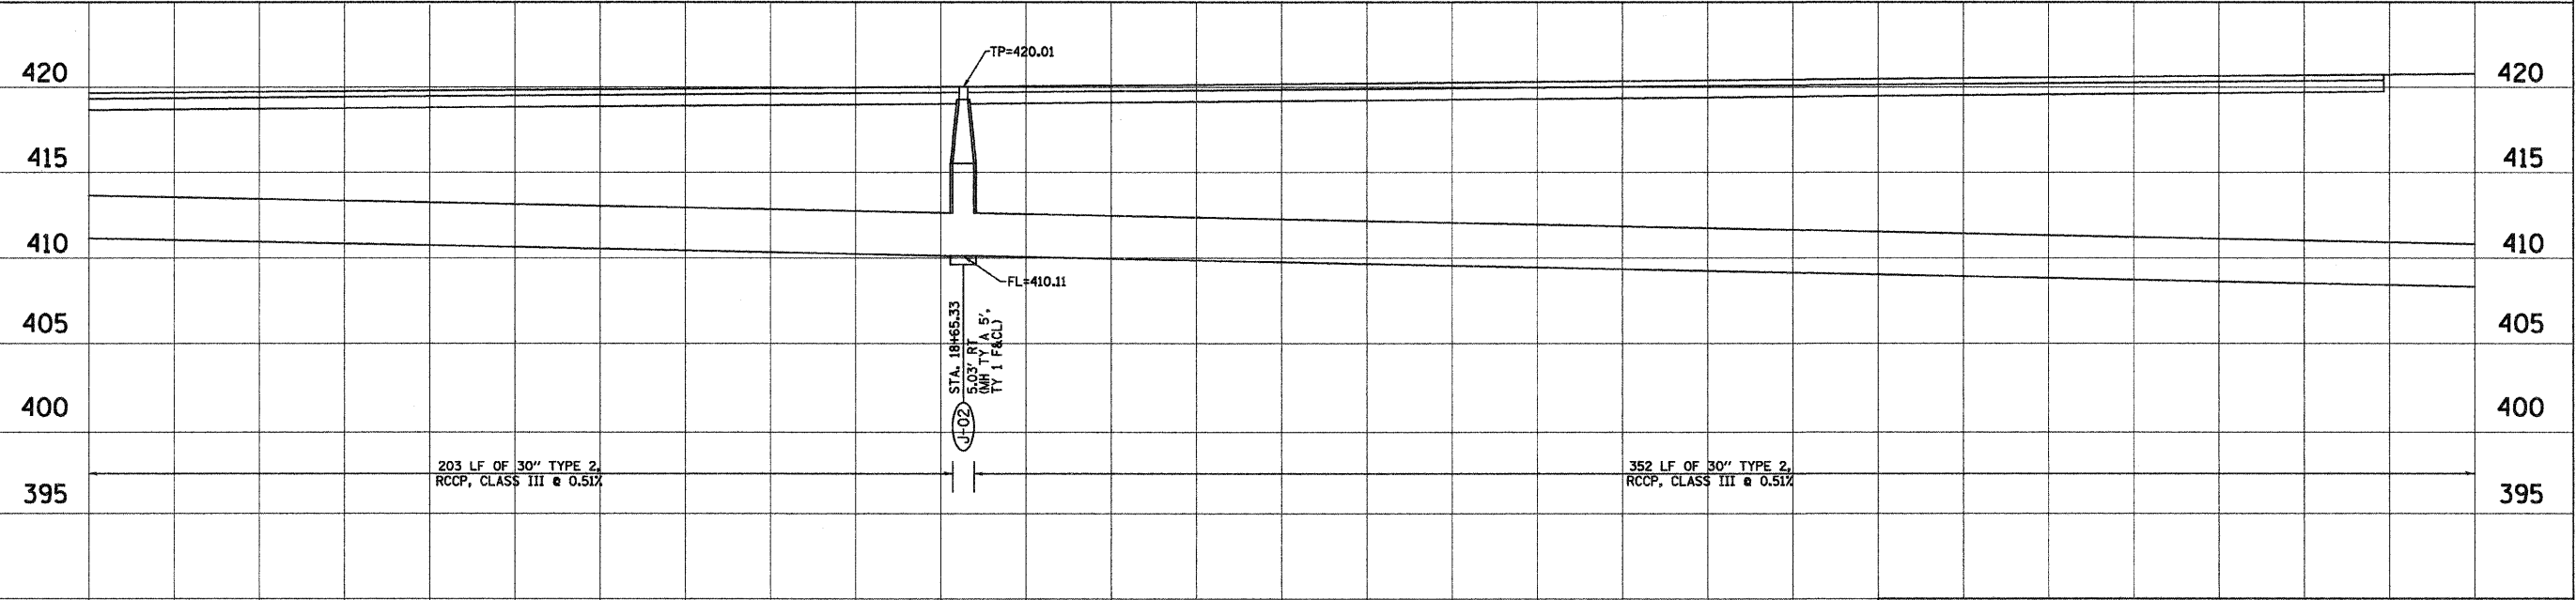

**Juneau Associates, Inc. P.C.**  
CONSULTING ENGINEERS AND LAND SURVEYORS  
2500 State Street, P.O. Box 1320  
Granite City, Illinois 62040  
Phone: (618) 527-4800 / (618) 527-5531  
Fax: (618) 482-2541

100 North Research Drive  
Edwardsville, Illinois 62025  
Phone: (618) 265-9900 / (618) 595-0800  
Fax: (618) 265-0941

**DRAINAGE PLAN AND PROFILE**  
F.A.U. ROUTE 9024  
MOCKINGBIRD LANE  
GRANITE CITY, ILLINOIS  
SECTION NO. 07-00187-02-RP

SCALE:  
1 Inch = 20 feet

NO.	DATE	BY	REMARKS

DSN. BY: BFK	DATE: 04/03/09	SHEET
DWN. BY: JDH	DATE: 04/03/09	49
CHK'D: BFK	DATE: 04/03/09	

DWG. NO. E050210      JOB NO. E050210      DGN. NAME: DRAIN\_09      OF 111 SHTS