 



F.A.U. RTE.	SECTION	COUNTY	TOTAL SHEETS	SHEET NO.
9024	07-00187-02-RP	MADISON	111	51
FED. ROAD DIST. NO. _		ILLINOIS	FED. AID PROJECT	
CONTRACT NO. 97376				




FINAL SURVEY PLOTTED	BY	DATE
NOTE BOOK TEMPLATE		
AREAS CHECKED		
NO.		

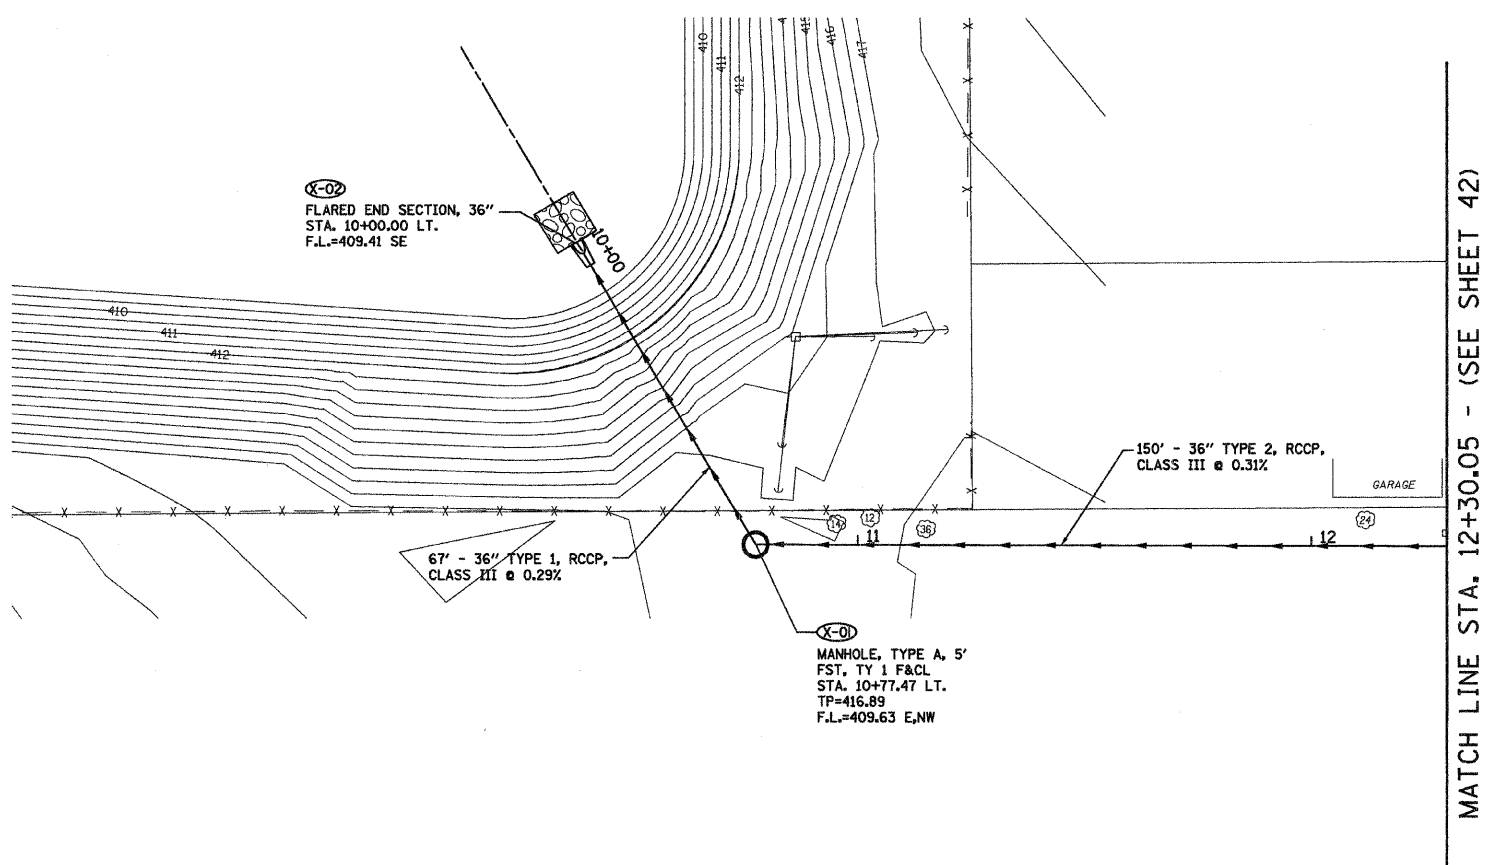

MATCH LINE STA. 12+30.05 - (SEE SHEET 42)

ORIGINAL SURVEY PLOTTED	BY	DATE
NOTE BOOK TEMPLATE		
AREAS CHECKED		
NO.		

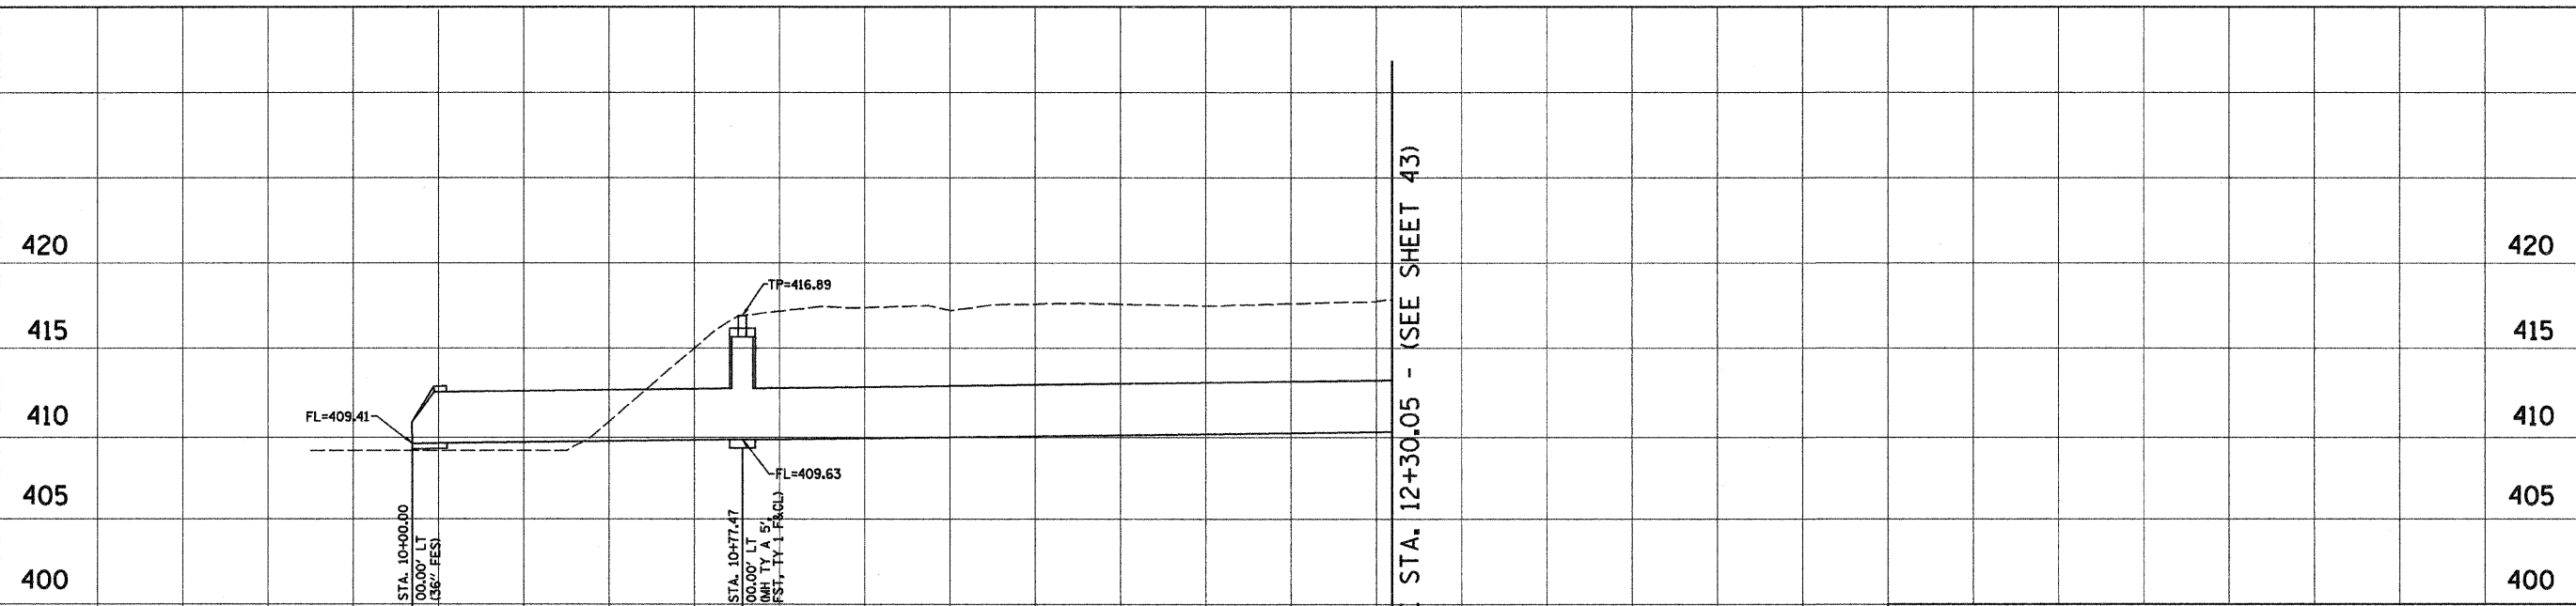

MATCH LINE STA. 12+30.05 - (SEE SHEET 43)

Juneau Associates, Inc. P.C.
CONSULTING ENGINEERS AND LAND SURVEYORS
2500 State Street, P.O. Box 1325
Granite City, Illinois 62040
Phone: (618) 367-1400 / (618) 367-5555
Fax: (618) 367-5541
100 North Research Drive
Edwardsville, Illinois 62025
Phone: (618) 368-0500 / (618) 368-0500
Fax: (618) 368-0541

DRAINAGE PLAN AND PROFILE
F.A.U. ROUTE 9024
MOCKINGBIRD LANE
GRANITE CITY, ILLINOIS
SECTION NO. 07-00187-02-RP

REVISIONS			
NO.	DATE	BY	REMARKS

SCALE: 1 Inch = 20 feet			
DSN. BY: BFK	DATE: 04/03/09	SHEET	
DWN. BY: JDH	DATE: 04/03/09	51	
CHK'D: BFK	DATE: 04/03/09		
DWG. NO.	JOB NO. E050210	DGN. NAME: DRAN.L	OF 111 SHTS