


F.A. RTE.	SECTION	COUNTY	TOTAL SHEETS	SHEET NO.
*	*	*	808	324
STA. TO STA.		FED. ROAD DIST. NO. ILLINOIS FED. AID PROJECT		
*26MB-IBR & 114R-1				

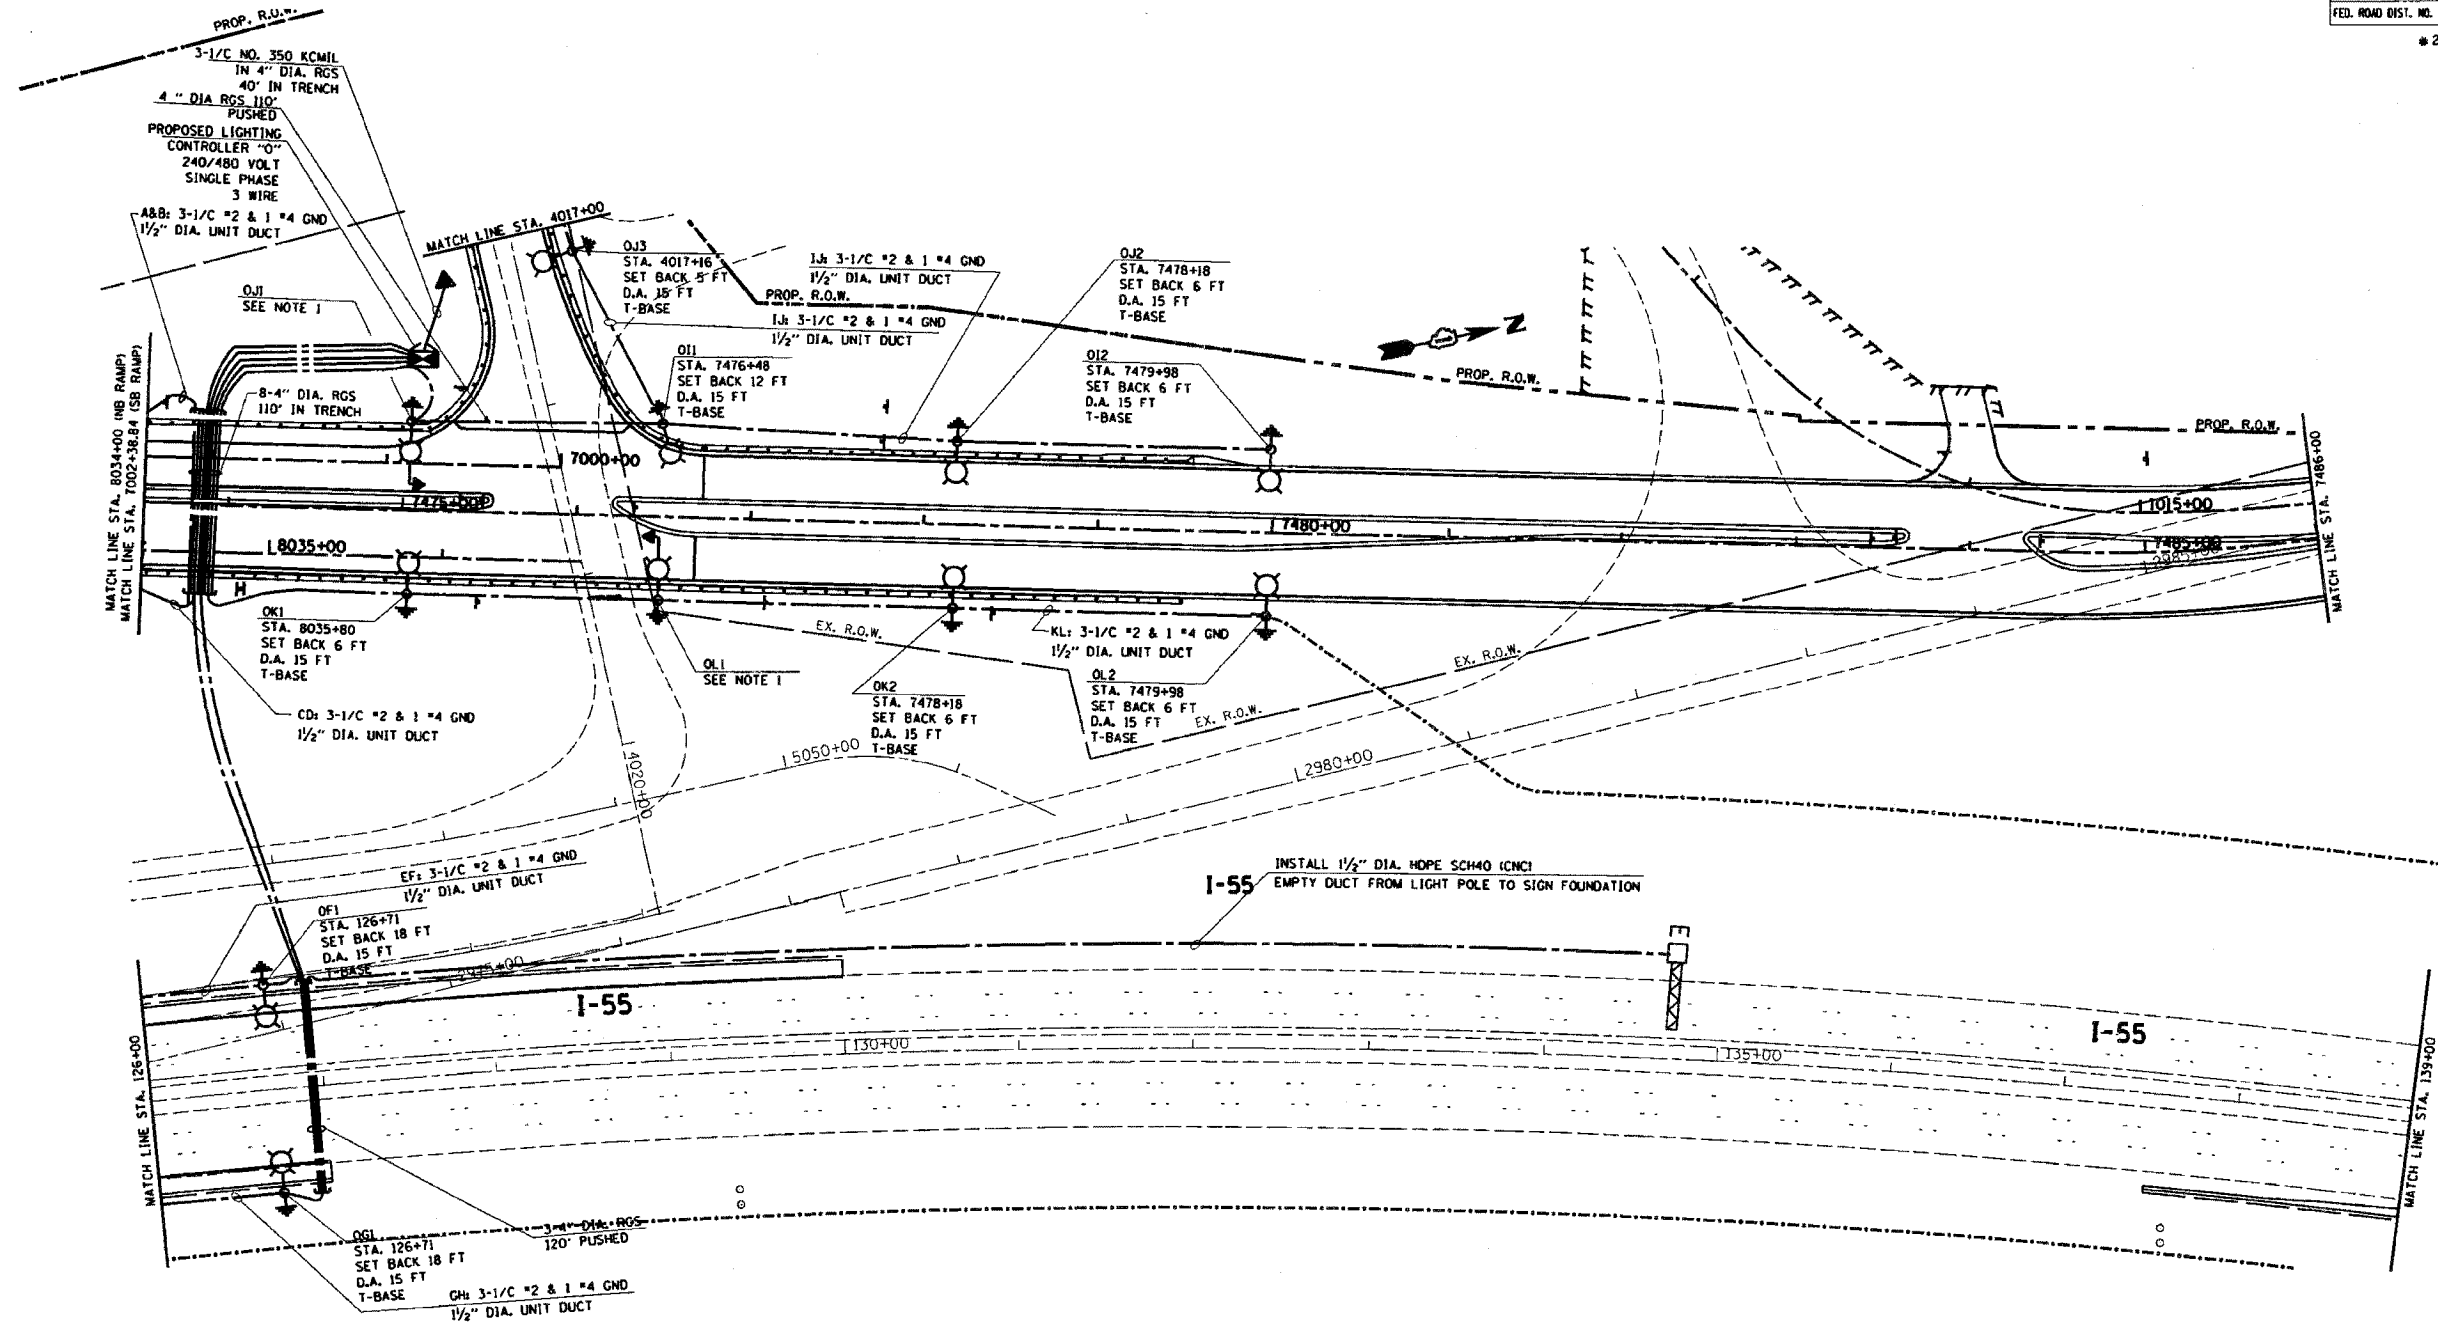

NOTE:
 1. COMBINATION LIGHTING UNIT:
 45 FT LUMINAIRE MOUNTING HEIGHT, 15 FT M.A.
 400 WHPS M-C-III, 240 VOLT LUMINAIRE
 SEE TRAFFIC PLANS FOR PLACEMENT OF THE
 TRAFFIC POLE.

REVISIONS	
NAME	DATE

ILLINOIS DEPARTMENT OF TRANSPORTATION
I-55 AT IL. ROUTE 59
IDOT LIGHTING PLAN
 VERT. SCALE: 1"=50'
 HORIZ. SCALE: 1"=50'
 DATE: 3/13/2008
 DRAWN BY: T.G.
 CHECKED BY: