
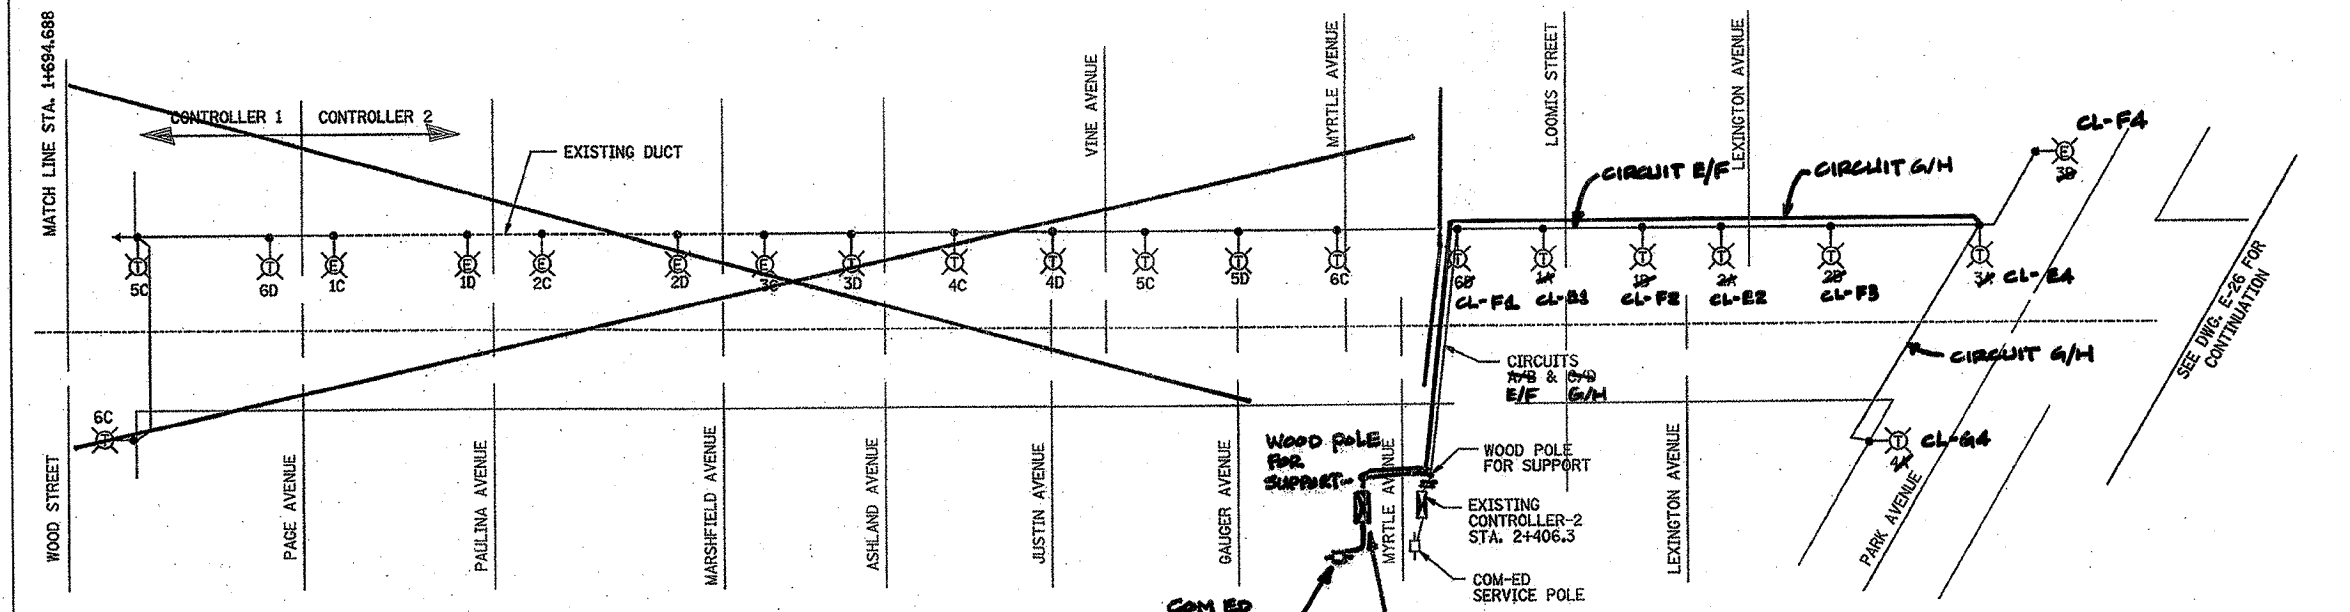


F.A. RTE.	SECTION	COUNTY	TOTAL SHEETS	SHEET NO.
351	2008-001VB	COOK	579	101
STA.	TO STA.			
FED. ROAD DIST. NO.	ILLINOIS	FED. AID PROJECT		

60E10

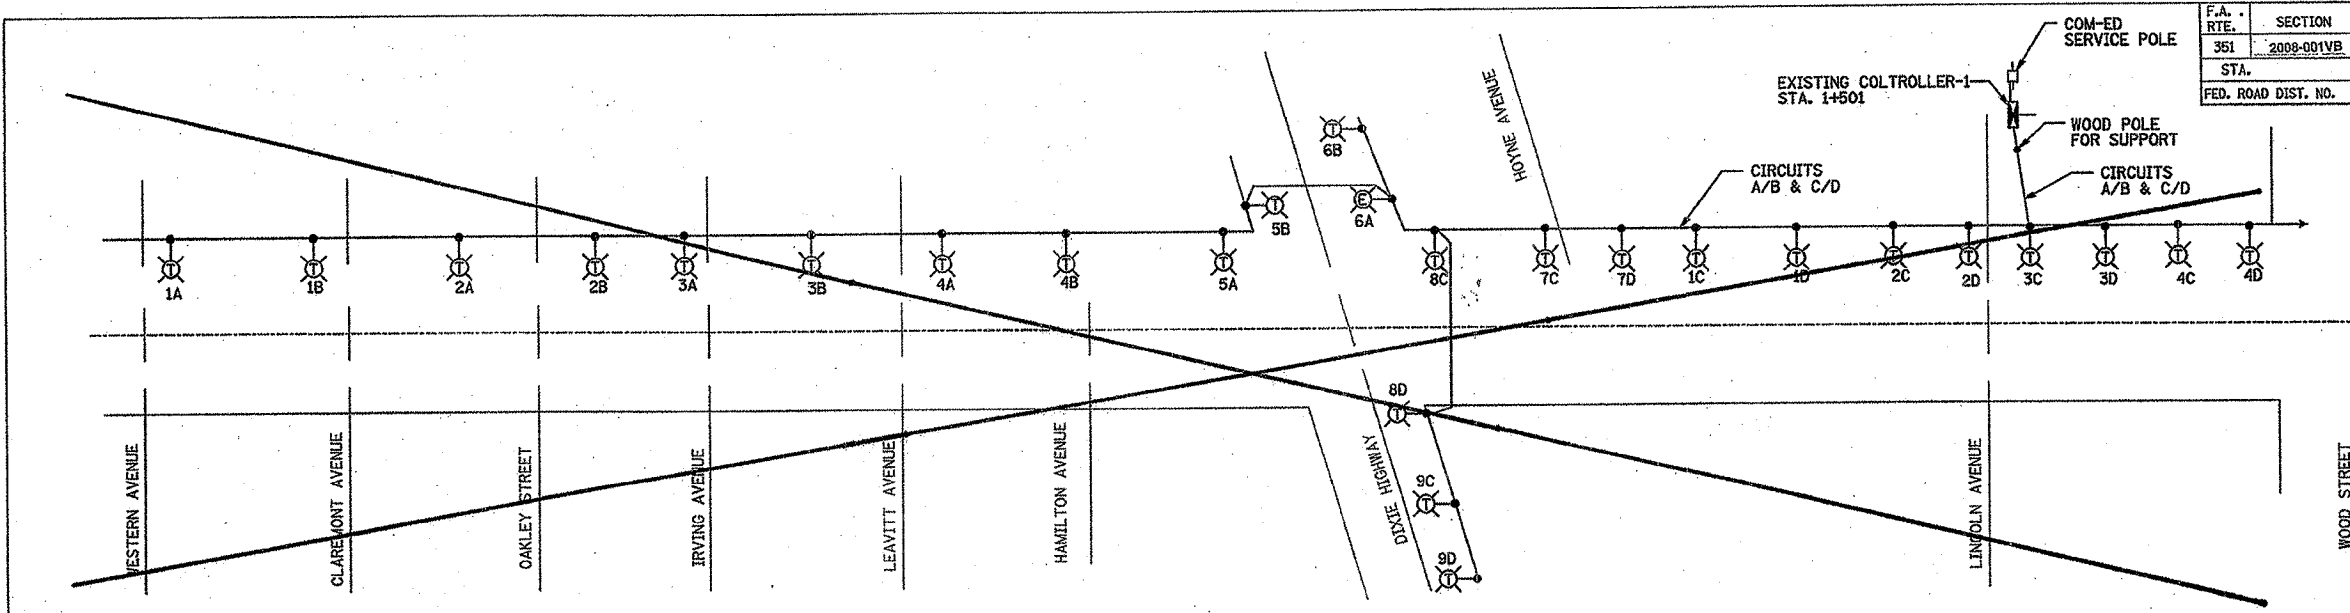

LOAD TABLE

CONTROLLER 1		
CIRCUIT NO.	LOAD	CURRENT
A	2740W	11.41A
B	2800W	11.66A
C	4640W	19.33
D	4165W	17.35A

CONTROLLER 2		
CIRCUIT NO.	LOAD	CURRENT
A	1900W	7.91A
B	1425W	5.93A
C	2520W	10.5A
D	3105W	12.93A

- LEGEND:
- LIGHT POLE, WOOD, WITH 14.5 M MAST ARM
  - EXISTING LIGHT POLE
  - EXISTING LIGHTING CONTROLLER
  - ComEd SERVICE POLE
  - LIGHT POLE, WOOD, FOR SUPPORT

REVISIONS	
NAME	DATE
LRS corp	2/19/08

ILLINOIS DEPARTMENT OF TRANSPORTATION  
 US RTE 6 FROM I-294 TO IL RTE 1  
 SINGLE LINE DIAGRAM  
 TEMPORARY LIGHTING  
 SHEET '1' OF '2'  
 DRAWN BY S.S./W.S.  
 CHECKED BY C.K./H.S.  
 DATE 12/12/07

Delta Engineering, Inc.  
 CONSULTING ENGINEERS, CHICAGO, ILLINOIS