


F.A.I. RTE.	SECTION	COUNTY	TOTAL SHEETS	SHEET NO.
345	BR-IN-1	COOK	196	94
STA. 201+25		TO STA. 229+00		
FED. ROAD DIST. NO.	ILLINOIS	FED. AID PROJECT		

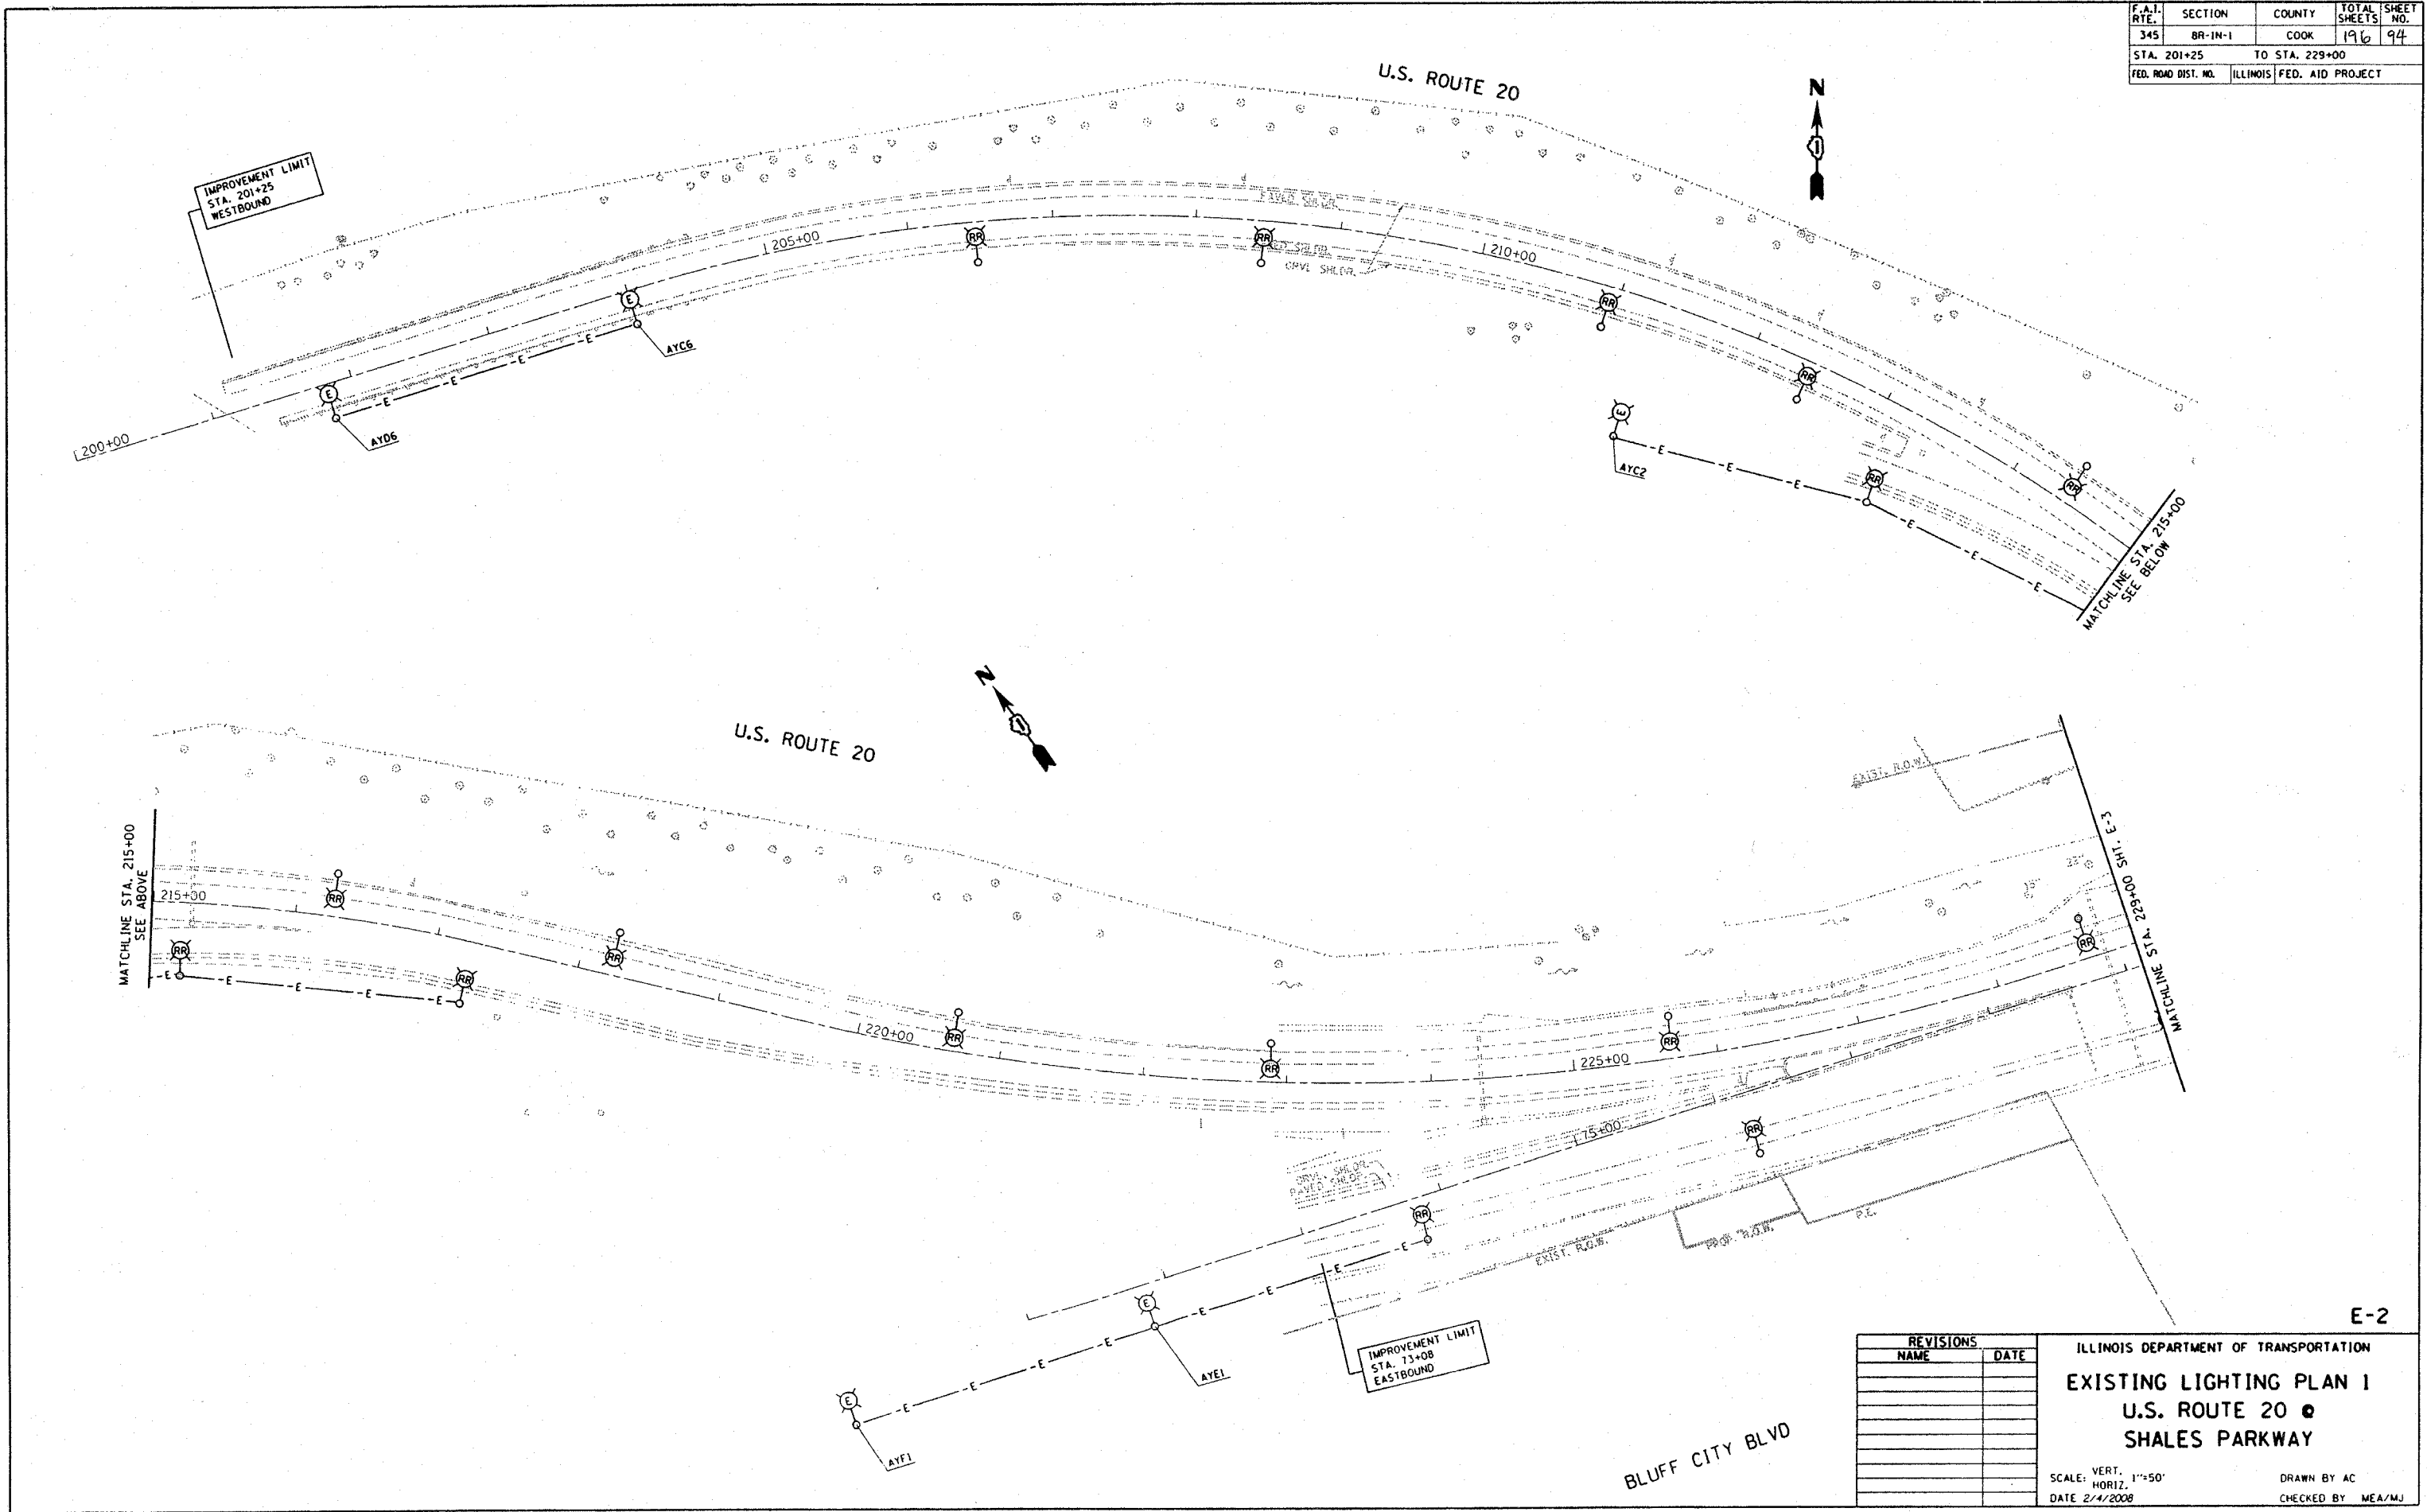

E-2

REVISIONS	
NAME	DATE

ILLINOIS DEPARTMENT OF TRANSPORTATION
EXISTING LIGHTING PLAN 1
U.S. ROUTE 20
SHALES PARKWAY

SCALE: VERT. 1"=50'
 HORIZ. DATE 2/4/2008
 DRAWN BY AC
 CHECKED BY MEA/MJ

PLOT DATE : 2/4/2008
 FILE NAME : c:\pwworkspace\113703\sh_lighting.dgn
 USER NAME : gmgilbert