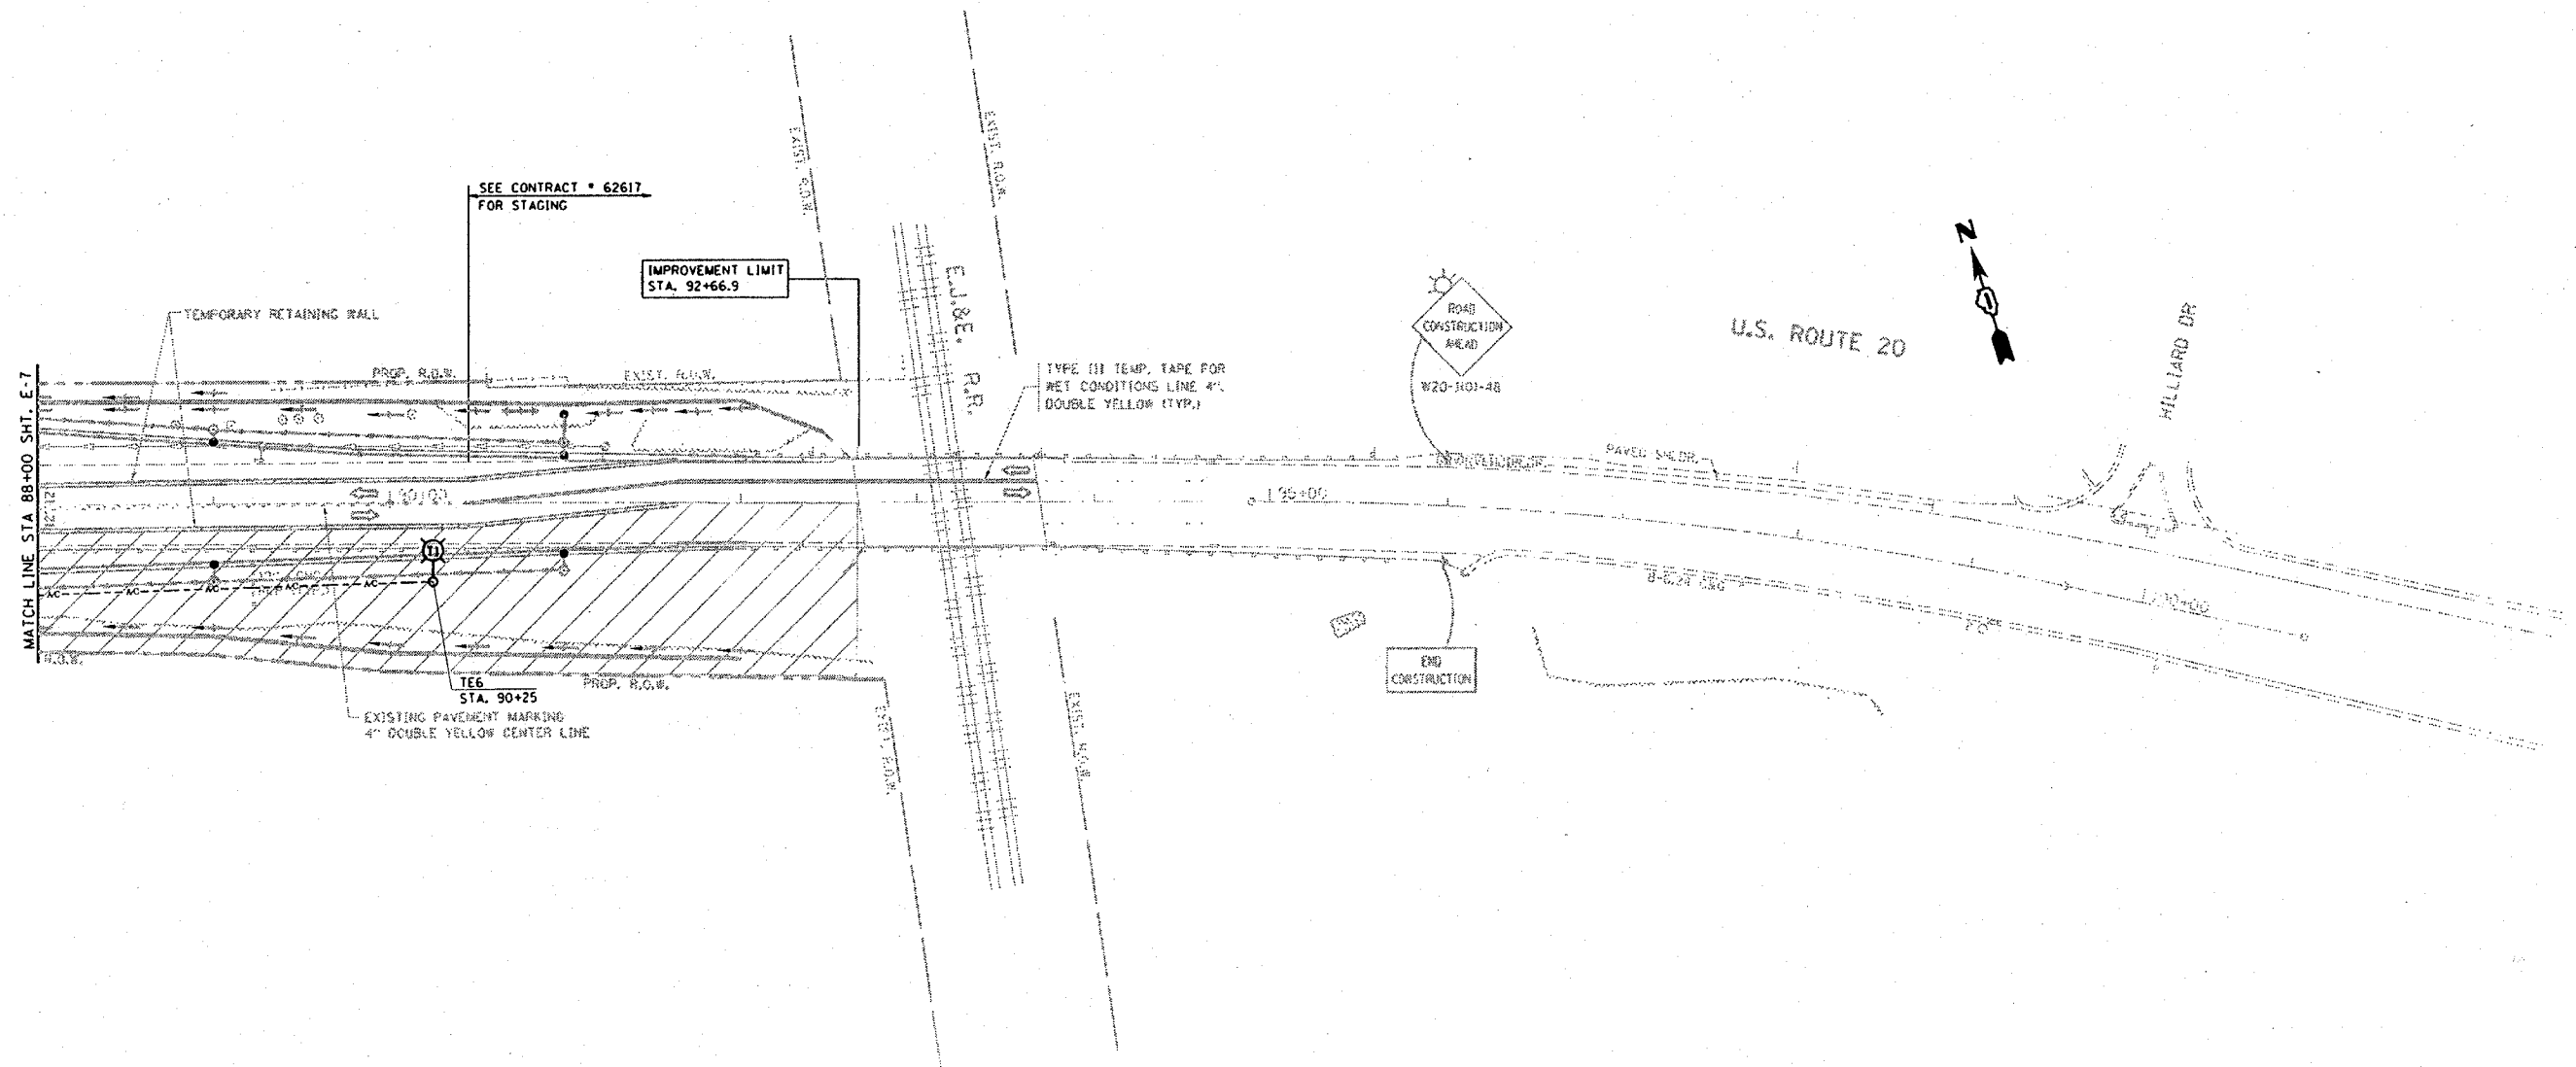


 
 
 
 


CONTRACT NO.				
F.A. RTE.	SECTION	COUNTY	TOTAL SHEETS	SHEET NO.
345	8(R-1-N-1)	COOK	196	103
STA.		TO STA.		
FED. ROAD DIST. NO.		ILLINOIS	FED. AID PROJECT	



LEGEND

-  SIGN
-  DRUMS WITH STEADY BURN MONODIRECTIONAL LIGHT
-  50' C-C TANGENTS
-  25' C-C LANE SHIFTS & TAPERS
-  10' C-C RADII (TYP)
-  WORK AREA

REVISIONS	
NAME	DATE

ILLINOIS DEPARTMENT OF TRANSPORTATION

STAGE 1B CONSTRUCTION LIGHTING PLAN

U.S. RTE. 20 @ SHALES PARKWAY AND BLUFF CITY BLVD.

SCALE: VERT. 1"=50'
 HORIZ. 1"=100'
 DATE 2/4/2008

DRAWN BY AC
 CHECKED BY MEA/MJ

PLOT DATE : 2/4/2008
 FILE NAME : c:\users\jag\appdata\local\temp\dgn
 PLOT SCALE : 1/8"=100' / 1"=1000'
 USER NAME : greg.hobbs