

F.A.U. RTE.	SECTION	COUNTY	TOTAL SHEETS	SHEET NO.
2678	08-00169-00-LT	DuPAGE	39	24
STA.	TO STA.			
FED. ROAD DIST. NO.	ILLINOIS	FED. AID PROJECT		
CONTRACT NO. 63027				

LAKOTA
THE LAKOTA GROUP INC
212 West Kinzie Street, 3rd Floor
Chicago, Illinois 60610
p 312.467.5445
f 312.467.5484
info@thelakotagroup.com

Planning
Urban Design
Landscape Architecture
Community Relations

CITY CENTRE PLAZA
Elmhurst, Illinois

City of Elmhurst

ISSUED FOR BID




FOUNTAIN PLAN & SECTIONS

Revisions	Issued for Bid	02/22/08


Date: 02/22/08
Drawn By: MR, JS
Checked By: ME




L-06

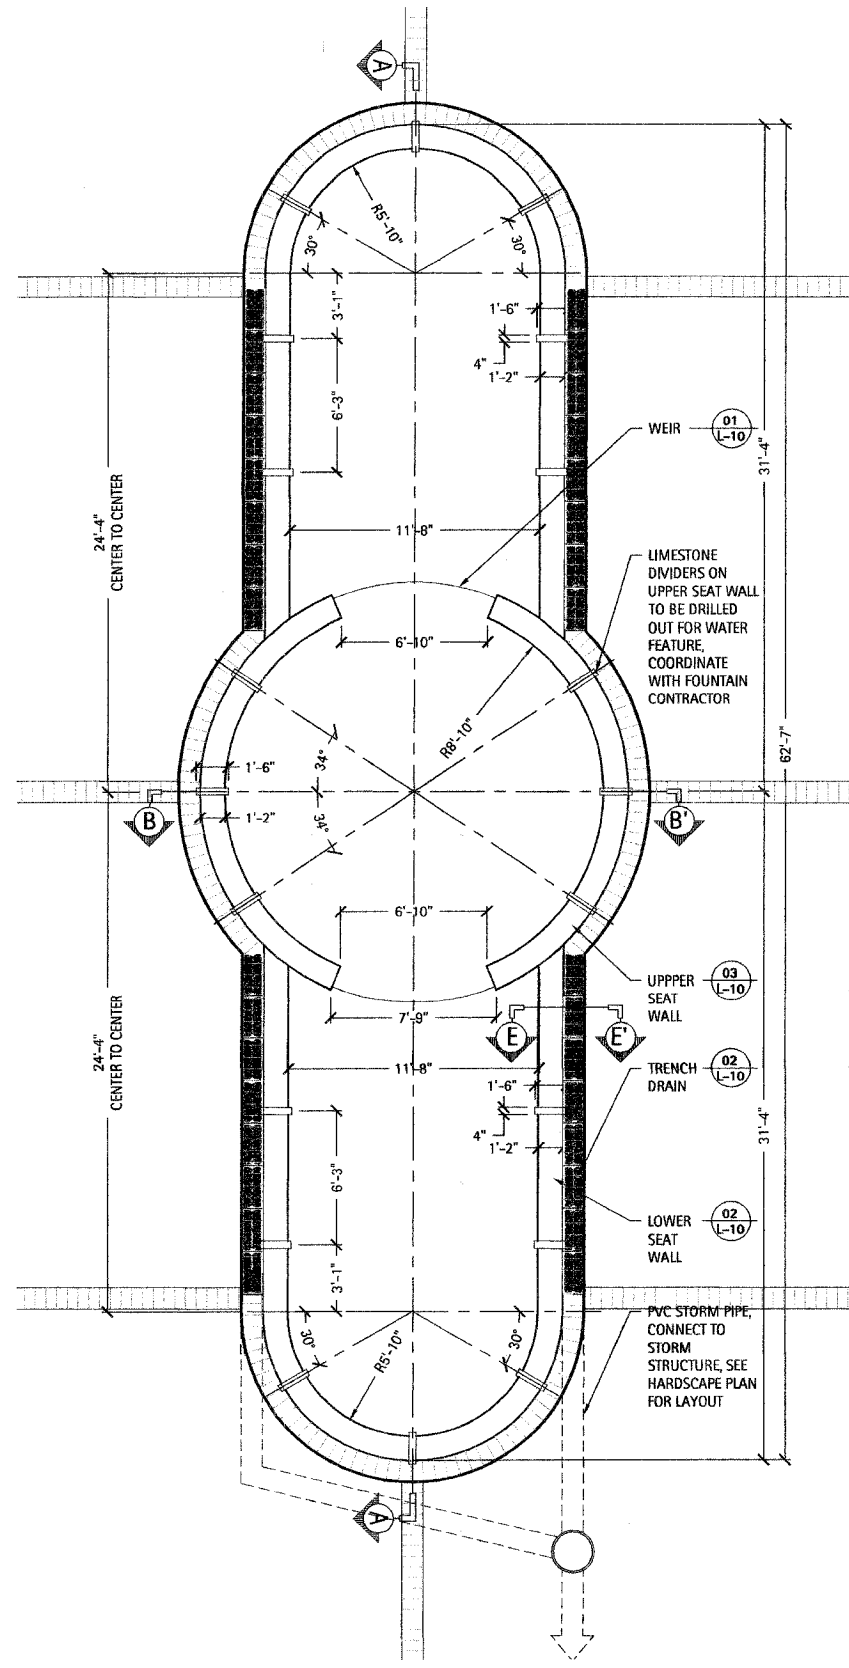

1 Fountain Plan
Scale: 1/4" = 1'-0"

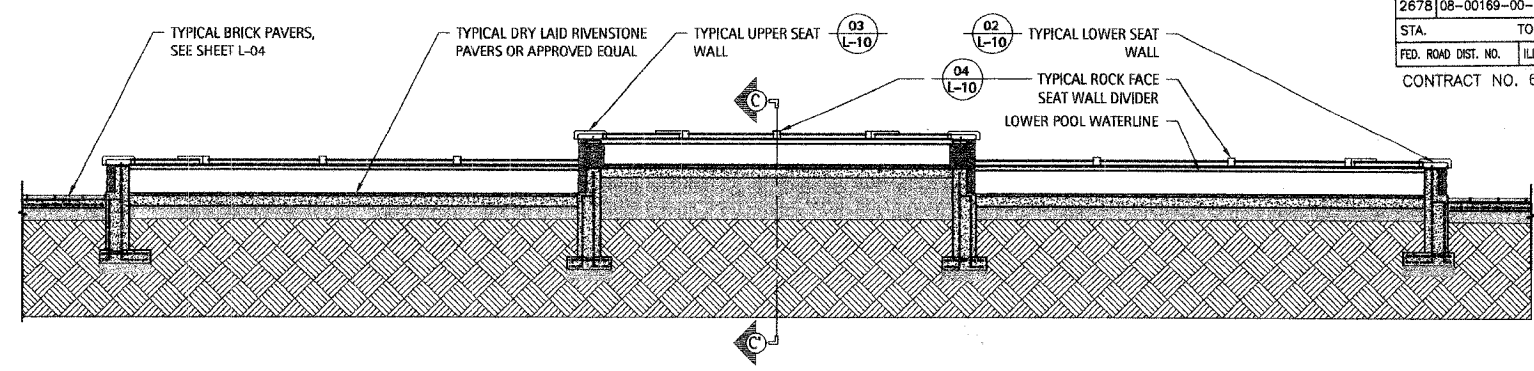

2 Fountain Section A-A'
Scale: 1/4" = 1'-0"

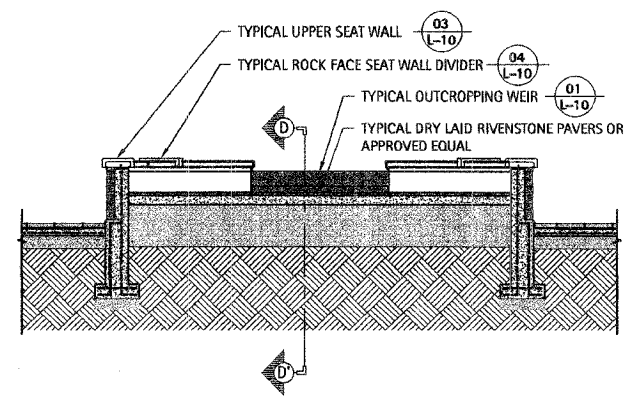

3 Fountain Section B-B'
Scale: 1/4" = 1'-0"

NOTES:

- 1.) COORDINATE ALL WORK WITH FOUNTAIN CONTRACTOR
- 2.) TOP OF WALLS TO ALWAYS REMAIN LEVEL
- 3.) BOTTOM OF FOUNTAIN TO PITCH TOWARDS FOUNTAIN DRAIN. INSTALL ONE DRAIN IN EACH LOWER WALL SECTION
- 4.) WEIR TO INCLUDE WATER MAKE-UP SPOUT INSTALLED BY FOUNTAIN CONTRACTOR
- 5.) SEE CIVIL PLANS FOR TOP/BOTTOM OF WALL, FINISHED GRADES AROUND FOUNTAIN, INVERT ELEVATIONS FOR TRENCH DRAINS AND STORM SEWER ELEVATIONS