


GENERAL NOTES

1. PLACE DETECTOR LOOPS IN BINDER.
2. DETECTOR LOOPS SHALL HAVE FOUR TURNS.
3. SAW CUT EXISTING DETECTOR LOOP TO BE ABANDONED.
4. THE DEPARTMENT OF TRANSPORTATION (815-434-8506) SHALL BE NOTIFIED AT LEAST 72 HOURS PRIOR TO THE LAYOUT OF THE DETECTOR LOOPS.

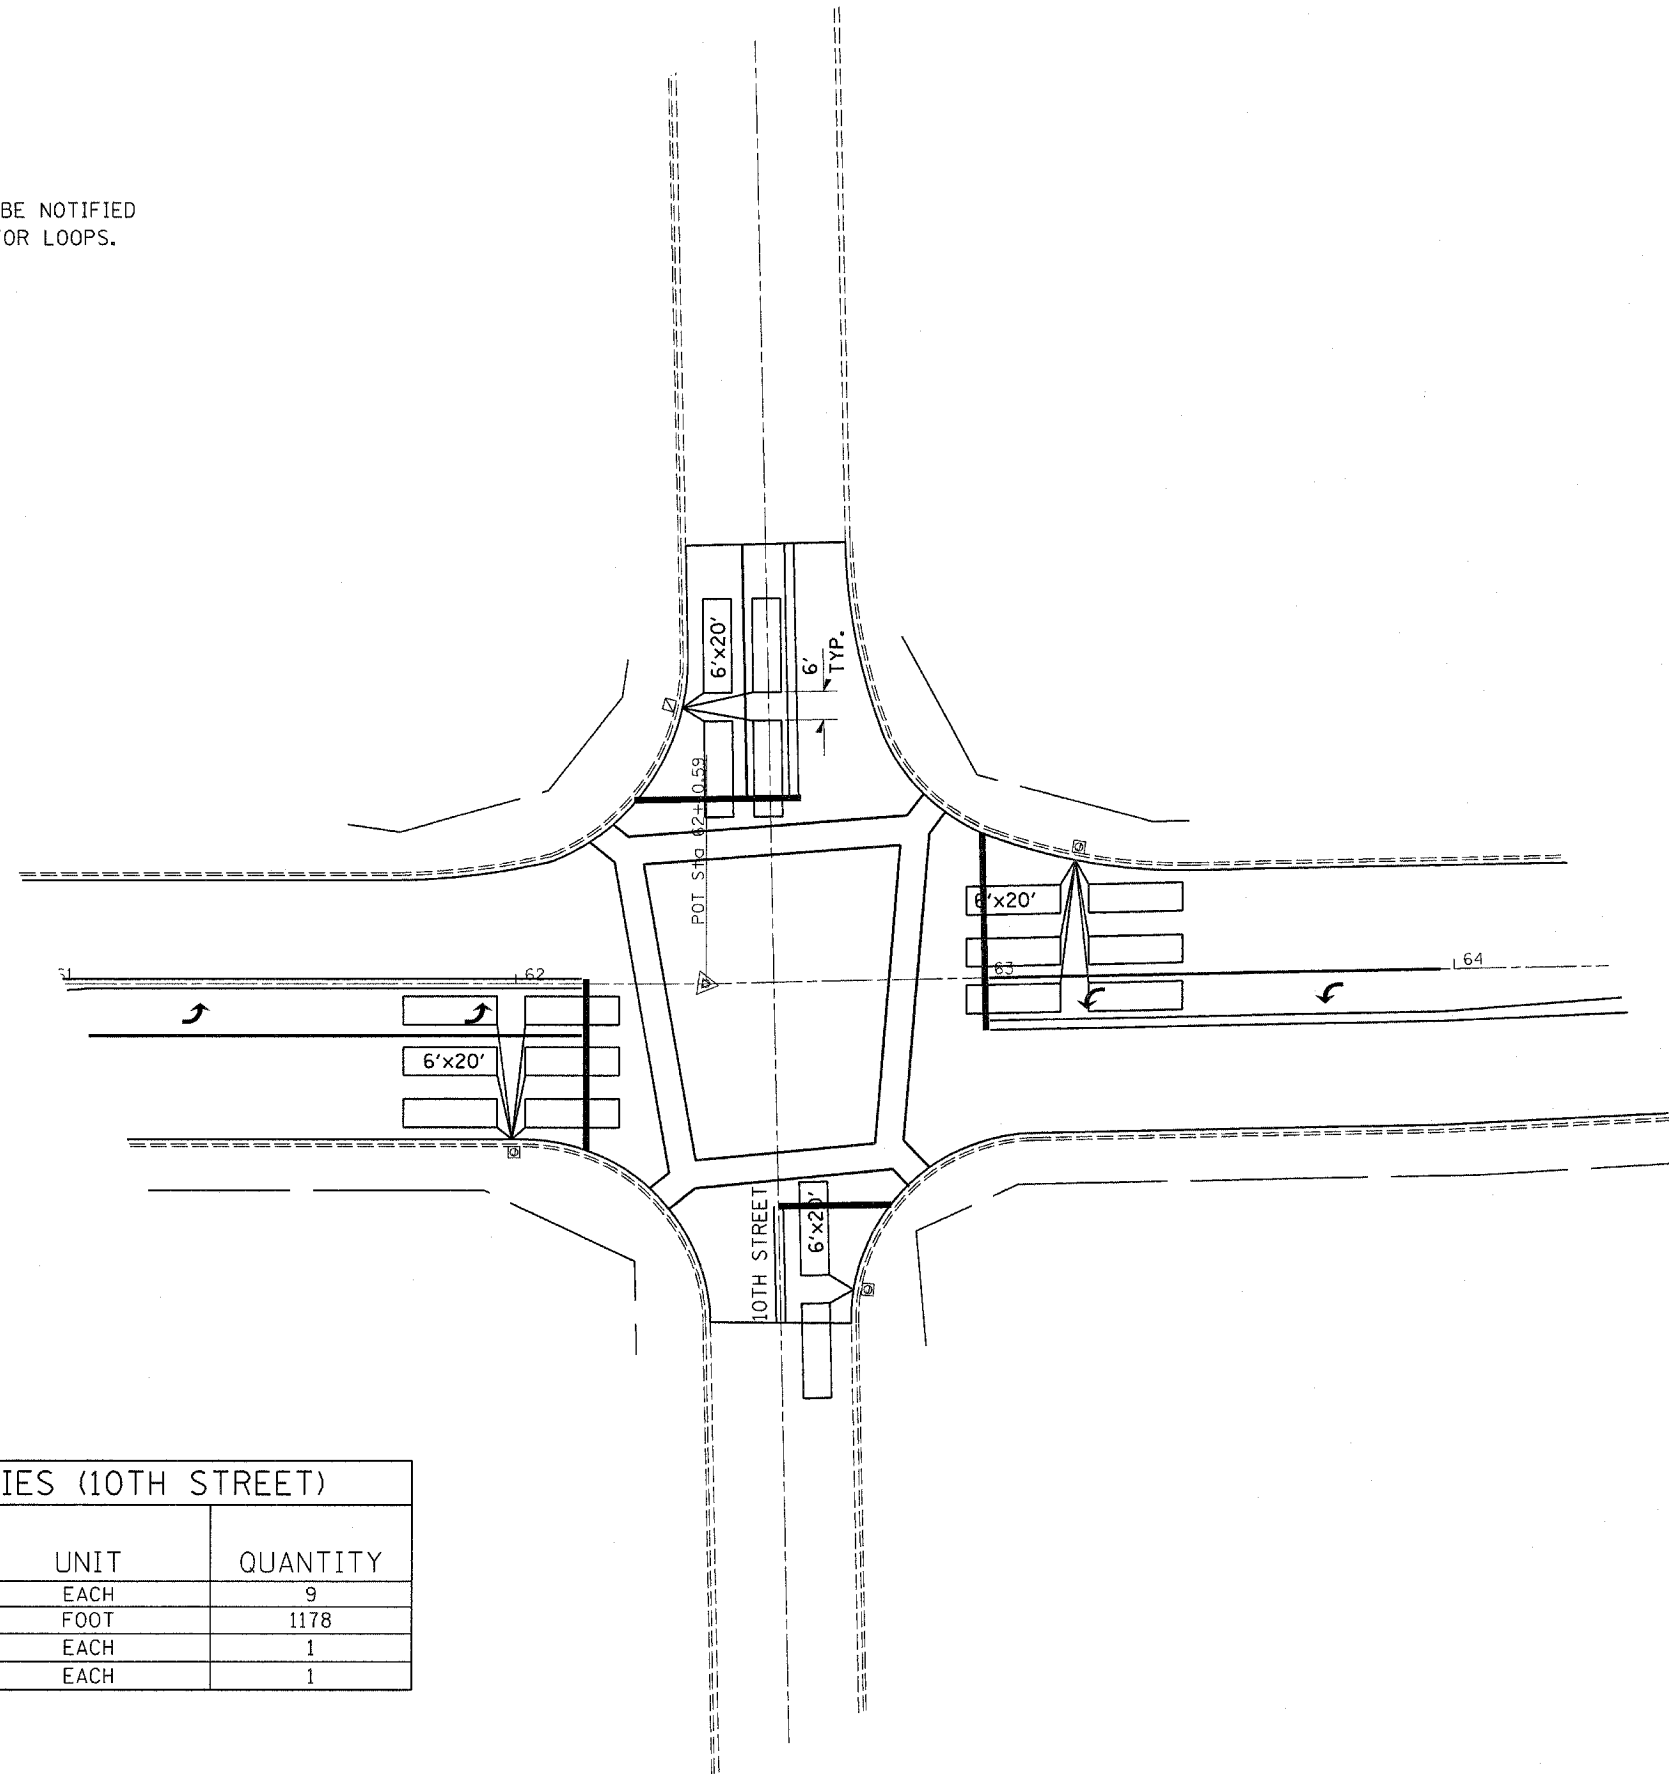

ELECTRICAL SCHEDULE OF QUANTITIES (10TH STREET)

DESCRIPTION	UNIT	QUANTITY
INDUCTIVE LOOP DETECTOR	EACH	9
DETECTOR LOOP, TYPE 1	FOOT	1178
LOOP DETECTOR TESTING	EACH	1
MODIFY EXISTING CONTROLLER CABINET	EACH	1



FILE NAME = c:\projects\ed83106\sheets.dgn	USER NAME = duncenbd	DESIGNED -	REVISED -	STATE OF ILLINOIS DEPARTMENT OF TRANSPORTATION	TRAFFIC SIGNALS - 10TH STREET	F.A.P. RTE.	SECTION	COUNTY	TOTAL SHEETS	SHEET NO.
	PLOT SCALE = 20,000' / IN.	DRAWN -	REVISED -			567	(7,6)RS-2	DEKALB	52	41
	PLOT DATE = Mar 21, 2008 - 03:54:03 PM	CHECKED -	REVISED -			CONTRACT NO. 66633				
	DATE -	REVISED -		SCALE:	SHEET NO. OF SHEETS STA. TO STA.	FED. ROAD DIST. NO. ILLINOIS FED. AID PROJECT				