


F.A.P. RTE.	SECTION	COUNTY	TOTAL SHEETS	SHEET NO.
324	(7) DM	DEKALB	24	18
STA.		TO STA.		
FED. ROAD DIST. NO. 3		ILLINOIS FED. AID PROJECT		

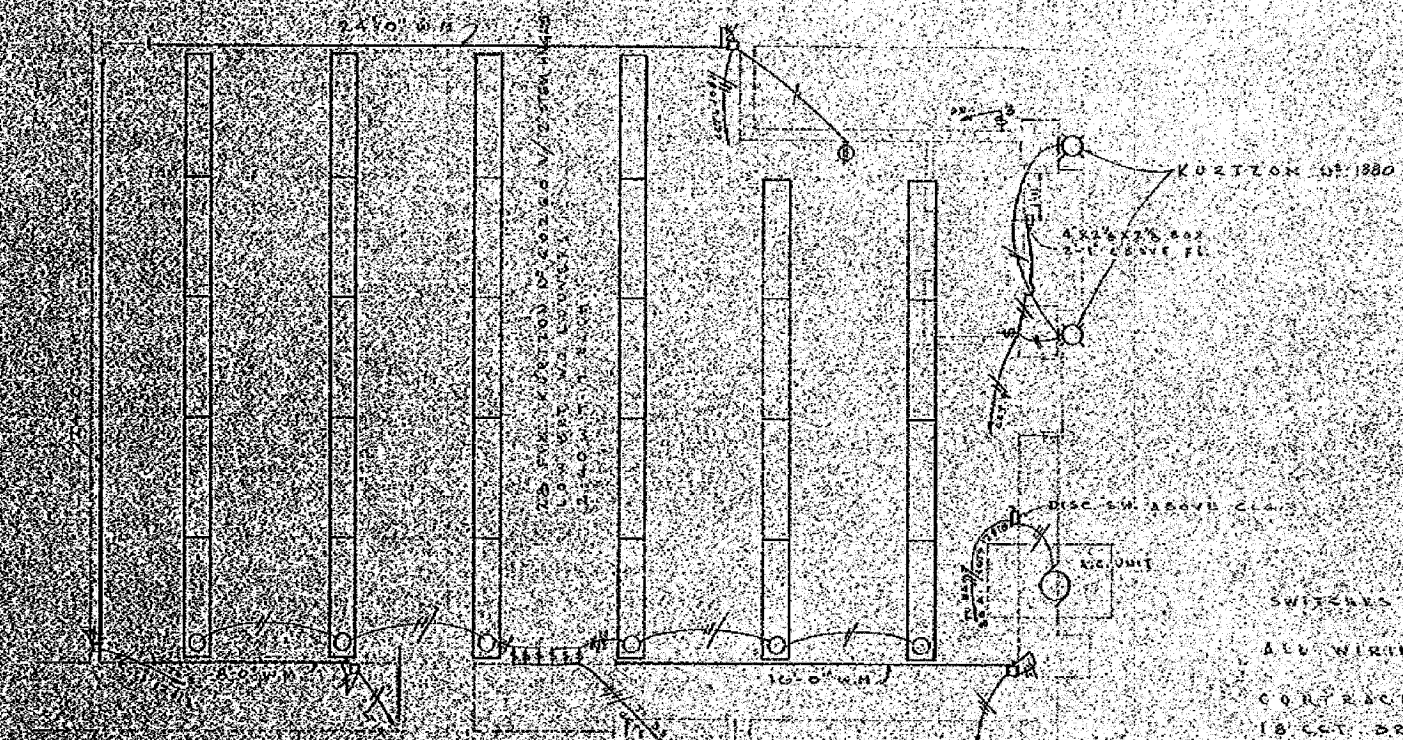

EXISTING FLOOR PLAN
SCALE: 1/4" = 1'-0"

CONTRACTOR SHALL FURNISH AND INSTALL 18 COT BREAKER TYPE PANEL IN EXISTING BANK BLDG BASEMENT TAP INTO MAIN FEEDERS AFTER MAIN DISC SW. PANEL TO BE SOUNDED OR EQUAL.
 8-15 AMP CTS - 1 LG
 0-20 AMP CTS - 2 SC
 2-30 AMP CTS - AC UNIT

SWITCHES SHALL BE QUINCY TYPE.
 ALL WIRING SHALL BE IN CONDUIT.
 CONTRACTOR SHALL FURNISH AND INSTALL 18 COT BREAKER TYPE PANEL IN EXISTING BANK BLDG BASEMENT TAP INTO MAIN FEEDERS AFTER MAIN DISC SW. PANEL TO BE SOUNDED OR EQUAL.
 8-15 AMP CTS - 1 LG
 0-20 AMP CTS - 2 SC
 2-30 AMP CTS - AC UNIT
 ALL WORK SHALL BE DONE IN ACCORDANCE WITH LOCAL, STATE & NATL CODES.
 CONTRACTOR SHALL FURNISH & INSTALL 4 LIGHTS (PARC.) LED 2-3 WAY SW IN BSMT BELOW THIS FLOOR EXTEND TO MEN PANEL.
 ALL CONDUIT SHALL BE CONCEALED.



REVISION	ADDITIONS AND ALTERATIONS TO THE DE KALB TRUST AND SAVINGS BANK DE KALB ILLINOIS	JOB 5831A	SHEET E-7
	WALTER E FOSS BANK DESIGNERS 33 SOUTH CLARK STREET CHICAGO 3 ILLINOIS	SCALE AS NOTED	DRAWN BY PEM
		DATE 3-23-59	DRAWING 66016

PLOT DATE = 4/27/59
 PLOT SCALE = AS NOTED
 USER NAME = ARR

REVISIONS	
NAME	DATE

ILLINOIS DEPARTMENT OF TRANSPORTATION
 EXISTING PLAN
 FAP 324 (IL 23)
 SECTION (7) DM
 DEKALB COUNTY
 SCALE: VERT. _____
 HORIZ. _____
 DATE _____
 DRAWN BY A.R.R.
 CHECKED BY J.K.C.

FOR INFORMATION ONLY