
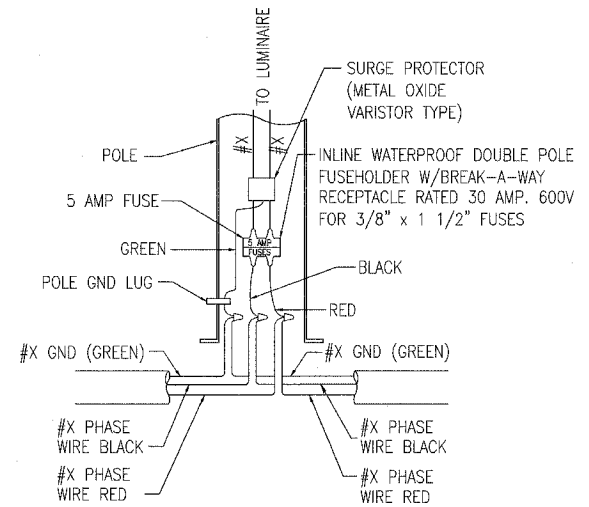


F.A. RTE.	SECT-ION	COUNTY	TOTAL SHEETS	SHEET NO.
	05-00174-00-BT	ROCK ISLAND	112	50
STA.		TO STA.		
FED. ROAD DIST. NO.		ILLINOIS FED. AID PROJECT		

LIGHTING PLANS

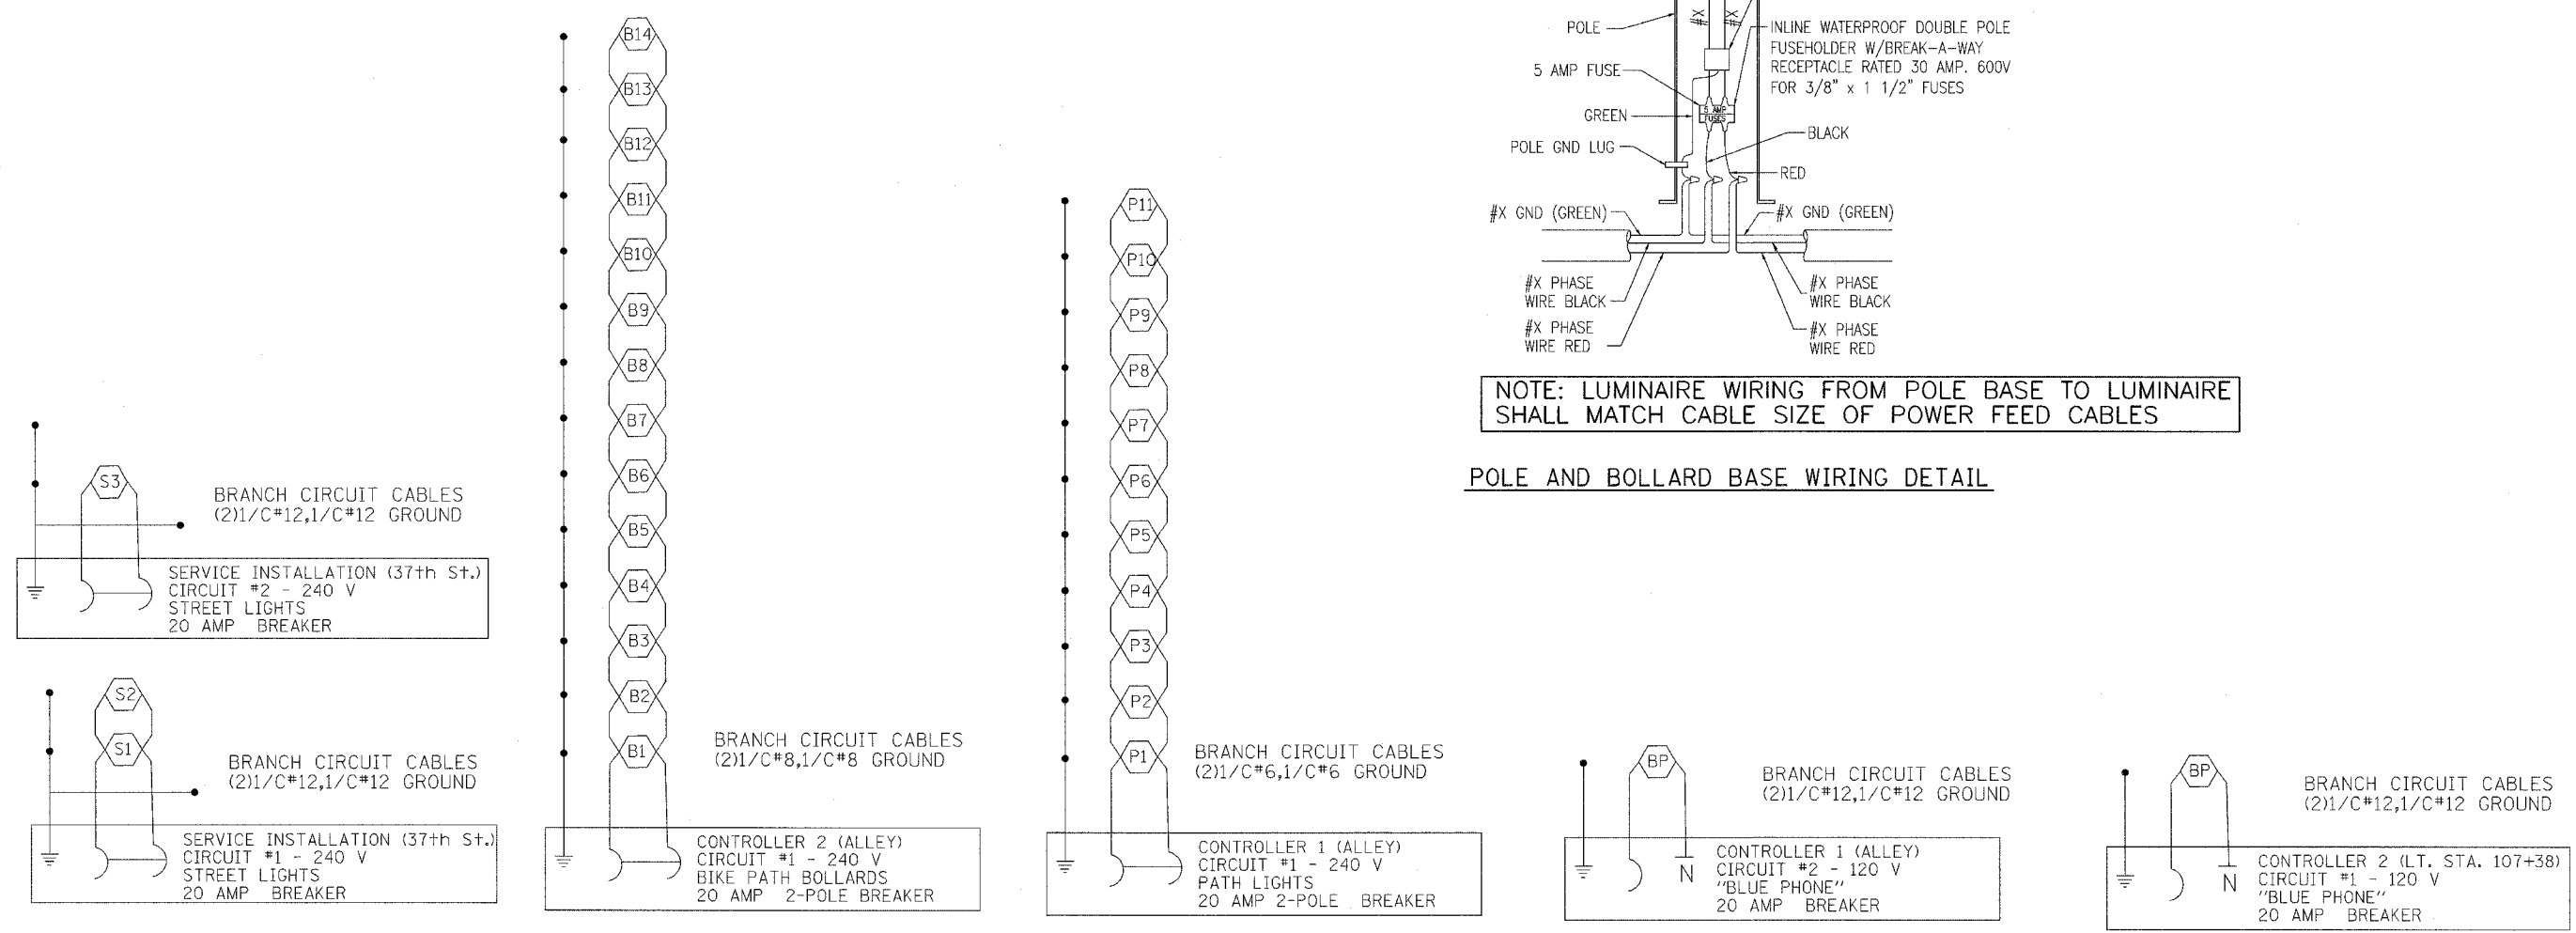

NOTE: LUMINAIRE WIRING FROM POLE BASE TO LUMINAIRE SHALL MATCH CABLE SIZE OF POWER FEED CABLES

POLE AND BOLLARD BASE WIRING DETAIL

NOTE: THE #12 CABLE FROM THE SERVICE INSTALLATION AT 37TH ST. TO THE LIGHT AT 38TH ST. (S3) IS A HOMERUN CABLE.

NOTE: THE #8 GROUND CABLE SHALL BE SPLICED IN THE HANDHOLE LEFT STA. 3+90 AND AN INDIVIDUAL #8 GROUND CABLE INSTALLED TO THE "BLUE PHONE" CIRCUIT, THE BOLLARD CIRCUIT AND THE PATH LIGHT CIRCUIT.

PLOT DATE =
FILE NAME =
PLOT SCALE =
USER NAME =

REVISIONS		ILLINOIS DEPARTMENT OF TRANSPORTATION
NAME	DATE	
		CIRCUIT DIAGRAMS

SCALE: VERT. _____
HORIZ. _____
DATE _____

DRAWN BY _____
CHECKED BY _____